
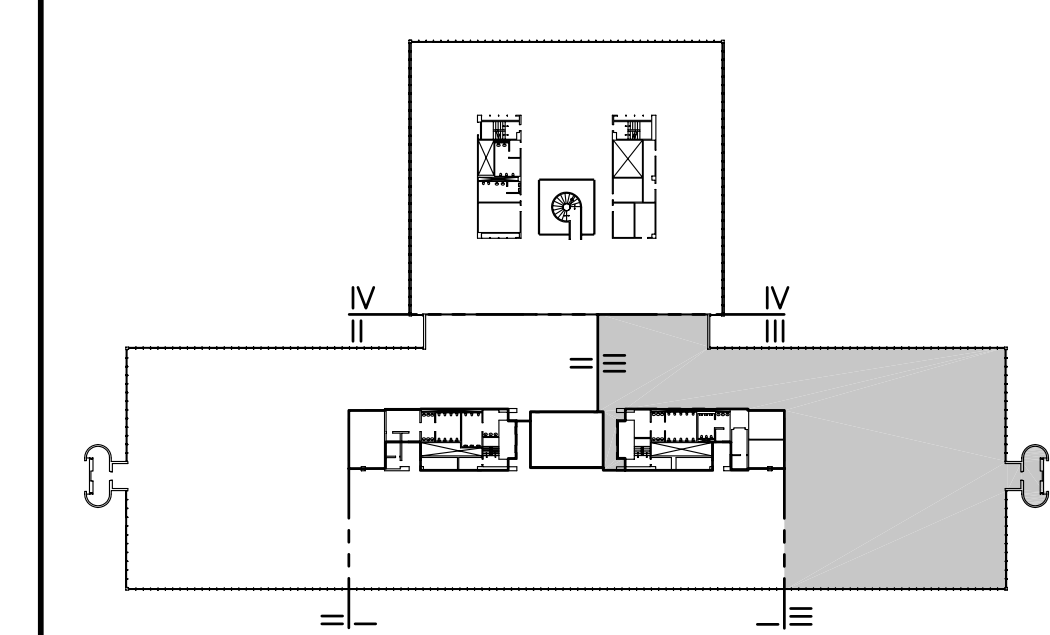


NOTE:


1. SEE SHEET E-001 FOR LEGEND AND GENERAL NOTES.
2. SEE SHEET EP101 FOR LOCATION OF PANELBOARDS LL2E3 & LL2E5.

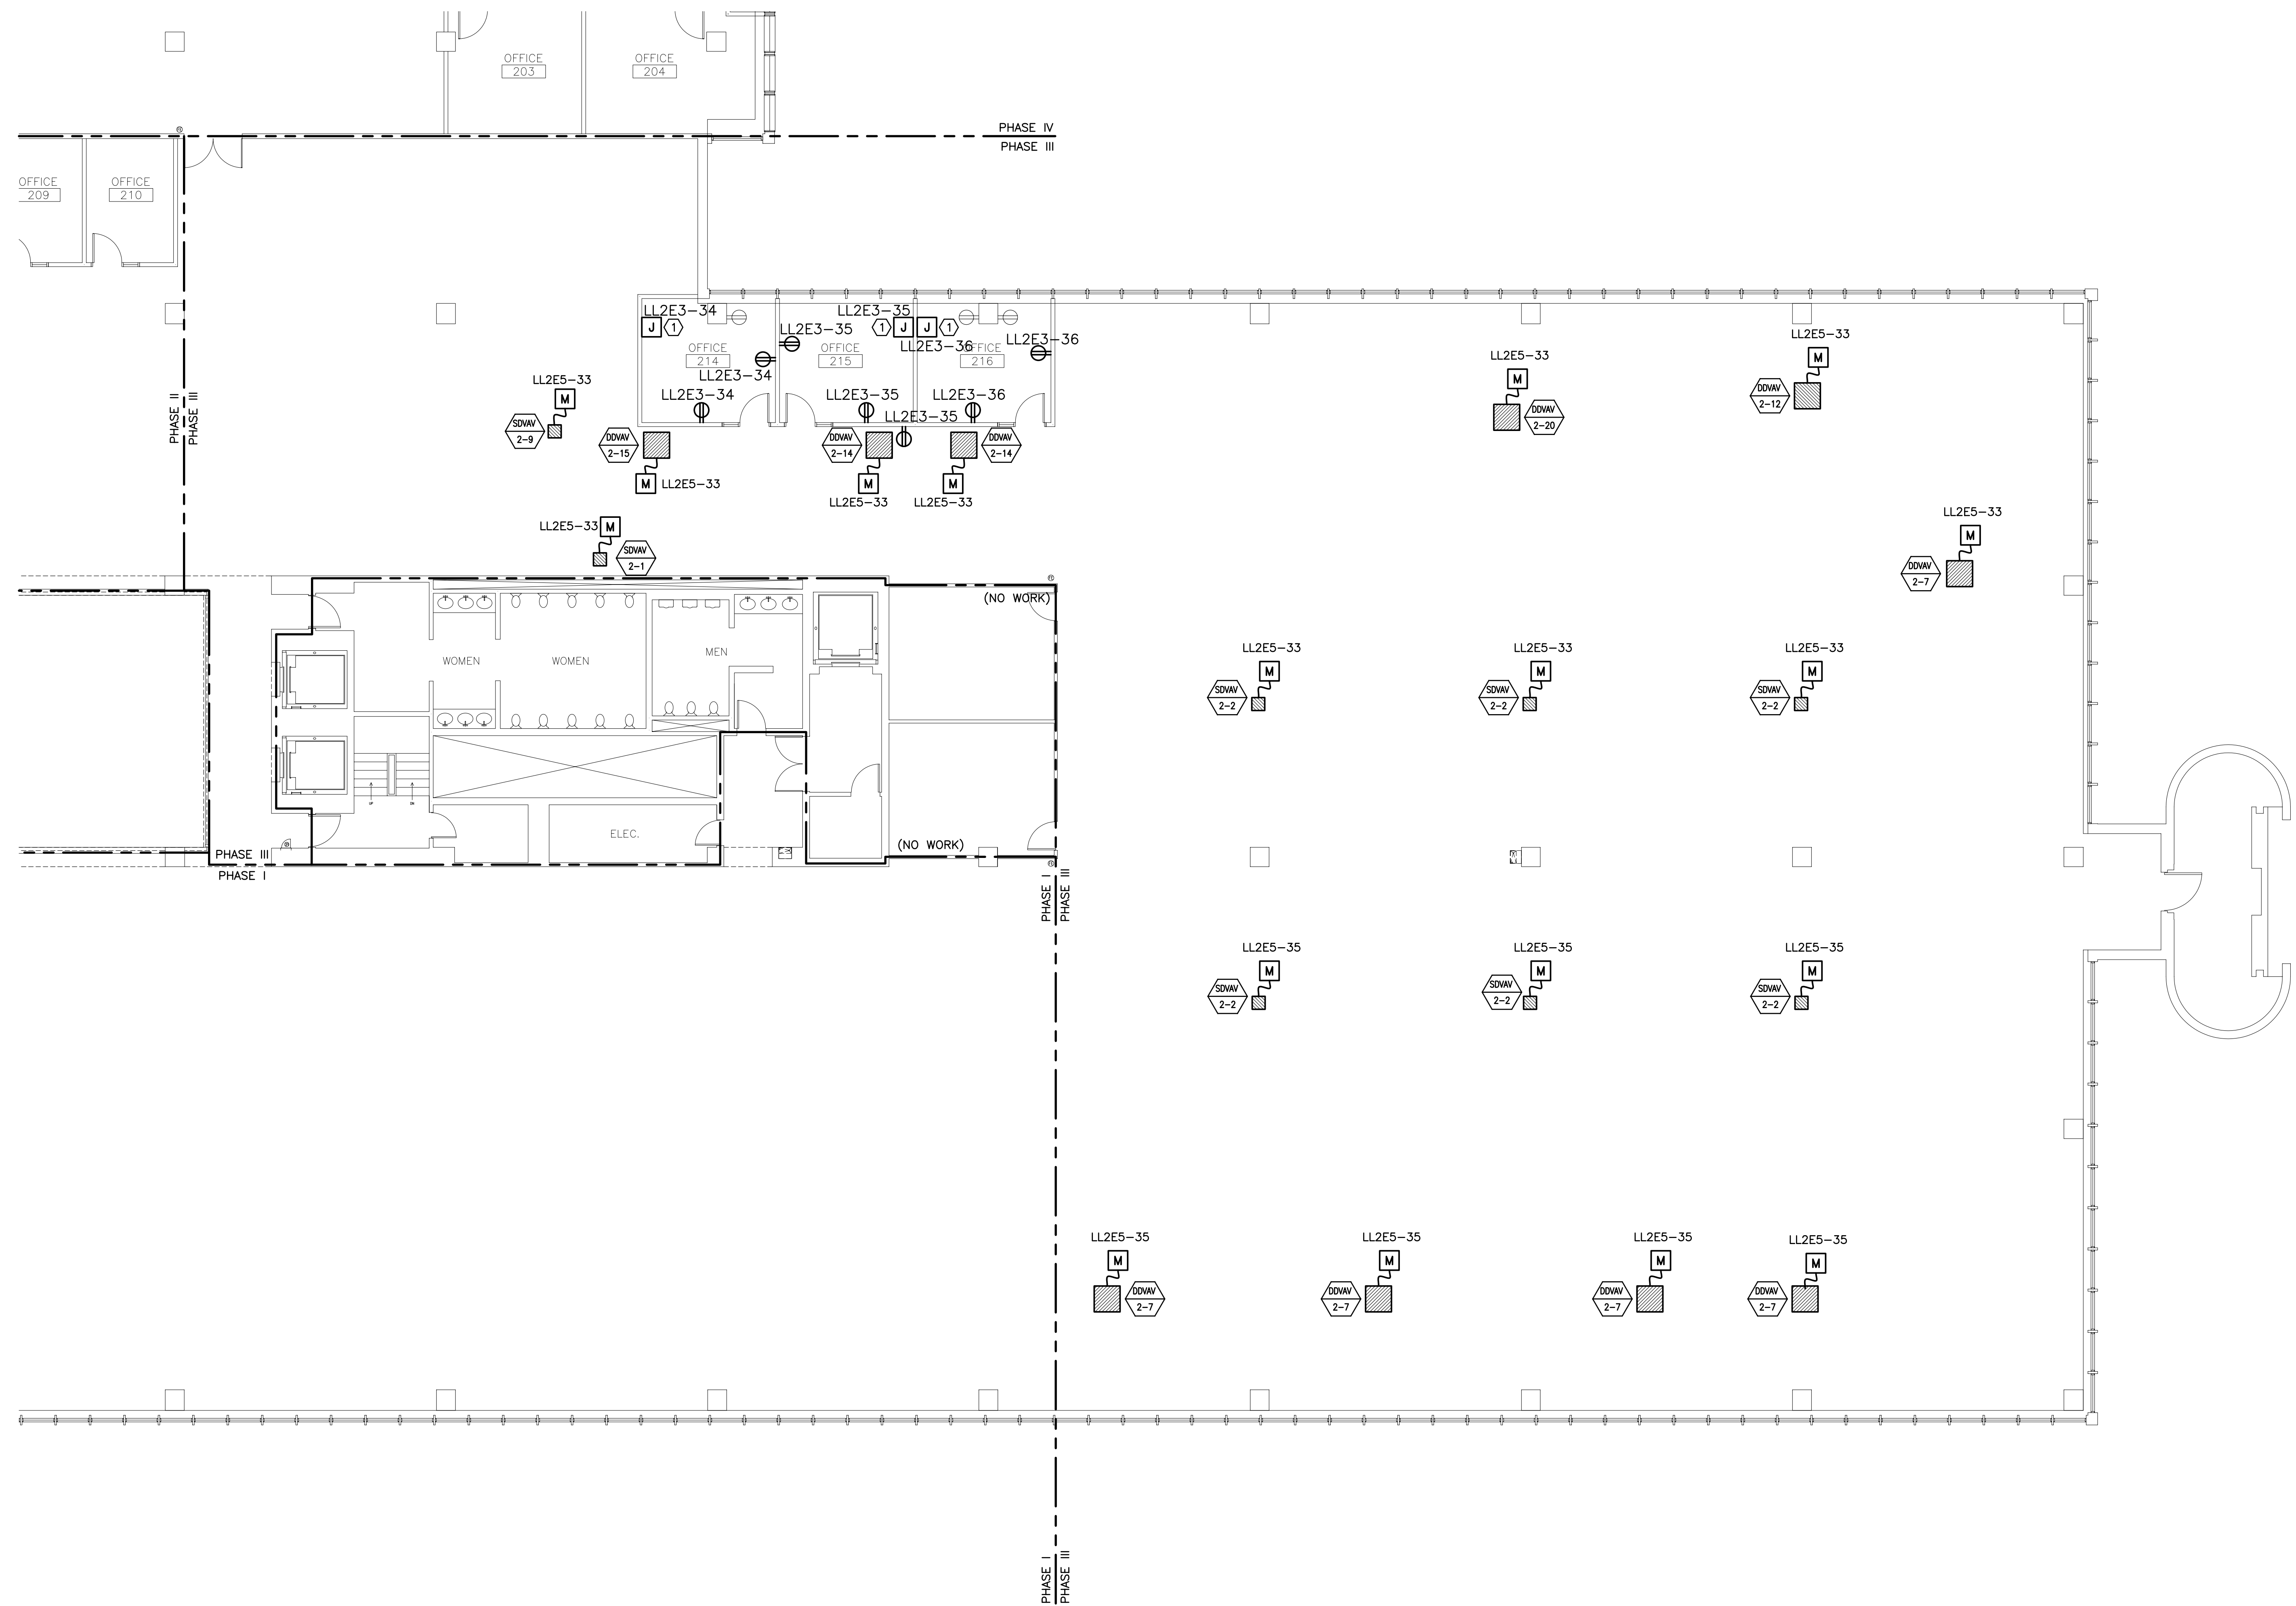

F18 KEY PLAN

| | |
|--------------|-------------------------|
| NOT TO SCALE | |
| 0 | ISSUED FOR CONSTRUCTION |
| REV. | DESCRIPTION |
| | DATE |

ISSUED FOR CONSTRUCTION
1-28-04

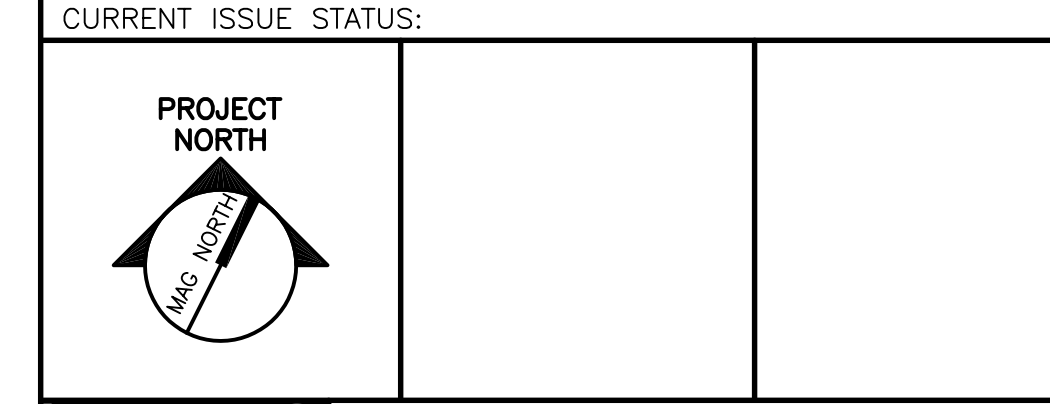

SMRT ARCHITECTURE ENGINEERING PLANNING
 SMRT
 144 Fore Street, P.O. Box 618
 Portland, Maine 04104
 tel. (207) 772-3846
 fax. (207) 772-1070

UNIMPROVIDENT HO-1
2nd FLOOR OFFICE RENOVATIONS
 PORTLAND, ME.

PHASE III POWER PLAN

| | | | |
|------------------|----------------|----------------|---------|
| SHEET TITLE: | 1/8"=1'-0" | DATE: | 1-28-04 |
| PROJECT MANAGER: | JLH | GRAPHIC SCALE: | 0" 1" |
| JOB CAP/DRAWN: | CEB/BGG | A/E OF RECORD: | DJT |
| SMRT CAD FILE: | EP103-03100-01 | SHEET No. | EP103 |
| PROJECT No. | 03100-01 | | |

A1 FLOOR PLAN

1/8"=1'-0"