


NOTE:
 1. SEE SHEET E-001 FOR LEGEND AND GENERAL NOTES.


KEYED NOTE:
 ① PROVIDE DOUBLE GANG BOX AND WHIP FOR MODULAR FURNITURE FEED. WIRING TO BE 2 #12 AWG & #12 GND.

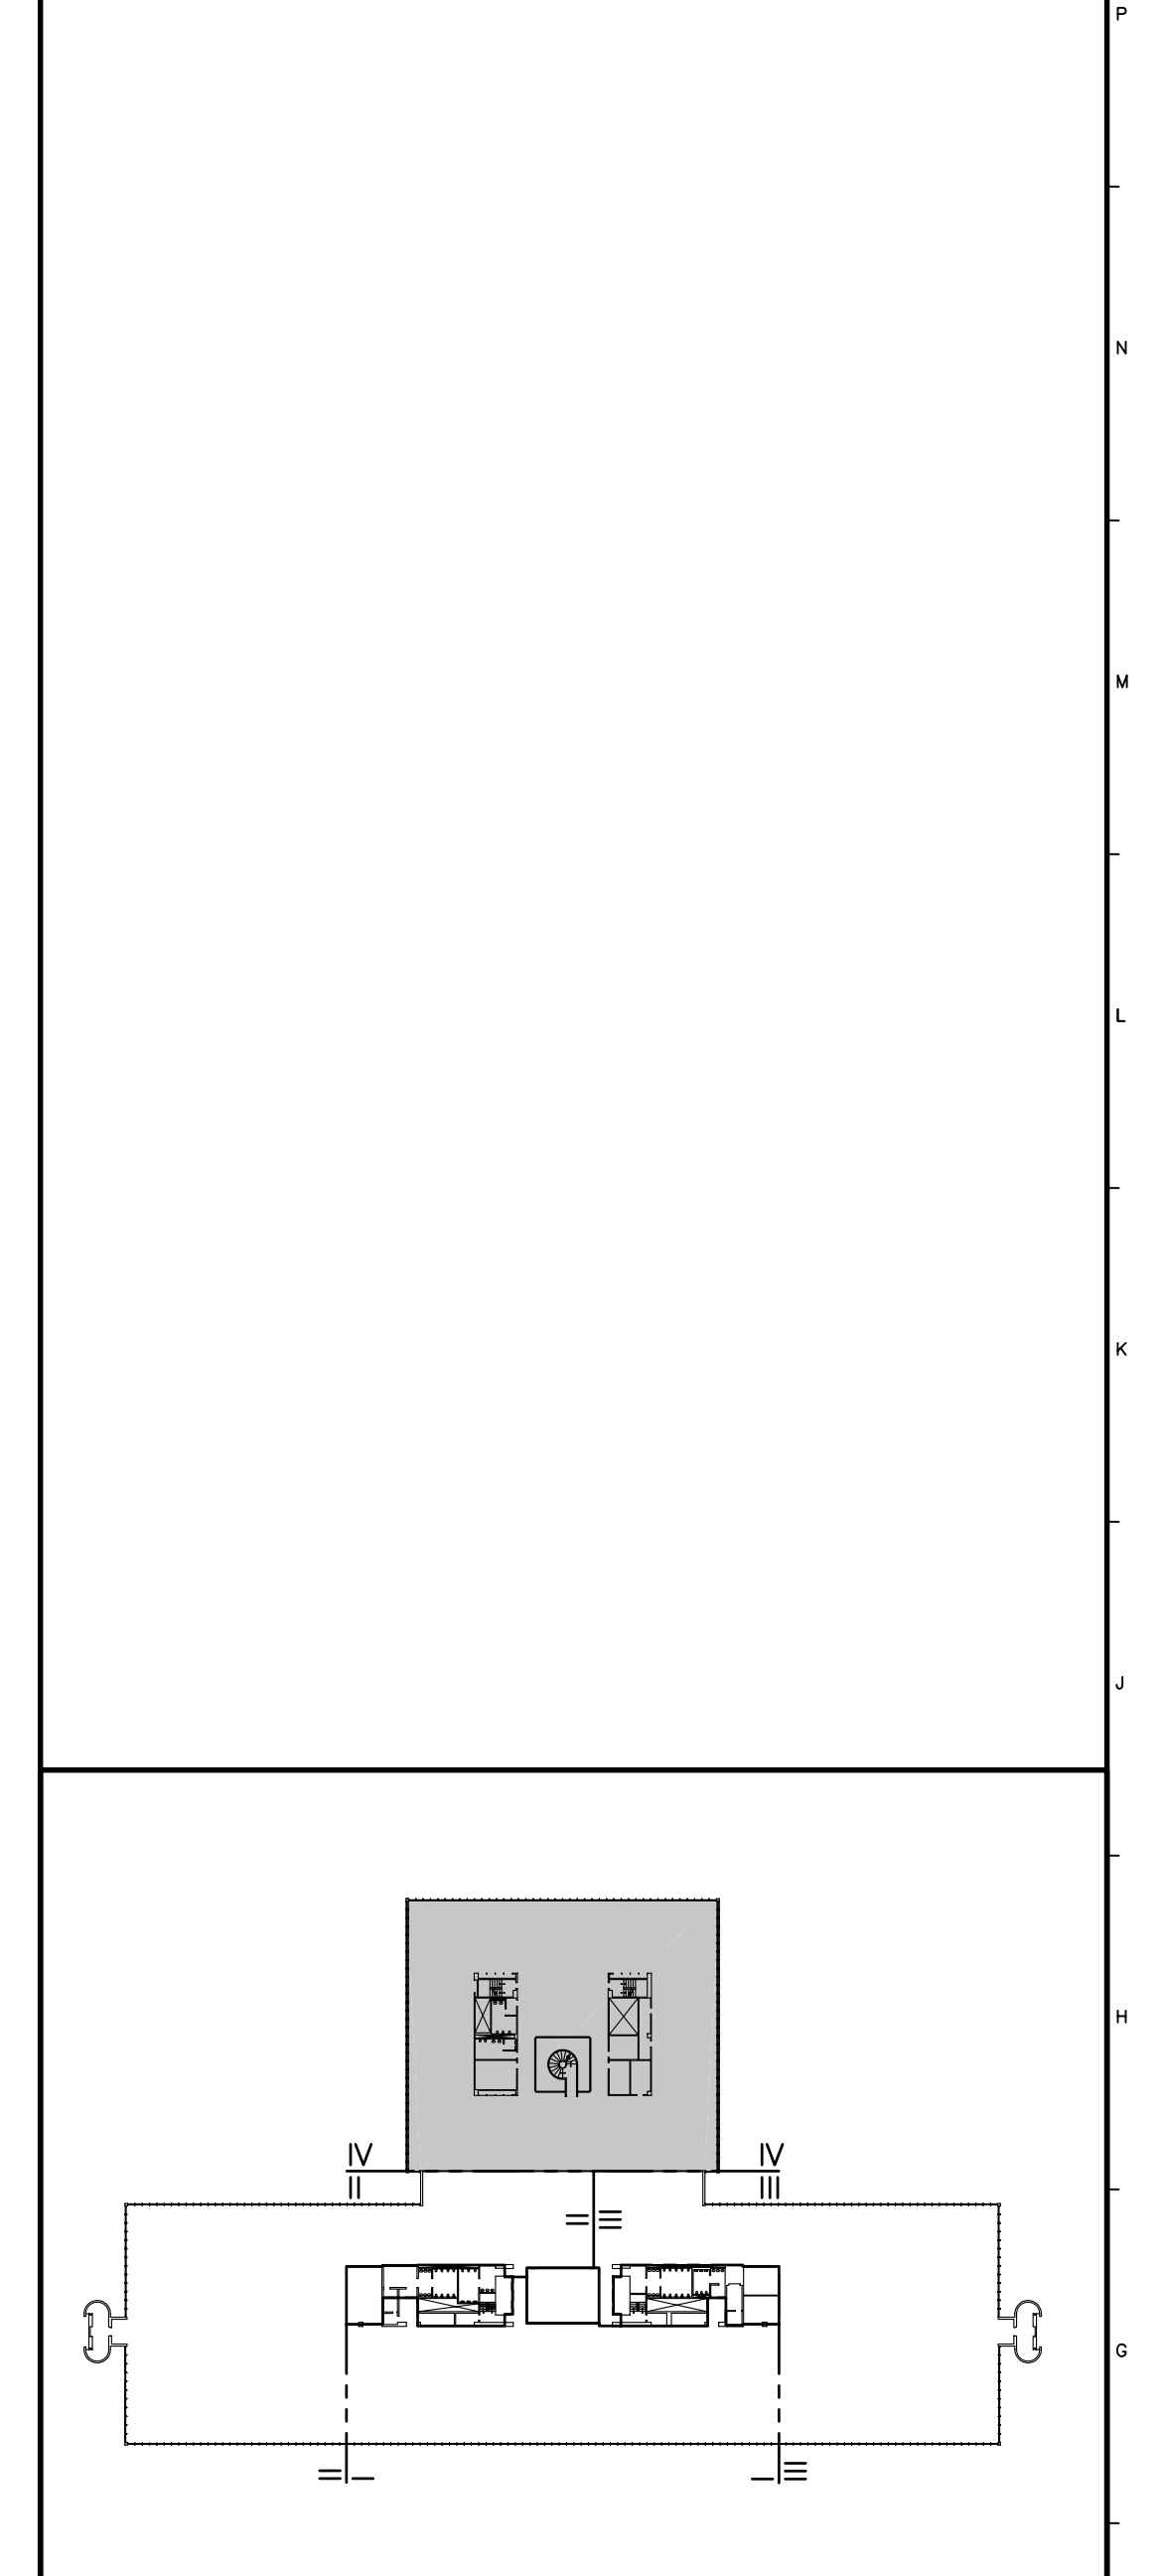

F18	KEY PLAN	
NOT TO SCALE		
0	ISSUED FOR CONSTRUCTION	1-28-04
REV.	DESCRIPTION	DATE

ISSUED FOR CONSTRUCTION
1-28-04

CURRENT ISSUE STATUS:

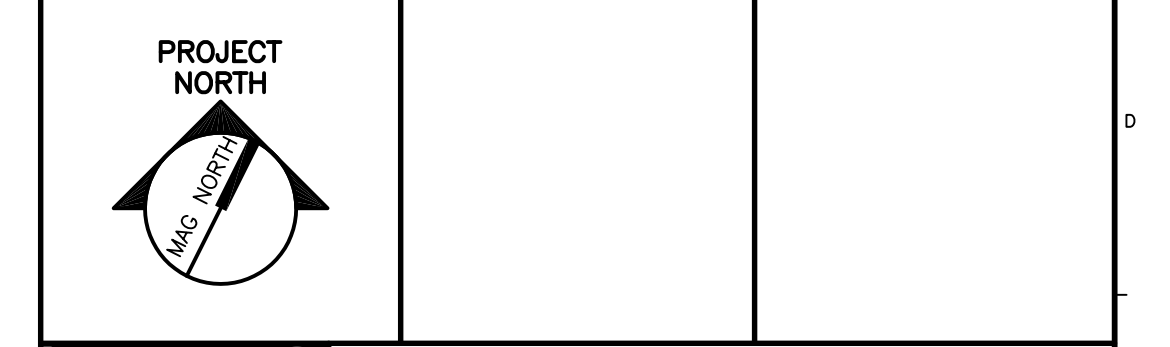

SMRT ARCHITECTURE ENGINEERING PLANNING
 SMRT
 144 Fore Street/P.O. Box 618
 Portland, Maine 04104
 tel. (207) 772-3846
 fax. (207) 772-1070

UNIMPROVIDENT HO-1
2nd FLOOR OFFICE RENOVATIONS
 PORTLAND, ME.

PHASE IV
POWER PLAN

SHEET TITLE:	1/8"=1'-0"	DATE:	1-28-04
PROJECT MANAGER:	JLH	GRAPHIC SCALE:	0" 1"
JOB CAP/DRAWN:	CEB/BGG	A/E OF RECORD:	DJT
SMRT CAD FILE:	EP104-03100-01	SHEET No.	EP104
PROJECT No.	03100-01		

A1 FLOOR PLAN
 1/8"=1'-0"