


- NOTE:**
- SEE SHEET E-001 FOR LEGEND AND GENERAL NOTES.
 - RELOCATE SMOKE DETECTORS AT LOCATIONS SHOWN. PROVIDE NEW WIRING FOR SMOKE DETECTORS. NEW WIRING TO BE UL LISTED FIRE ALARM MC CABLE. EXISTING PLENUM RATED CABLE TO BE REMOVED.
 - REWIRE EXISTING FIRE ALARM NOTIFICATION DEVICES SHOWN ON DRAWINGS. NEW WIRING TO BE UL LISTED FIRE ALARM MC CABLE.
 - TEST FIRE ALARM SYSTEM AFTER COMPLETION OF EACH PHASE TO VERIFY PROPER SYSTEM OPERATION.
 - RE-INSTALL WHITE NOISE SYSTEM SPEAKERS AT LOCATIONS SHOWN ON DRAWINGS.
 - FOR ALL VOICE/DATA OUTLETS SHOWN PROVIDE EMPTY OUTLET BOX AND 3/4" CONDUIT (W/PULL STRING) TO ABOVE AN ACCESSIBLE CEILING.

KEYED NOTE:

① RELOCATED FIRE ALARM NOTIFICATION DEVICE AND CLOCK. SEE SHEET ED102 FOR EXISTING LOCATION.

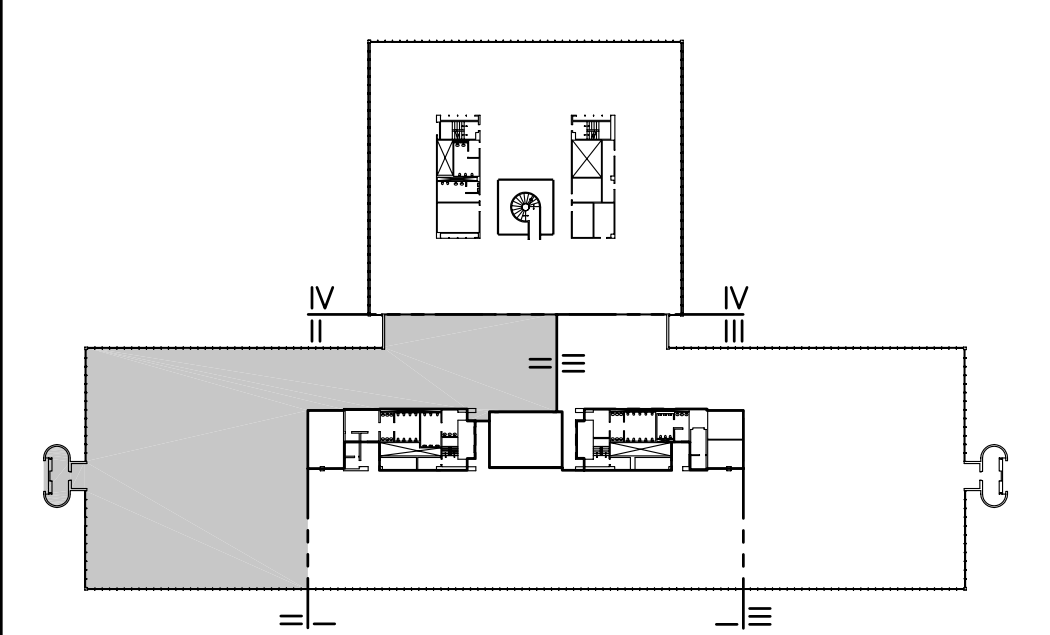

F18	KEY PLAN	
NOT TO SCALE		
0	ISSUED FOR CONSTRUCTION	1-28-04
REV.	DESCRIPTION	DATE

ISSUED FOR CONSTRUCTION
1-28-04

CURRENT ISSUE STATUS:

PROJECT NORTH

SM RT ARCHITECTURE ENGINEERING PLANNING
 SMRT
 144 Fore Street/P.O. Box 618
 Portland, Maine 04104
 tel. (207) 772-3846
 fax. (207) 772-1070

UNIMPROVIDENT HO-1
2nd FLOOR OFFICE RENOVATIONS
 PORTLAND, ME.

PHASE II
SYSTEMS PLAN

SHEET TITLE:	1-28-04
SCALE: 1/8"=1'-0"	DATE: 1-28-04
PROJECT MANAGER: JLH	GRAPHIC SCALE: 0" 1"
JOB CAP/DRAWN: CEB/BGG	
A/E OF RECORD: DJT	SHEET No.
SMRT CAD FILE: EY102-03100-01	EY102
PROJECT No. 03100-01	