


NOTE:


1. SEE SHEET E-001 FOR LEGEND AND GENERAL NOTES.
2. RELOCATE SMOKE DETECTORS AT LOCATIONS SHOWN. PROVIDE NEW WIRING FOR SMOKE DETECTORS. NEW WIRING TO BE UL LISTED FIRE ALARM MC CABLE. EXISTING PLENUM RATED CABLE TO BE REMOVED.
3. REWIRE EXISTING FIRE ALARM NOTIFICATION DEVICES SHOWN ON DRAWINGS. NEW WIRING TO BE UL LISTED FIRE ALARM MC CABLE.
4. TEST FIRE ALARM SYSTEM AFTER COMPLETION OF EACH PHASE TO VERIFY PROPER SYSTEM OPERATION.
5. RE-INSTALL WHITE NOISE SYSTEM SPEAKERS AT LOCATIONS SHOWN ON DRAWINGS.
6. FOR ALL VOICE/DATA OUTLETS SHOWN PROVIDE EMPTY OUTLET BOX AND 3/4" CONDUIT (W/PULL STRING) TO ABOVE AN ACCESSIBLE CEILING.

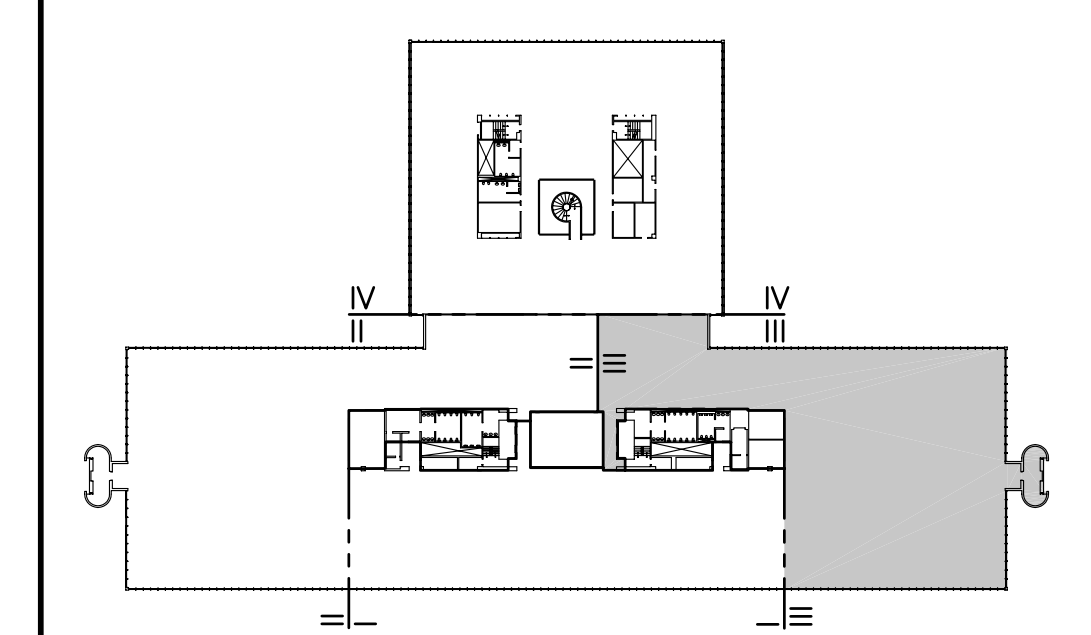

F18 KEY PLAN

NOT TO SCALE		
0	ISSUED FOR CONSTRUCTION	1-28-04
REV.	DESCRIPTION	DATE

ISSUED FOR CONSTRUCTION
1-28-04

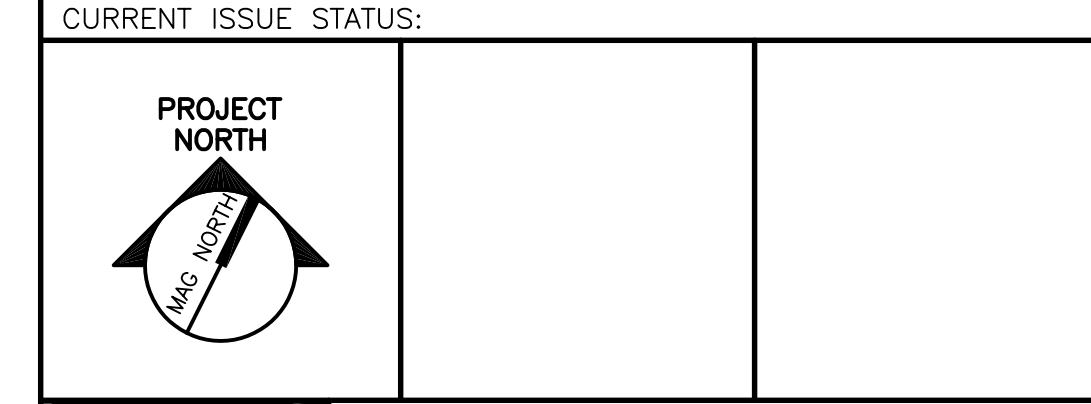

SMRT ARCHITECTURE ENGINEERING PLANNING
SMRT
144 Fore Street, P.O. Box 618
Portland, Maine 04104
tel. (207) 772-3846
fax. (207) 772-1070

UNUMPROVIDENT HO-1
2nd FLOOR OFFICE RENOVATIONS
PORTLAND, ME.

PHASE III SYSTEMS PLAN

SHEET TITLE:	1-28-04		
SCALE:	1/8"=1'-0"	DATE:	
PROJECT MANAGER:	JLH	GRAPHIC SCALE:	0" 1"
JOB CAP/DRAWN:	CEB/BGG		
A/E OF RECORD:	DJT	SHEET No.	
SMRT CAD FILE:	EY103-03100-01		
PROJECT No.	03100-01		

EY103

A1 FLOOR PLAN

1/8"=1'-0"