


**NOTE:**

1. SEE SHEET E-001 FOR LEGEND AND GENERAL NOTES.
2. RELOCATE SMOKE DETECTORS AT LOCATIONS SHOWN. PROVIDE NEW WIRING FOR SMOKE DETECTORS. NEW WIRING TO BE UL LISTED FIRE ALARM MC CABLE. EXISTING PLENUM RATED CABLE TO BE REMOVED.
3. REWIRE EXISTING FIRE ALARM NOTIFICATION DEVICES SHOWN ON DRAWINGS. NEW WIRING TO BE UL LISTED FIRE ALARM MC CABLE.
4. TEST FIRE ALARM SYSTEM AFTER COMPLETION OF EACH PHASE TO VERIFY PROPER SYSTEM OPERATION.
5. RE-INSTALL WHITE NOISE SYSTEM SPEAKERS AT LOCATIONS SHOWN ON DRAWINGS.
6. FOR ALL VOICE/DATA OUTLETS SHOWN PROVIDE EMPTY OUTLET BOX AND 3/4" CONDUIT (W/PULL STRING) TO ABOVE AN ACCESSIBLE CEILING.

**KEYED NOTE:**

- ① RELOCATED FIRE ALARM NOTIFICATION DEVICE AND CLOCK. SEE SHEET ED104 FOR EXISTING LOCATION.

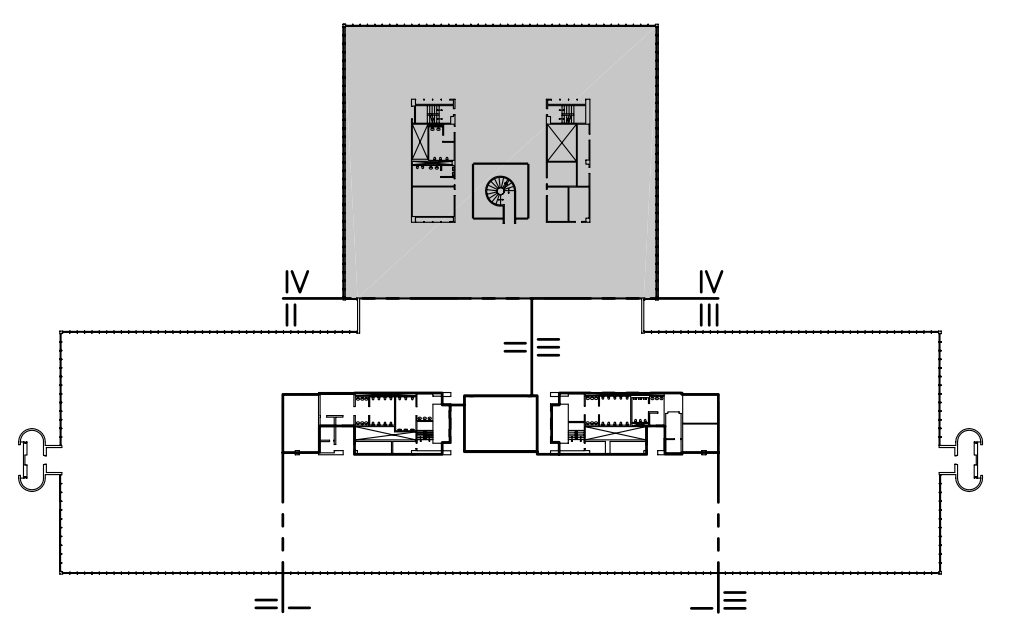

**F18 KEY PLAN**

NOT TO SCALE		
0	ISSUED FOR CONSTRUCTION	1-28-04
REV.	DESCRIPTION	DATE

**ISSUED FOR CONSTRUCTION 1-28-04**

CURRENT ISSUE STATUS:


**ARCHITECTURE ENGINEERING PLANNING**

SMRT  
144 Fore Street/P.O. Box 618  
Portland, Maine 04104  
tel. (207) 772-3846  
fax. (207) 772-1070

**UNIMPROVIDENT HO-1  
2nd FLOOR OFFICE RENOVATIONS  
PORTLAND, ME.**

**PHASE IV  
SYSTEMS PLAN**

SHEET TITLE:		DATE:	1-28-04
SCALE:	1/8"=1'-0"	DATE:	1-28-04
PROJECT MANAGER:	JLH	GRAPHIC SCALE:	0" 1"
JOB CAP/DRAWN:	CEB/BGG	A/E OF RECORD:	DJT
SMRT CAD FILE:	EY104-03100-01	SHEET No.	
PROJECT No.	03100-01	<b>EY104</b>	

**A1 FLOOR PLAN**

1/8"=1'-0"