


**NOTES:**

1. SEE SHEET M-001 FOR LEGEND AND ABBREVIATIONS.
2. ALL EXISTING DUCT HANGERS SHALL REMAIN FOR FUTURE USE.

**KEYED NOTE:**


- ① CONNECT EXISTING DUCTWORK TO NEW VAV BOX.
- ② CAP AND SEAL EXISTING DUCTWORK AIRTIGHT.
- ③ HALSEY TAYLOR OVL-11 SER-0 BI-LEVEL ADA BARRIER FREE WATER COOLER. STAINLESS STEEL FINISH.

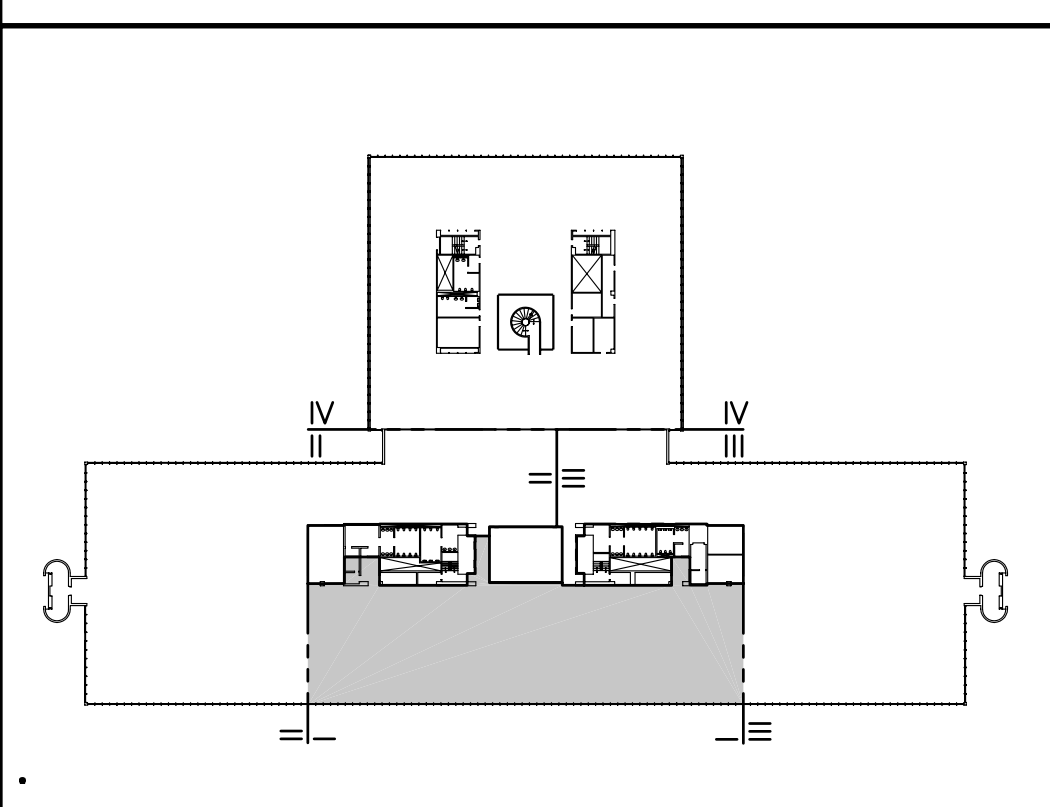

**F18 KEY PLAN**

NOT TO SCALE	
0	ISSUED FOR CONSTRUCTION
REV.	DESCRIPTION
	DATE

**ISSUED FOR CONSTRUCTION**  
**1-28-04**

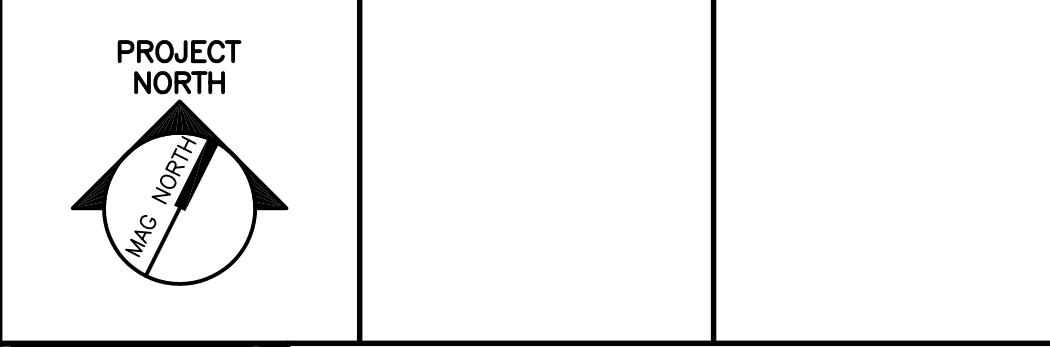

**SM RT** ARCHITECTURE ENGINEERING PLANNING  
 SMRT  
 144 Fore Street/P.O. Box 618  
 Portland, Maine 04104  
 tel. (207) 773-3846  
 fax. (207) 772-1070

**UNIMPROVIDENT HO-1**  
**2nd FLOOR OFFICE RENOVATIONS**  
 PORTLAND, ME.

**PHASE I**  
**HVAC PLAN**

SHEET TITLE:	1-28-04
SCALE: 1/8"=1'-0"	DATE:
PROJECT MANAGER: JLH	GRAPHIC SCALE: 0" 1"
JOB CAP/DRAWN: CEB/CAH	
A/E OF RECORD: LPA	SHEET No.
SMRT CAD FILE: M-101-03100-0	<b>M-101</b>
PROJECT No. 03100-01	

**A1 FLOOR PLAN**

1/8"=1'-0"