



3'-6" TYPICAL  
 3'-6" TYPICAL  
 6" Ø BOLLARD x 42" HIGH x 5'-0" BELOW FINISHED GRADE  
 CONDENSING UNIT CU-1  
 4'-0" W x 5'-0" L 8" CONCRETE PAD W/ #4 @ 12" O.C. E.W.  
 CLEARANCE LINE

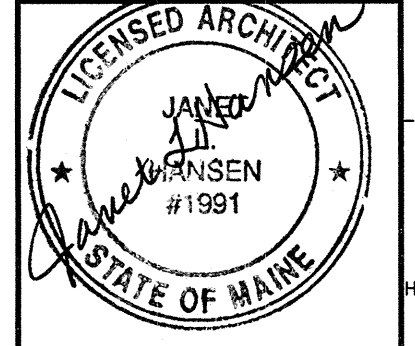


ARCHITECTURE ENGINEERING PLANNING  
 SMRT  
 144 Fore Street/P.O. Box 618  
 Portland, Maine 04104  
 tel. (207) 772-3846  
 fax. (207) 772-1070

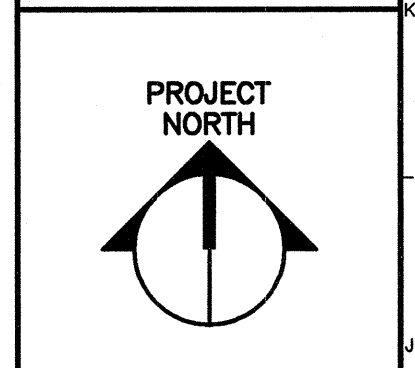

PROJECT TITLE:  
**UNUMPROVIDENT CORPORATION  
 HO-1 BEACON PHASE II**  
 PORTLAND, MAINE  
 CURRENT ISSUE STATUS:  
**ISSUED FOR CONSTRUCTION  
 8-16-2004**

REV	DESCRIPTION	DATE
0	ISSUED FOR CONSTRUCTION	8-16-04

GRAPHIC SCALE:  
 0" 1"  
 SCALE: 1/8"=1'-0"  
 PROJECT MANAGER: JLH  
 JC/DRAWN BY: CEB  
 A/E OF RECORD: JLH  
 CAD FILE: AE100-04054  
 PROJECT NO: 04054-00  
 DATE:  
 SHEET TITLE:

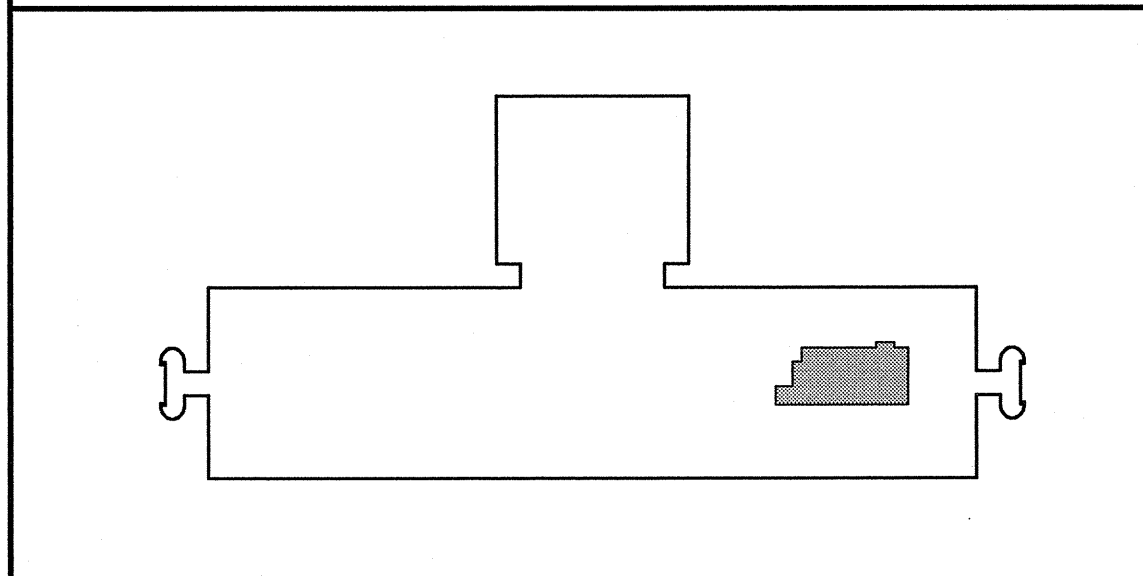

PARTIAL GROUND FLOOR PLAN  
 CU-1 LOCATION

**A1 PARTIAL GROUND FLOOR PLAN - A/C CONDENSING UNIT CU-1 LOCATION**  
 1/8"=1'-0" \*

**A14 KEYPLAN**  
 NOT TO SCALE

SHEET No.  
**AE100**  
© copyright 2004 SMRT INC.