

PROJECT TITLE:  
**UNIMPROVIDENT CORPORATION  
HO-1 BEACON PHASE II**  
PORTLAND, MAINE



CURRENT ISSUE STATUS:  
**ISSUED FOR CONSTRUCTION  
8-16-2004**

REV	DESCRIPTION	DATE
0	ISSUED FOR CONSTRUCTION	8-16-04

GRAPHIC SCALE:  
0" 1"  
SCALE: 1/4"=1'-0"  
PROJECT MANAGER: JLH  
JC/DRAWN BY: CEB  
A/E OF RECORD: JLH  
CAD FILE: AE102-04054  
PROJECT NO: 04054-00  
DATE: 04054-00  
SHEET TITLE:

**REFLECTED  
CEILING PLAN  
SERVERY**

SHEET No.  
**AE102**

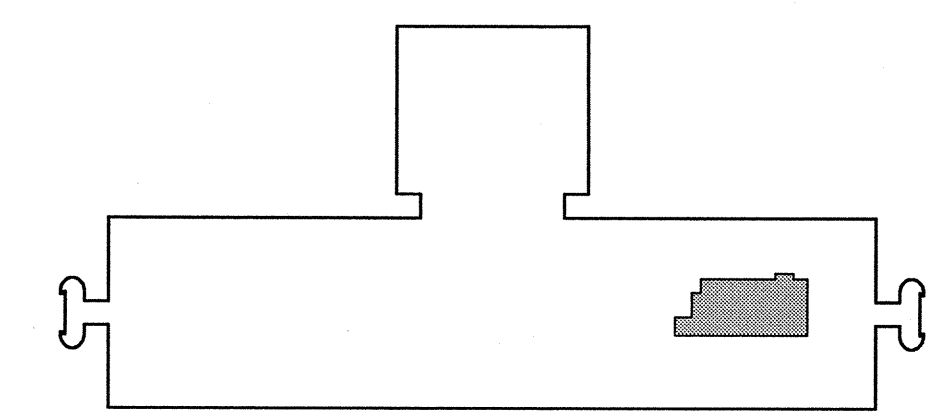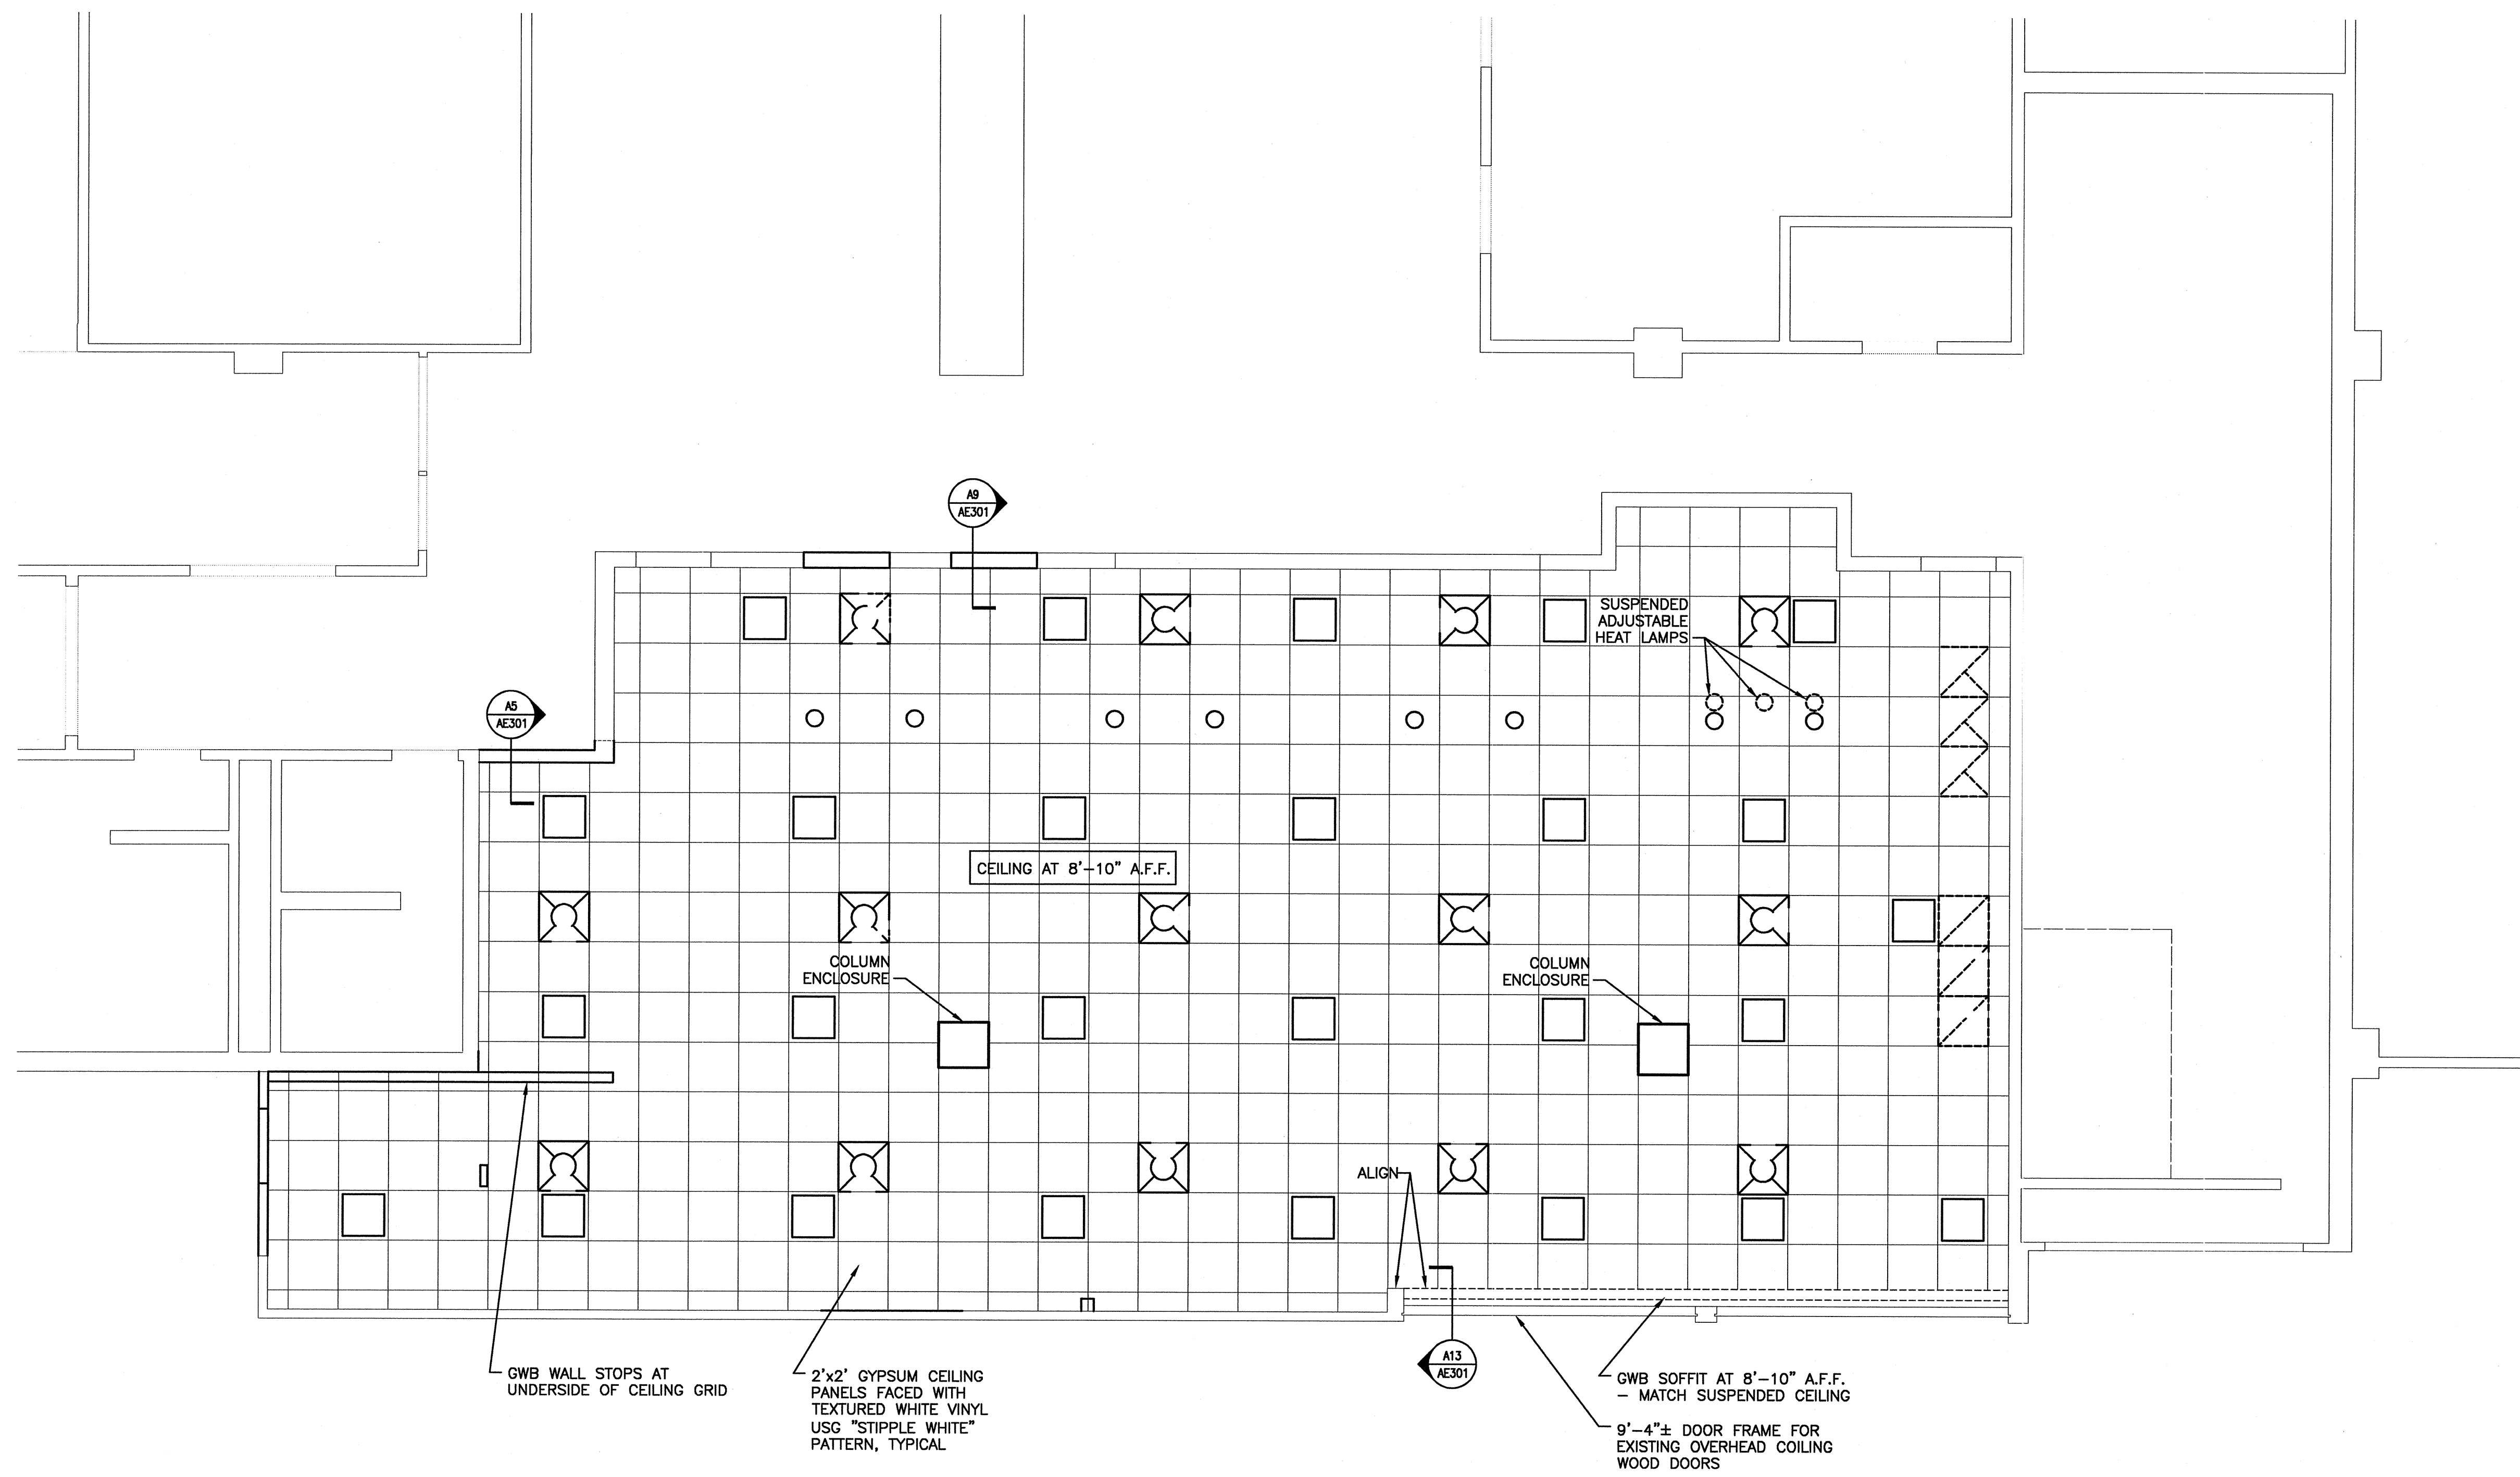

**A1 REFLECTED CEILING PLAN**

1/4"=1'-0"

**A14 KEYPLAN**

NOT TO SCALE