



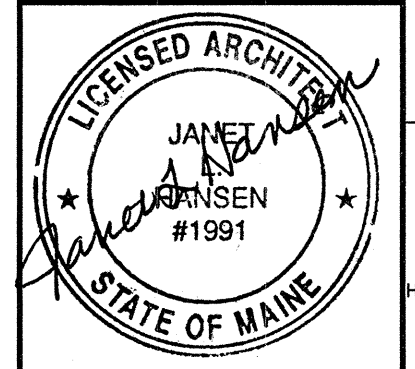

ARCHITECTURE ENGINEERING PLANNING  
 SMT RPT  
 144 Fore Street/P.O. Box 618  
 Portland, Maine 04104  
 tel. (207) 772-3846  
 fax. (207) 772-1070


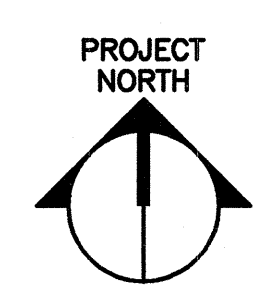


PROJECT TITLE: UNIMPROVIDENT CORPORATION  
 HO-1 BEACON PHASE II  
 PORTLAND, MAINE  
 CURRENT ISSUE STATUS: ISSUED FOR CONSTRUCTION  
 8-16-2004

REV	DESCRIPTION	DATE
0	ISSUED FOR CONSTRUCTION	8-16-04

GRAPHIC SCALE:  
 0" 1"  
 SCALE: 1/4"=1'-0"  
 PROJECT MANAGER: JLH  
 JC/DRAWN BY: CEB  
 A/E OF RECORD: JLH  
 CAD FILE: AE103-04054  
 PROJECT NO: 04054-00  
 DATE:  
 SHEET TITLE:

REFLECTED CEILING PLAN  
 I-ROOMS  
 SHEET No.  
 AE103

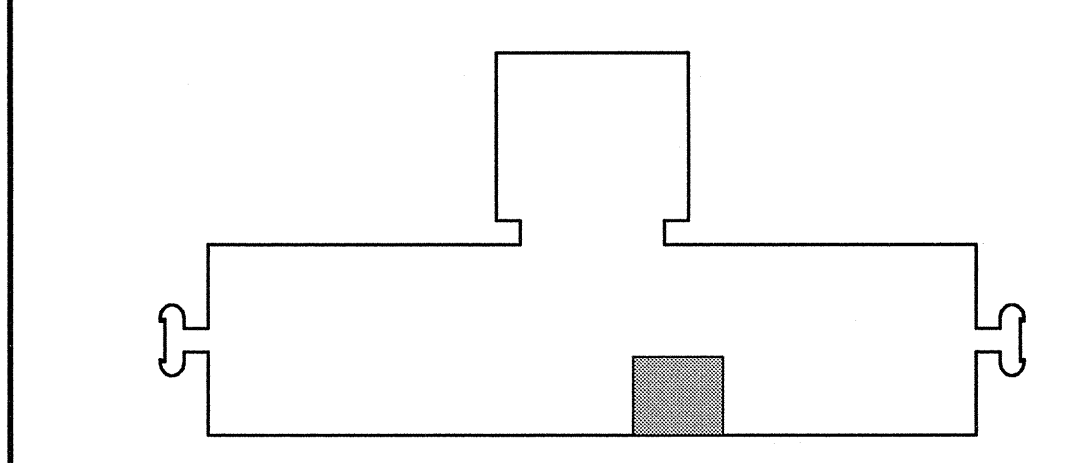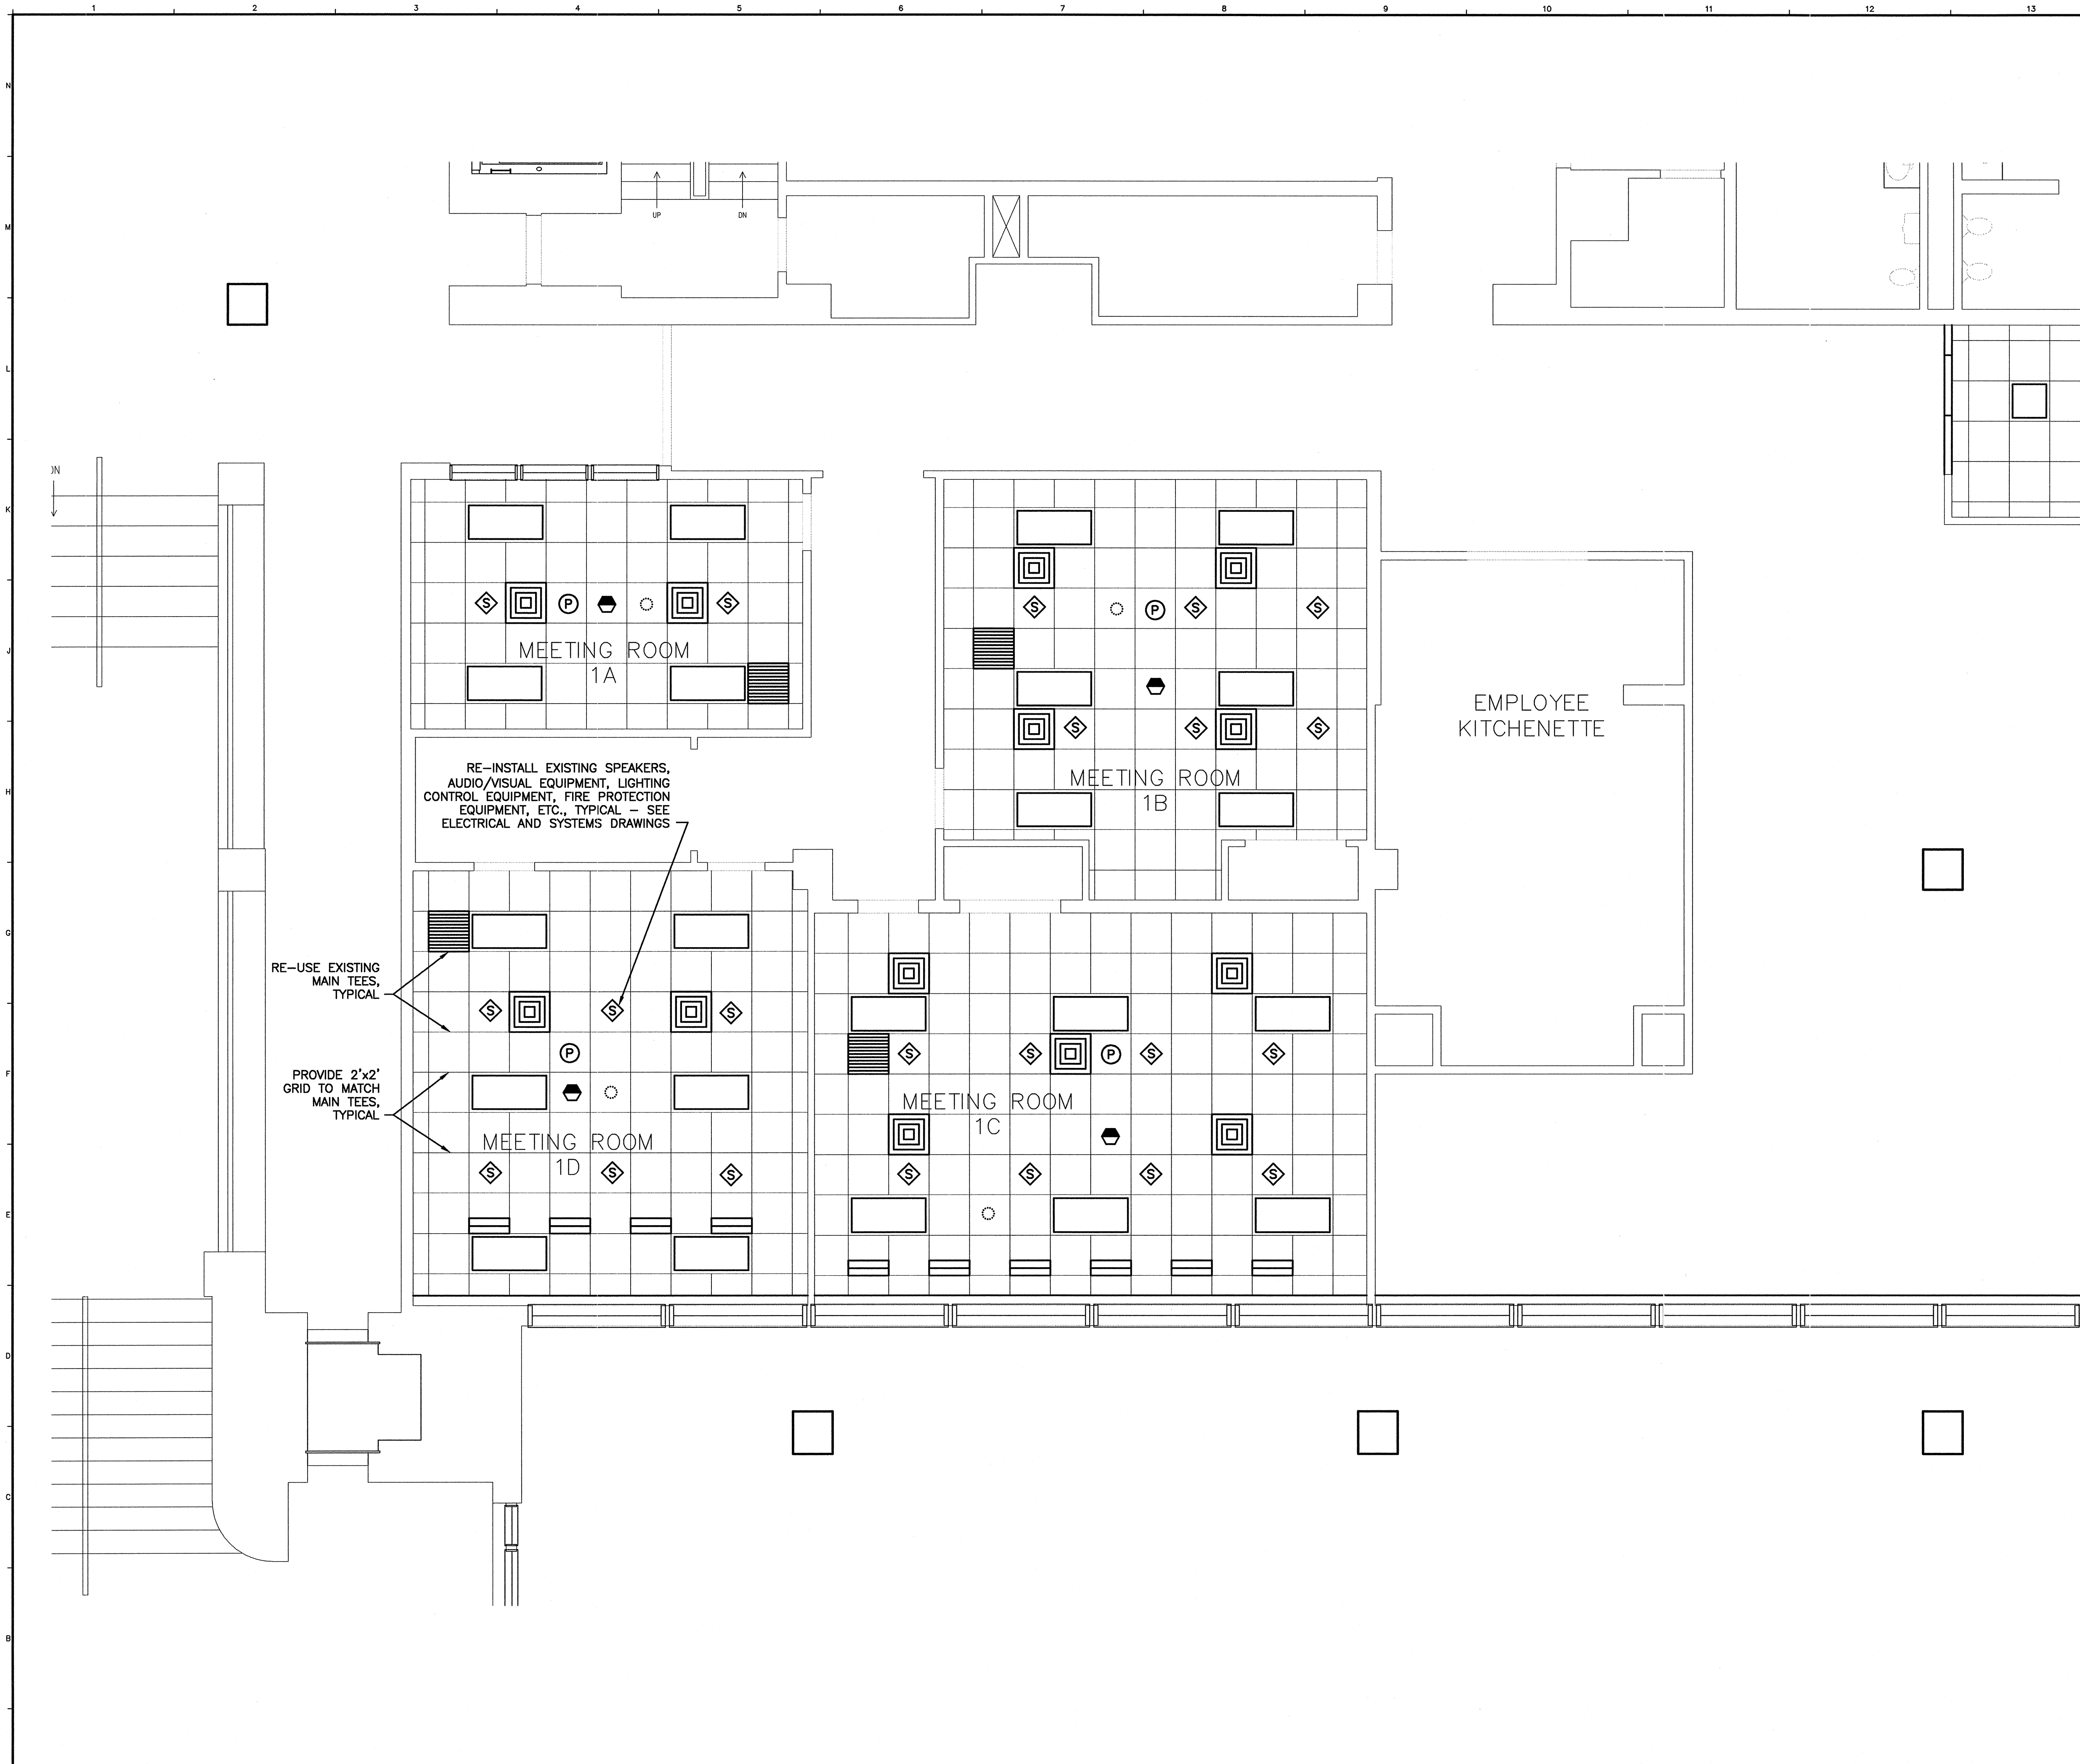

A1	I-ROOMS REFLECTED CEILING PLAN (ALTERNATE BID)
1/4"=1'-0"	*

A14	KEYPLAN
NOT TO SCALE	