


**NOTE:**  
 1. SEE SHEET E-001 FOR LEGEND AND GENERAL NOTES.  
 2. USE EXISTING SPARE CIRCUIT BREAKERS IN PANELBOARD HL1E FOR LIGHTS SHOWN ON DRAWINGS.



ARCHITECTURE ENGINEERING PLANNING  
 SMART  
 144 Fore Street/P.O. Box 618  
 Portland, Maine 04104  
 tel. (207) 772-3846  
 fax. (207) 772-1070

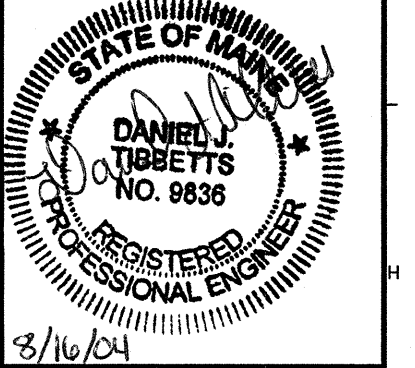


PROJECT TITLE:  
**UNIMPROVIDENT CORPORATION  
 HO-1 BEACON PHASE II**  
 PORTLAND, MAINE  
 CURRENT ISSUE STATUS:  
**ISSUED FOR CONSTRUCTION  
 8-16-2004**

REV	DESCRIPTION	DATE
0	ISSUED FOR CONSTRUCTION	8-16-04

GRAPHIC SCALE:  

 SCALE: 1/4"=1'-0"  
 PROJECT MANAGER: JLH  
 JC/DRAWN BY: BHG  
 A/E OF RECORD: DJT  
 CAD FILE: EL102-04054  
 PROJECT NO: 04054-00  
 DATE:  
 SHEET TITLE:

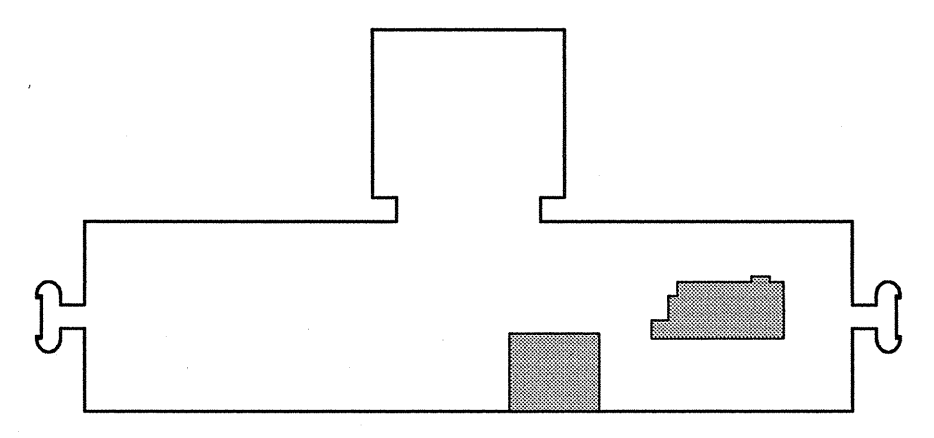

**LIGHTING PLAN  
 I-ROOMS**

**A1 I-ROOMS LIGHTING PLAN**  
 1/4"=1'-0" \*

**A14 KEYPLAN**  
 NOT TO SCALE

SHEET No.  
**EL102**