





NOTES:
 1. SEE SHEET E-001 FOR LEGEND AND GENERAL NOTES.
 2. EXTEND WIRING FROM EXISTING KITCHEN PANELS TO PANELS SHOWN. SEE SHEET ED101 FOR NOTES.

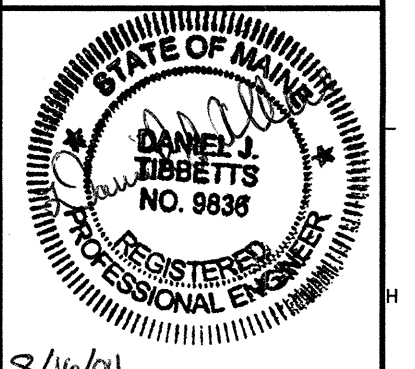

ARCHITECTURE ENGINEERING PLANNING
 SMART
 144 Fore Street/P.O. Box 618
 Portland, Maine 04104
 tel. (207) 772-3846
 fax. (207) 772-1070

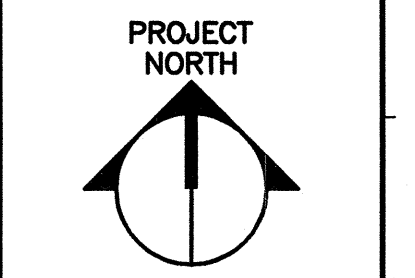


8/16/04
 PROJECT TITLE:
 UNIMPROVIDENT CORPORATION
 HO-1 BEACON PHASE II
 PORTLAND, MAINE
 CURRENT ISSUE STATUS:
 ISSUED FOR CONSTRUCTION
 8-16-2004

REV.	DESCRIPTION	DATE
0	ISSUED FOR CONSTRUCTION	8-16-04

GRAPHIC SCALE:

 SCALE: 1/4"=1'-0"
 PROJECT MANAGER: JLH
 JC/DRAWN BY: BHG
 A/E OF RECORD: DJT
 CAD FILE: EP102-04054
 PROJECT NO: 04054-00
 DATE:
 SHEET TITLE:

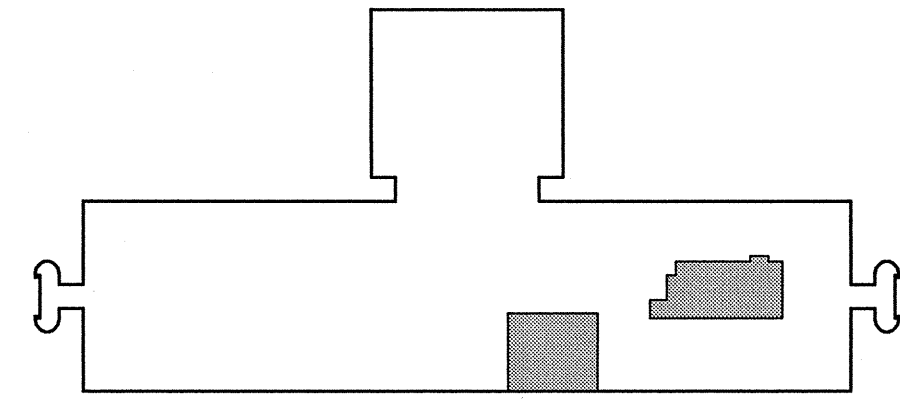

POWER PLAN
 I-ROOMS

A1	I-ROOMS LIGHTING PLAN	A14	KEYPLAN
1/4"=1'-0"	*	NOT TO SCALE	

SHEET No.
EP102
© COPYRIGHT 2004 SMART INC.