



**NOTES:**

- SEE SHEET E-001 FOR LEGEND AND GENERAL NOTES.
- EXTEND EXISTING FIRE ALARM SYSTEM TO NEW DEVICES SHOWN. PROVIDE ALL CONDUIT, BOXES, WIRING, EQUIPMENT AND PROGRAMMING FOR A COMPLETE AND OPERABLE SYSTEM. ALL FIRE ALARM WIRING SHALL BE UL LISTED FIRE ALARM MC CABLE.

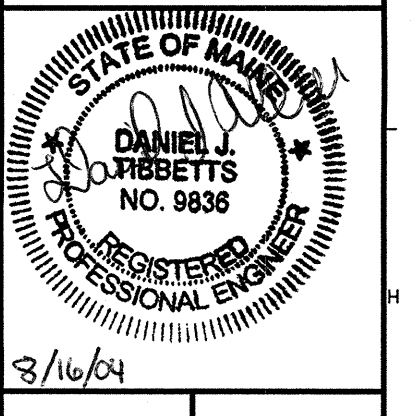

ARCHITECTURE ENGINEERING PLANNING  
 SMART  
 144 Fore Street/P.O. Box 618  
 Portland, Maine 04104  
 tel. (207) 772-3846  
 fax. (207) 772-1090

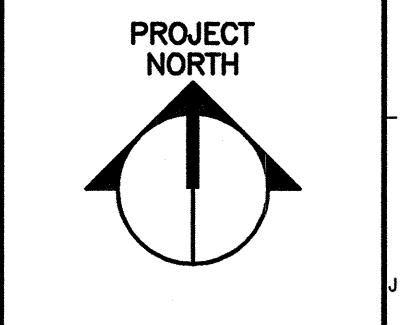


PROJECT TITLE:  
**UNIMPROVIDENT CORPORATION  
 HO-1 BEACON PHASE II**  
 PORTLAND, MAINE

CURRENT ISSUE STATUS:  
**ISSUED FOR CONSTRUCTION  
 8-16-2004**

REV	DESCRIPTION	DATE
0	ISSUED FOR CONSTRUCTION	8-16-04

GRAPHIC SCALE:  
  
 SCALE: 1/4"=1'-0"  
 PROJECT MANAGER: JLH  
 JC/DRAWN BY: BHG  
 A/E OF RECORD: DJT  
 CAD FILE: EY101-04054  
 PROJECT NO: 04054-00  
 DATE:  
 SHEET TITLE:

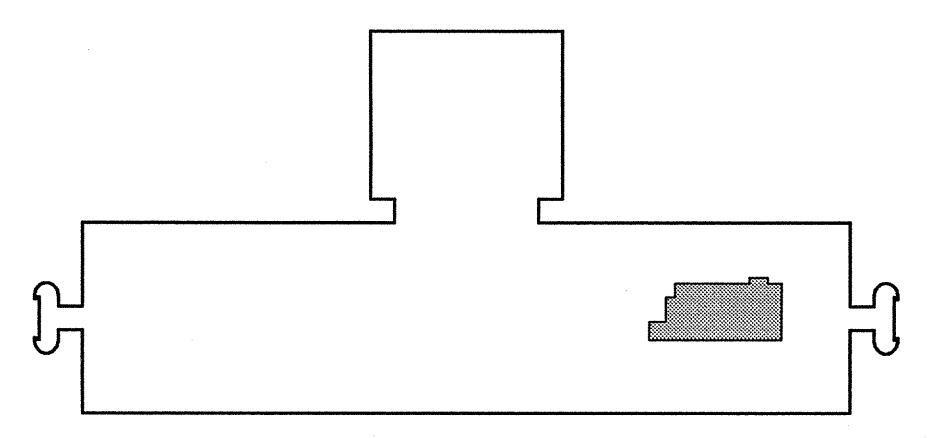

**A1 FLOOR PLAN**

1/4"=1'-0" \*

**A14 KEYPLAN**

NOT TO SCALE

**FLOOR PLAN SERVERY**

SHEET No.  
**EY101**