

# UNUMPROVIDENT CORPORATION

## HO I

# THE BEACON RENOVATIONS, PHASE II



## I-ROOMS CEILING RENOVATIONS

2211 Congress Street  
Portland, Maine

ISSUED FOR CONSTRUCTION  
8-16-2004




ARCHITECTURE ENGINEERING PLANNING  
SMRT  
144 Fore Street/P.O. Box 618  
Portland, Maine 04104  
tel. (207) 772-3846  
fax. (207) 772-1070

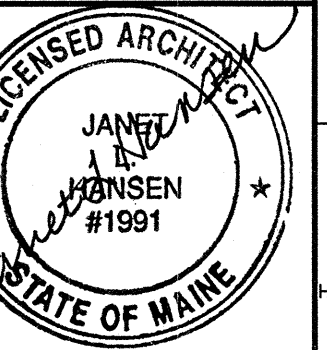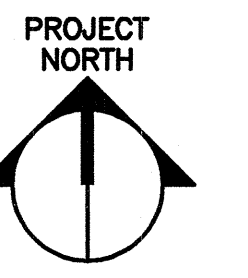

PROJECT TITLE:  
UNUMPROVIDENT CORPORATION  
HO-I BEACON PHASE II  
PORTLAND, MAINE  
CURRENT ISSUE STATUS:  
ISSUED FOR CONSTRUCTION  
8-16-2004

KEY PLAN

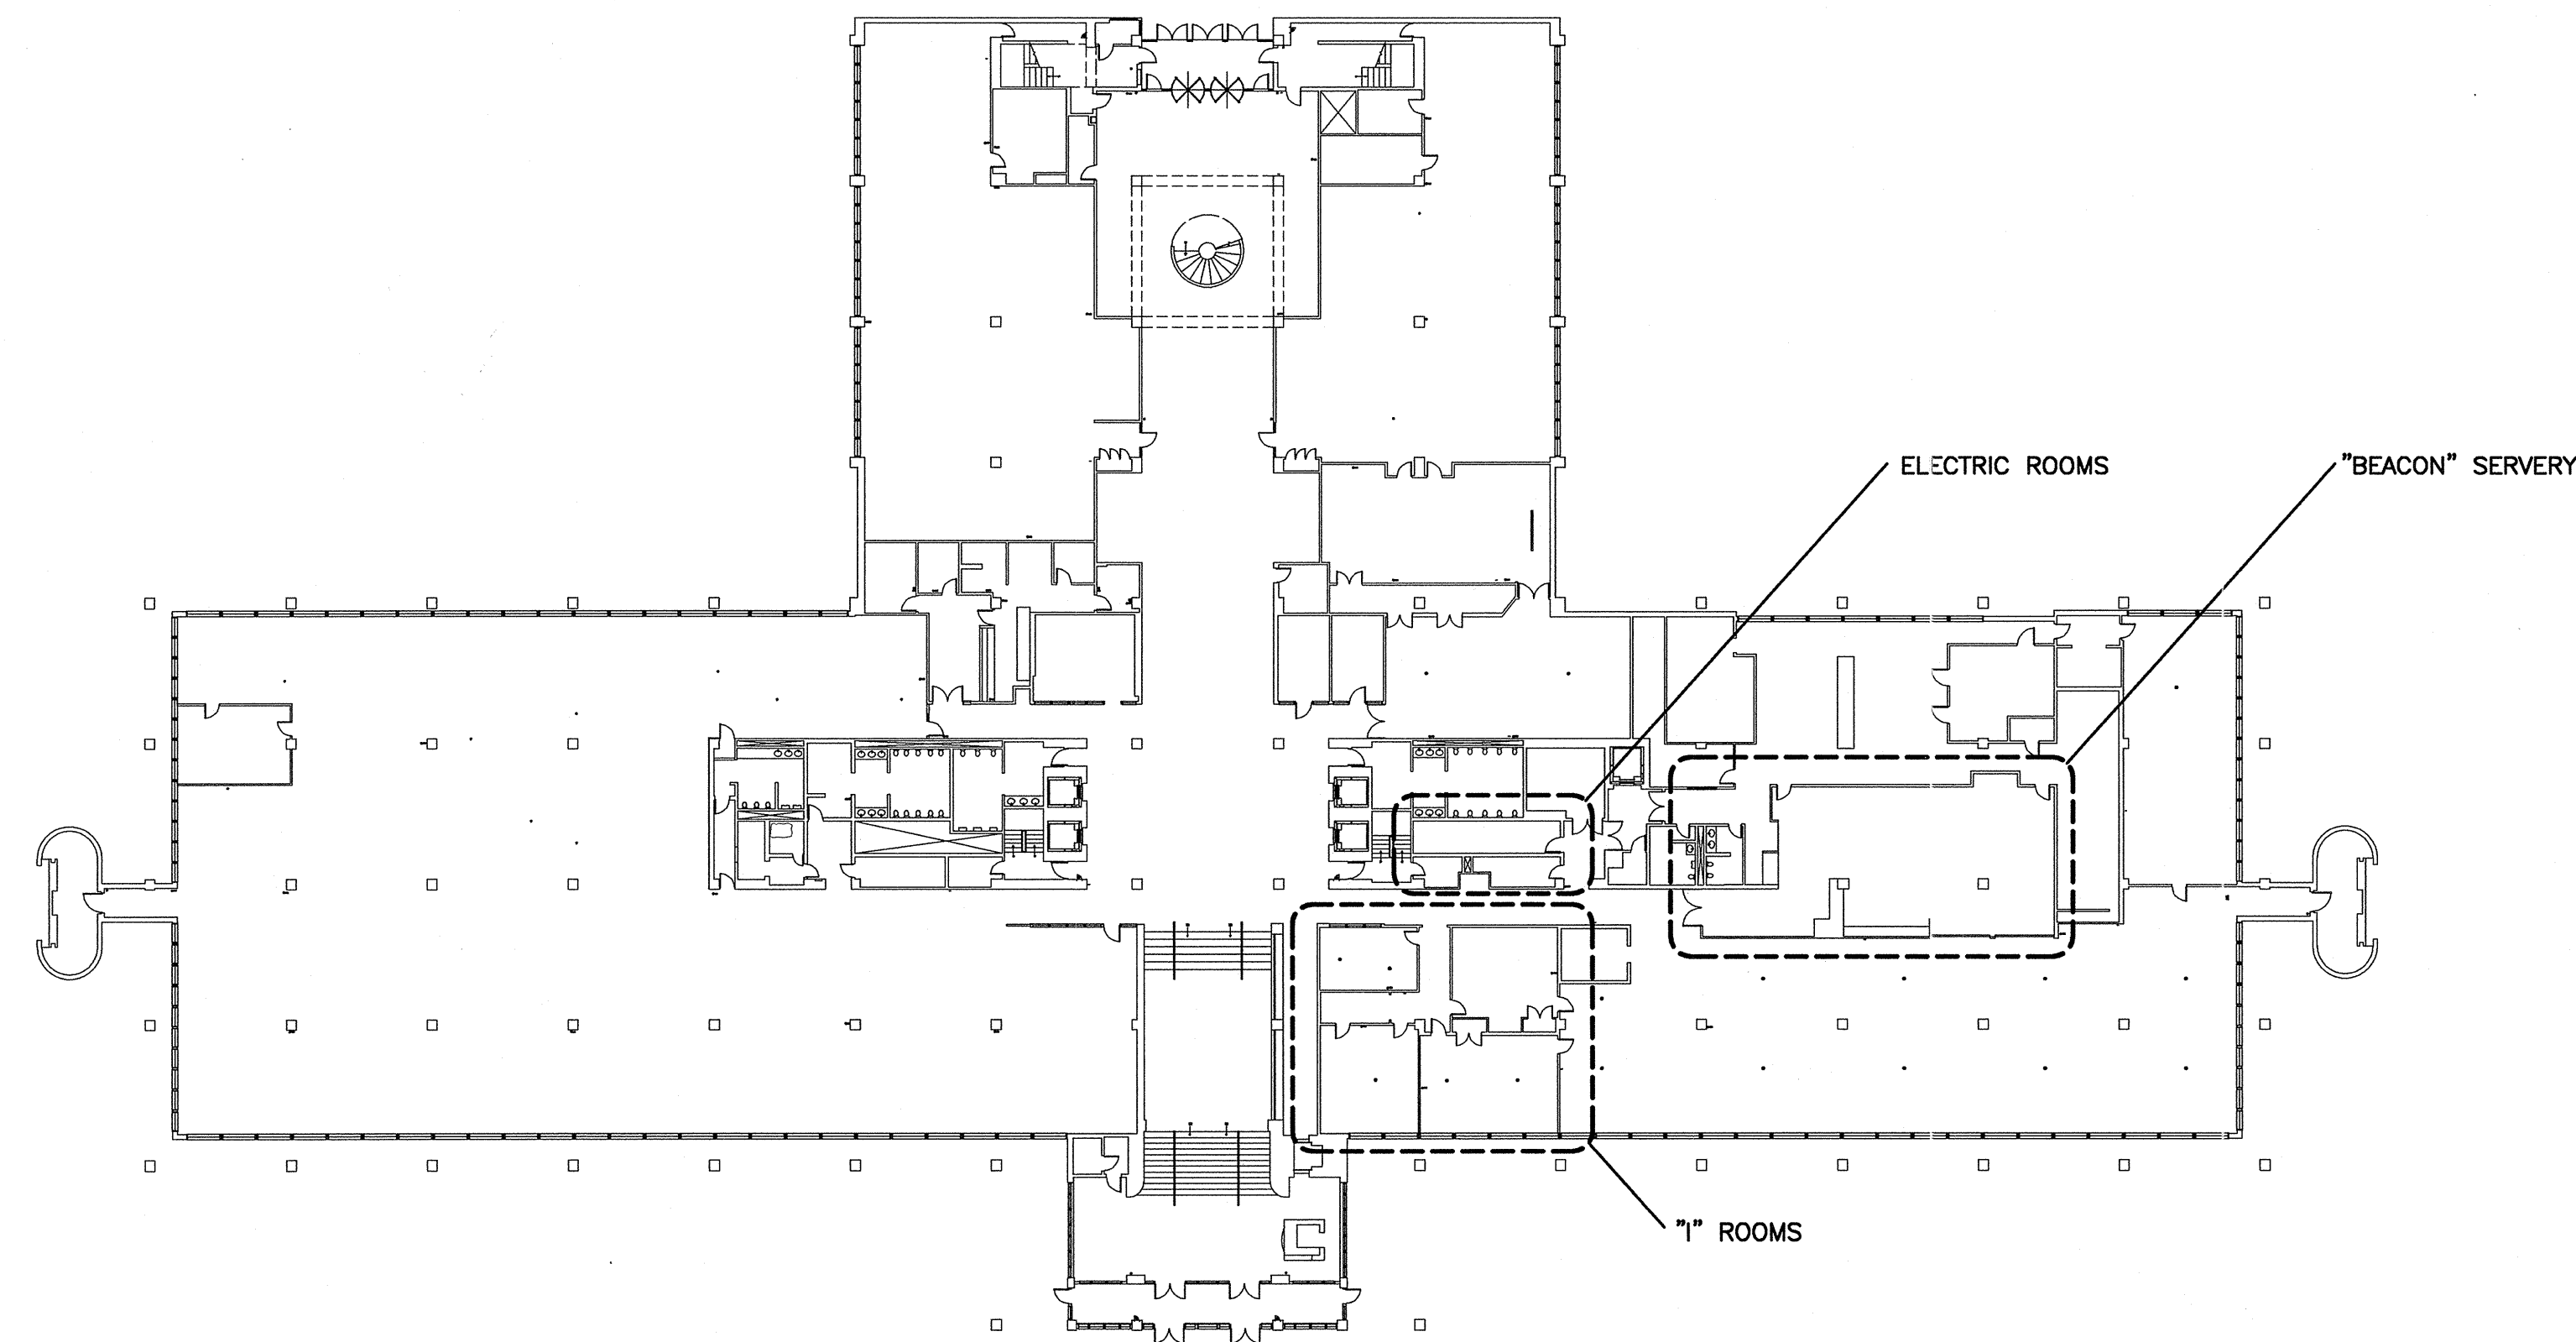

DRAWING LIST

- GENERAL**
- G1001 TITLE SHEET
- ARCHITECTURAL**
- AD101 DEMOLITION FLOOR PLANS SERVERY
  - AD102 DEMOLITION CEILING PLAN I-ROOMS
  - AE100 PARTIAL GROUND FLOOR PLAN CU-1 LOCATION
  - AE101 FLOOR PLANS SERVERY
  - AE102 REFLECTED CEILING PLAN SERVERY
  - AE103 REFLECTED CEILING PLAN I-ROOMS
  - AE201 INTERIOR ELEVATIONS SERVERY
  - AE301 WALL SECTIONS SERVERY
  - AE501 SECTIONS & DETAILS SERVERY
- MECHANICAL**
- M-001 LEGEND AND ABBREVIATIONS SPECIFICATIONS
  - M-002 SPECIFICATIONS
  - M-101 FIRST FLOOR HVAC PLAN
  - M-401 PART PLAN
  - M-501 DETAILS
  - M-601 SCHEDULES
- PLUMBING**
- P-101 SERVERY PLUMBING PLANS
  - PL501 DETAILS, PART PLANS AND SCHEDULES
- ELECTRICAL**
- E-001 LEGEND & GENERAL NOTES
  - E-601 PANEL SCHEDULE
  - ED101 DEMOLITION FLOOR PLAN SERVERY
  - ED102 DEMOLITION PLAN I-ROOMS
  - EP101 POWER PLAN SERVERY
  - EP102 POWER PLAN I-ROOMS
  - EL101 LIGHTING PLAN AND FIXTURE SCHEDULE
  - EL102 LIGHTING PLAN I-ROOMS
  - EY101 FLOOR PLAN SERVERY
  - EY102 SYSTEMS PLAN I-ROOMS

SYMBOL LEGEND

- DETAIL
- CIRCLE NOTE
- PARTITION TAG
- DOOR TAG
- MAIN LOBBY ROOM NAME ROOM NUMBER
- SEALANT AND BACKER ROD

REV	DESCRIPTION	DATE
0	ISSUED FOR CONSTRUCTION	8-16-04

GRAPHIC SCALE:  
0" 1"

SCALE: AS NOTED  
PROJECT MANAGER: JLH  
JC/DRAWN BY: RJL/TCM  
A/E OF RECORD: JLH  
CAD FILE: G1001-04054  
PROJECT NO: 04054-00  
DATE:

SHEET TITLE:  
TITLE SHEET

SHEET No.  
G1001