


PLUMBING FIXTURE SCHEDULE						
TAG	DESCRIPTION	FIXTURE	FAUCET/DRAIN	TRIM	SUPPORT	NOTES
SK-1	SERVING COUNTER SINK	RELOCATED SS SINK	CHICAGO #201-AH8CP FAUCET WITH E12 AERATOR, 369 LEVER HANDLES	McGUIRE LOOSE KEY ANGLE STOPS AND RISERS--CHROME PLATED	-	①
SK-2	HAND SINK - ADA, WALL MOUNTED	ADVANCE TABCO #7-PS-25 304SS	ADVANCE TABCO 6" O.C. CHROME PLATED DECK MOUNTED GOOSENECK FAUCET, WRIST BLADE HANDLES, LIQUID SOAP DISPENSER, SS STRAINER PLATE	McGUIRE LOOSE KEY ANGLE STOPS AND RISERS--CHROME PLATED	-	①②


NOTES: ① FAUCET TO BE ADA COMPLIANT. ② INSULATE EXPOSED PIPING - TRUEBRO LAV-GUARD.

DRAIN SCHEDULE				
TAG	APPLICATION	TYPICAL UNIT MFG & MODEL NO.	DESCRIPTION	NOTES
FD-A	KITCHEN INDIRECT WASTE	ZURN Z-1910-3	8" x 8" FLOOR SINK, CAST IRON BODY, PORCELAIN ENAMEL COATING, DOME STRAINER 3/4 GRATE.	


NOTES:

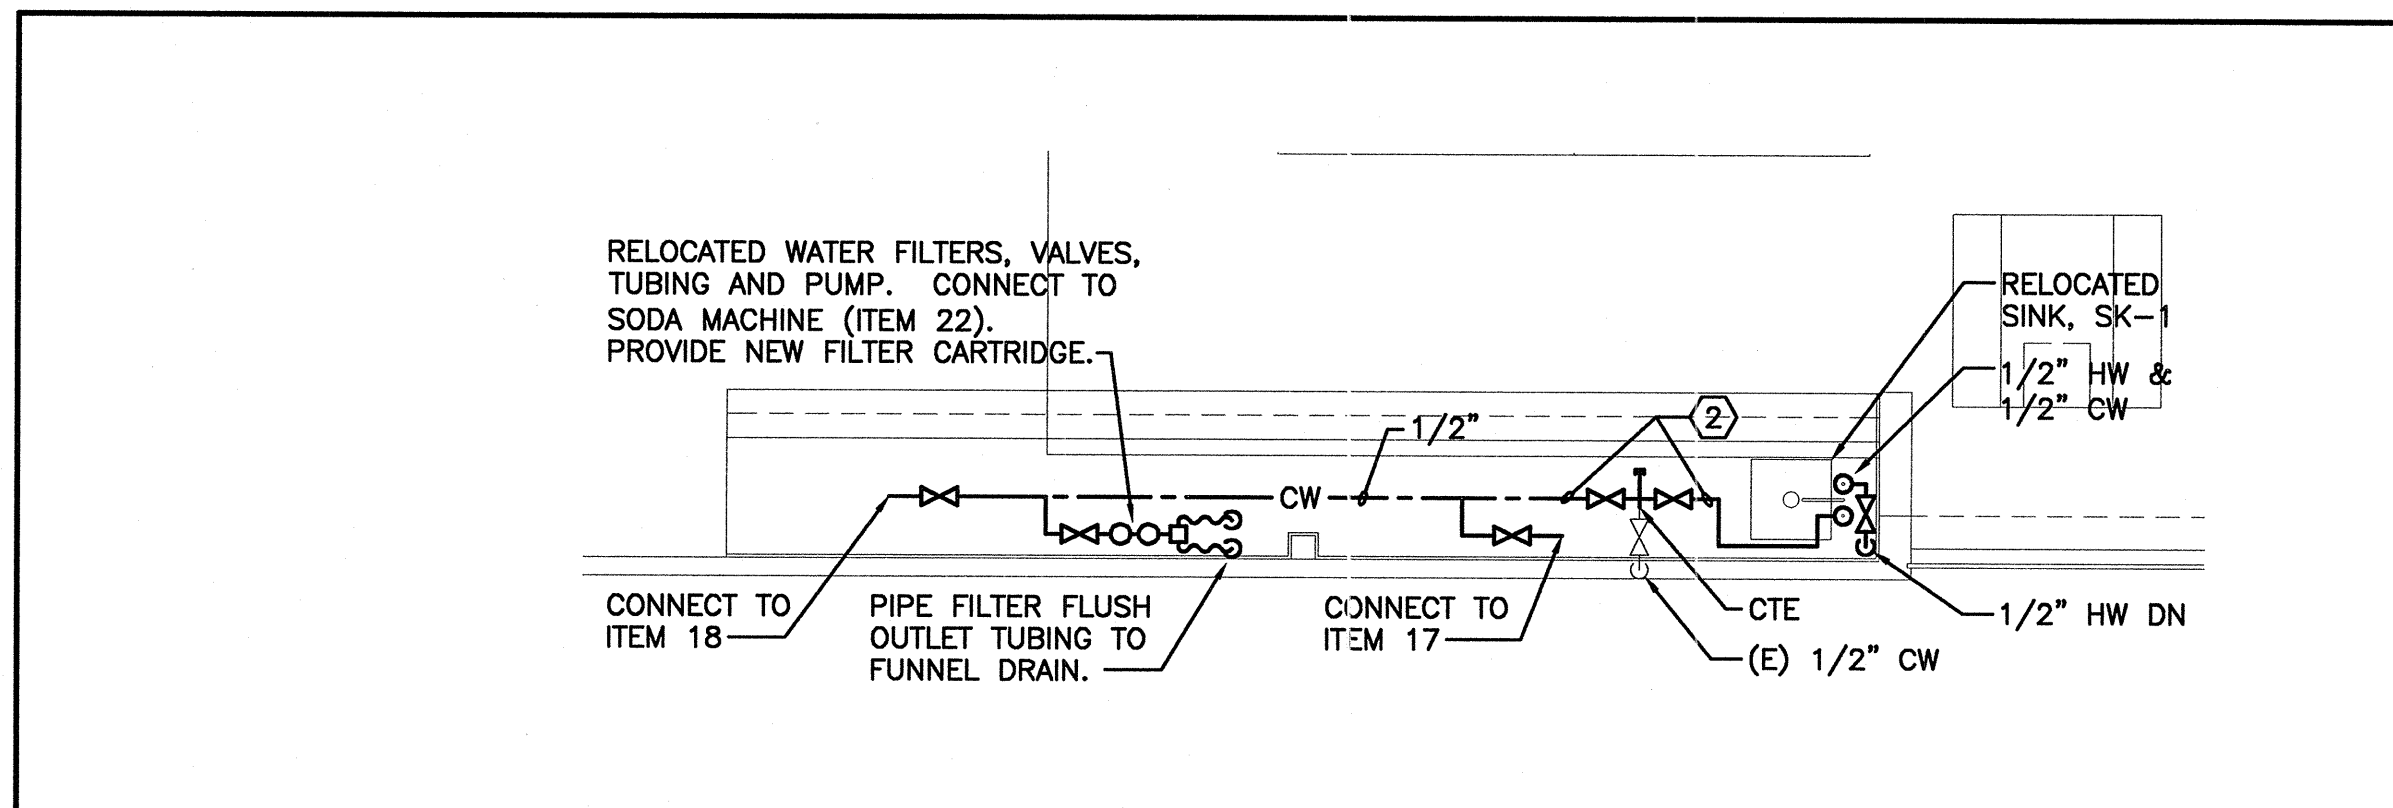

F7 BEVERAGE AREA SUPPLY PIPING PART PLAN
1/4"=1'-0"

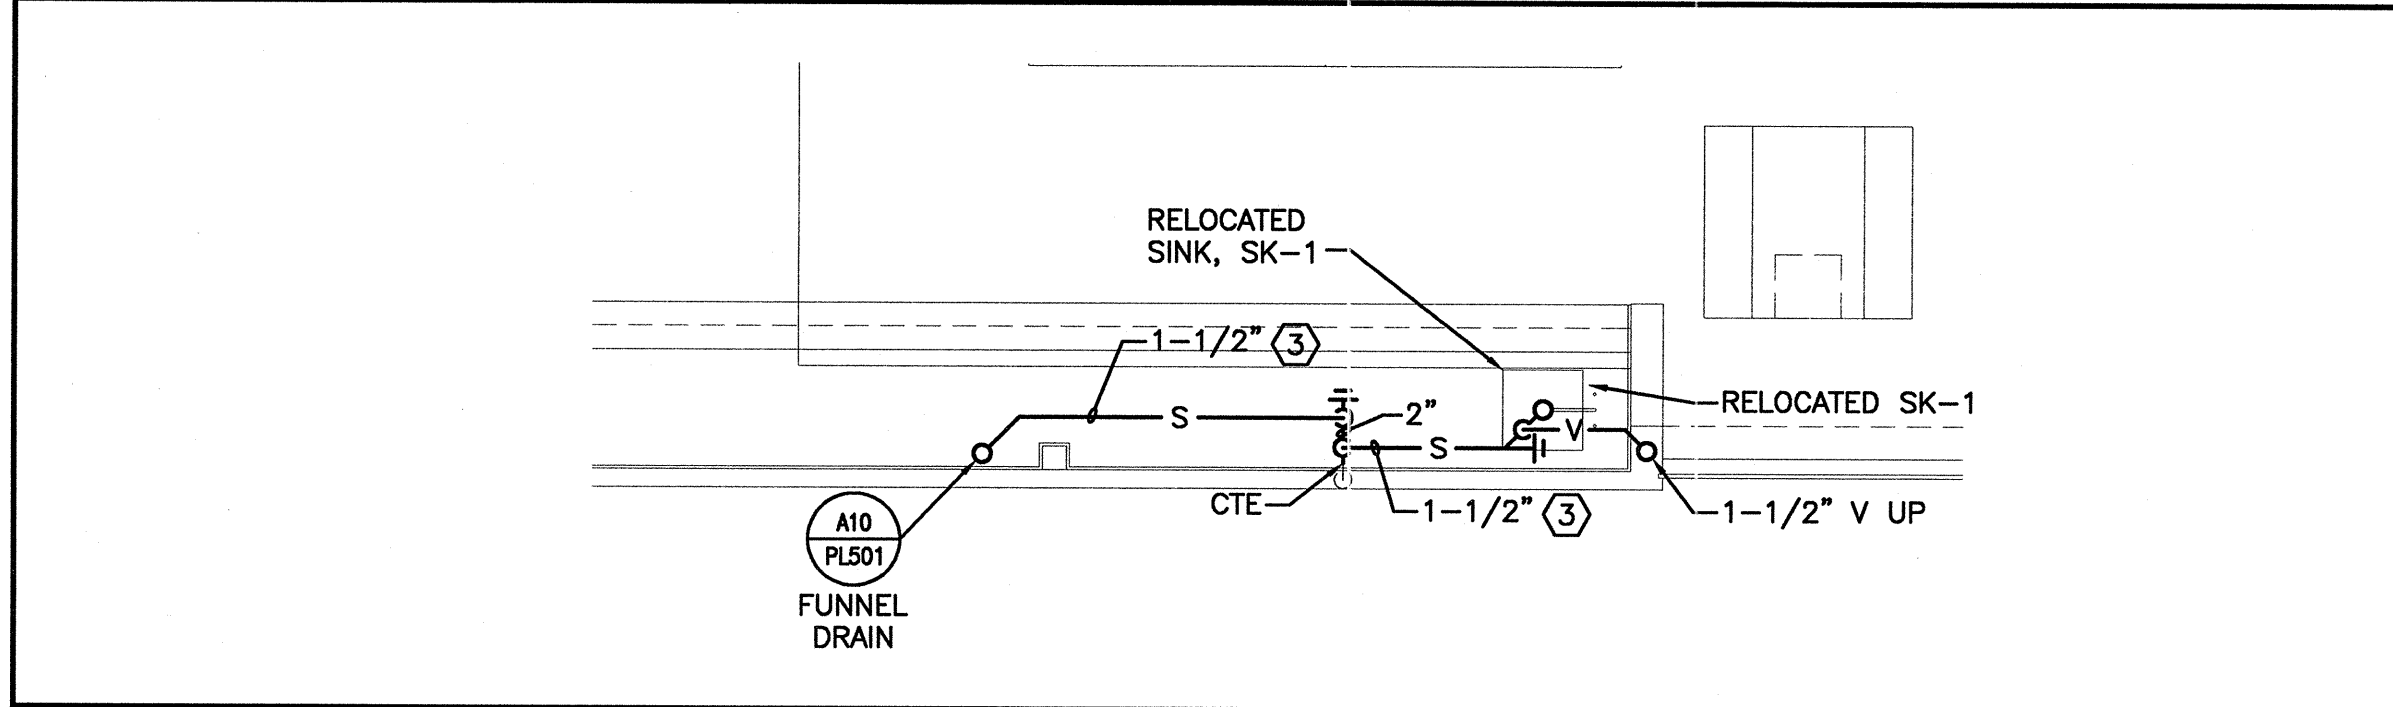

C7 BEVERAGE AREA DWV PIPING PART PLAN
1/4"=1'-0"

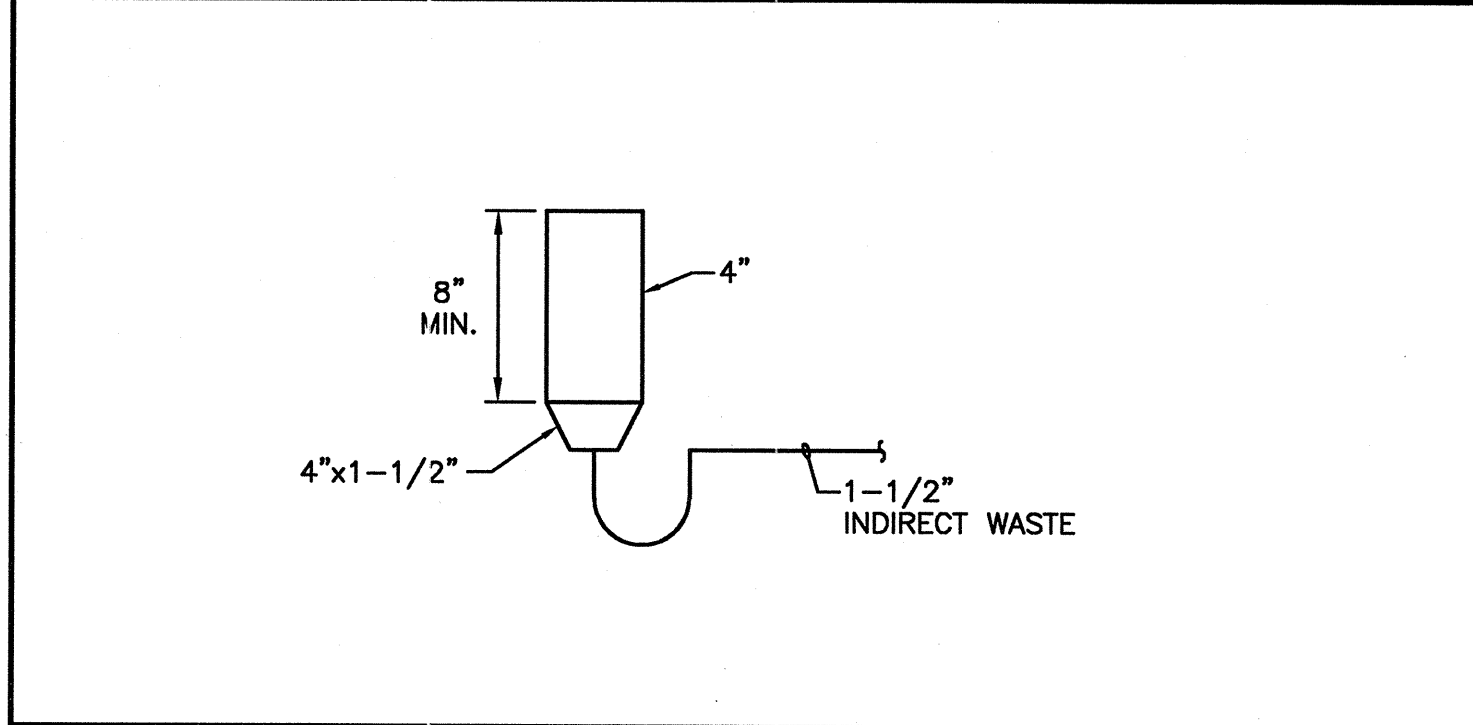

A10 FUNNEL DRAIN DETAIL
NOT TO SCALE

NOTE:
1. SEE SHEET M-001 FOR LEGEND AND ABBREVIATIONS.

SMT RT
ARCHITECTURE ENGINEERING PLANNING
144 Fore Street/P.O. Box 618
Portland, Maine 04104
Tel. (207) 772-3846
Fax. (207) 772-1070

UNIMPROVIDENT CORPORATION
HO-1 BEACON PHASE II
PORTLAND, MAINE
ISSUED FOR CONSTRUCTION
8-16-2004

PROJECT TITLE:
CURRENT ISSUE STATUS:
DATE

REV	DESCRIPTION	DATE
0	ISSUED FOR CONSTRUCTION	8-16-04

GRAPHIC SCALE:
0" 1"

SCALE: AS NOTED
PROJECT MANAGER: JLH
JC/DRAWN BY: CEB/BGG
A/E OF RECORD: LPA
CAD FILE: PL501-04054
PROJECT NO: 04054-00
DATE: 8-16-04

SHEET TITLE:
DETAILS, PART PLANS AND SCHEDULES

SHEET No.
PL501