


A9 REFLECTED CEILING PLAN
1/8"=1'-0"

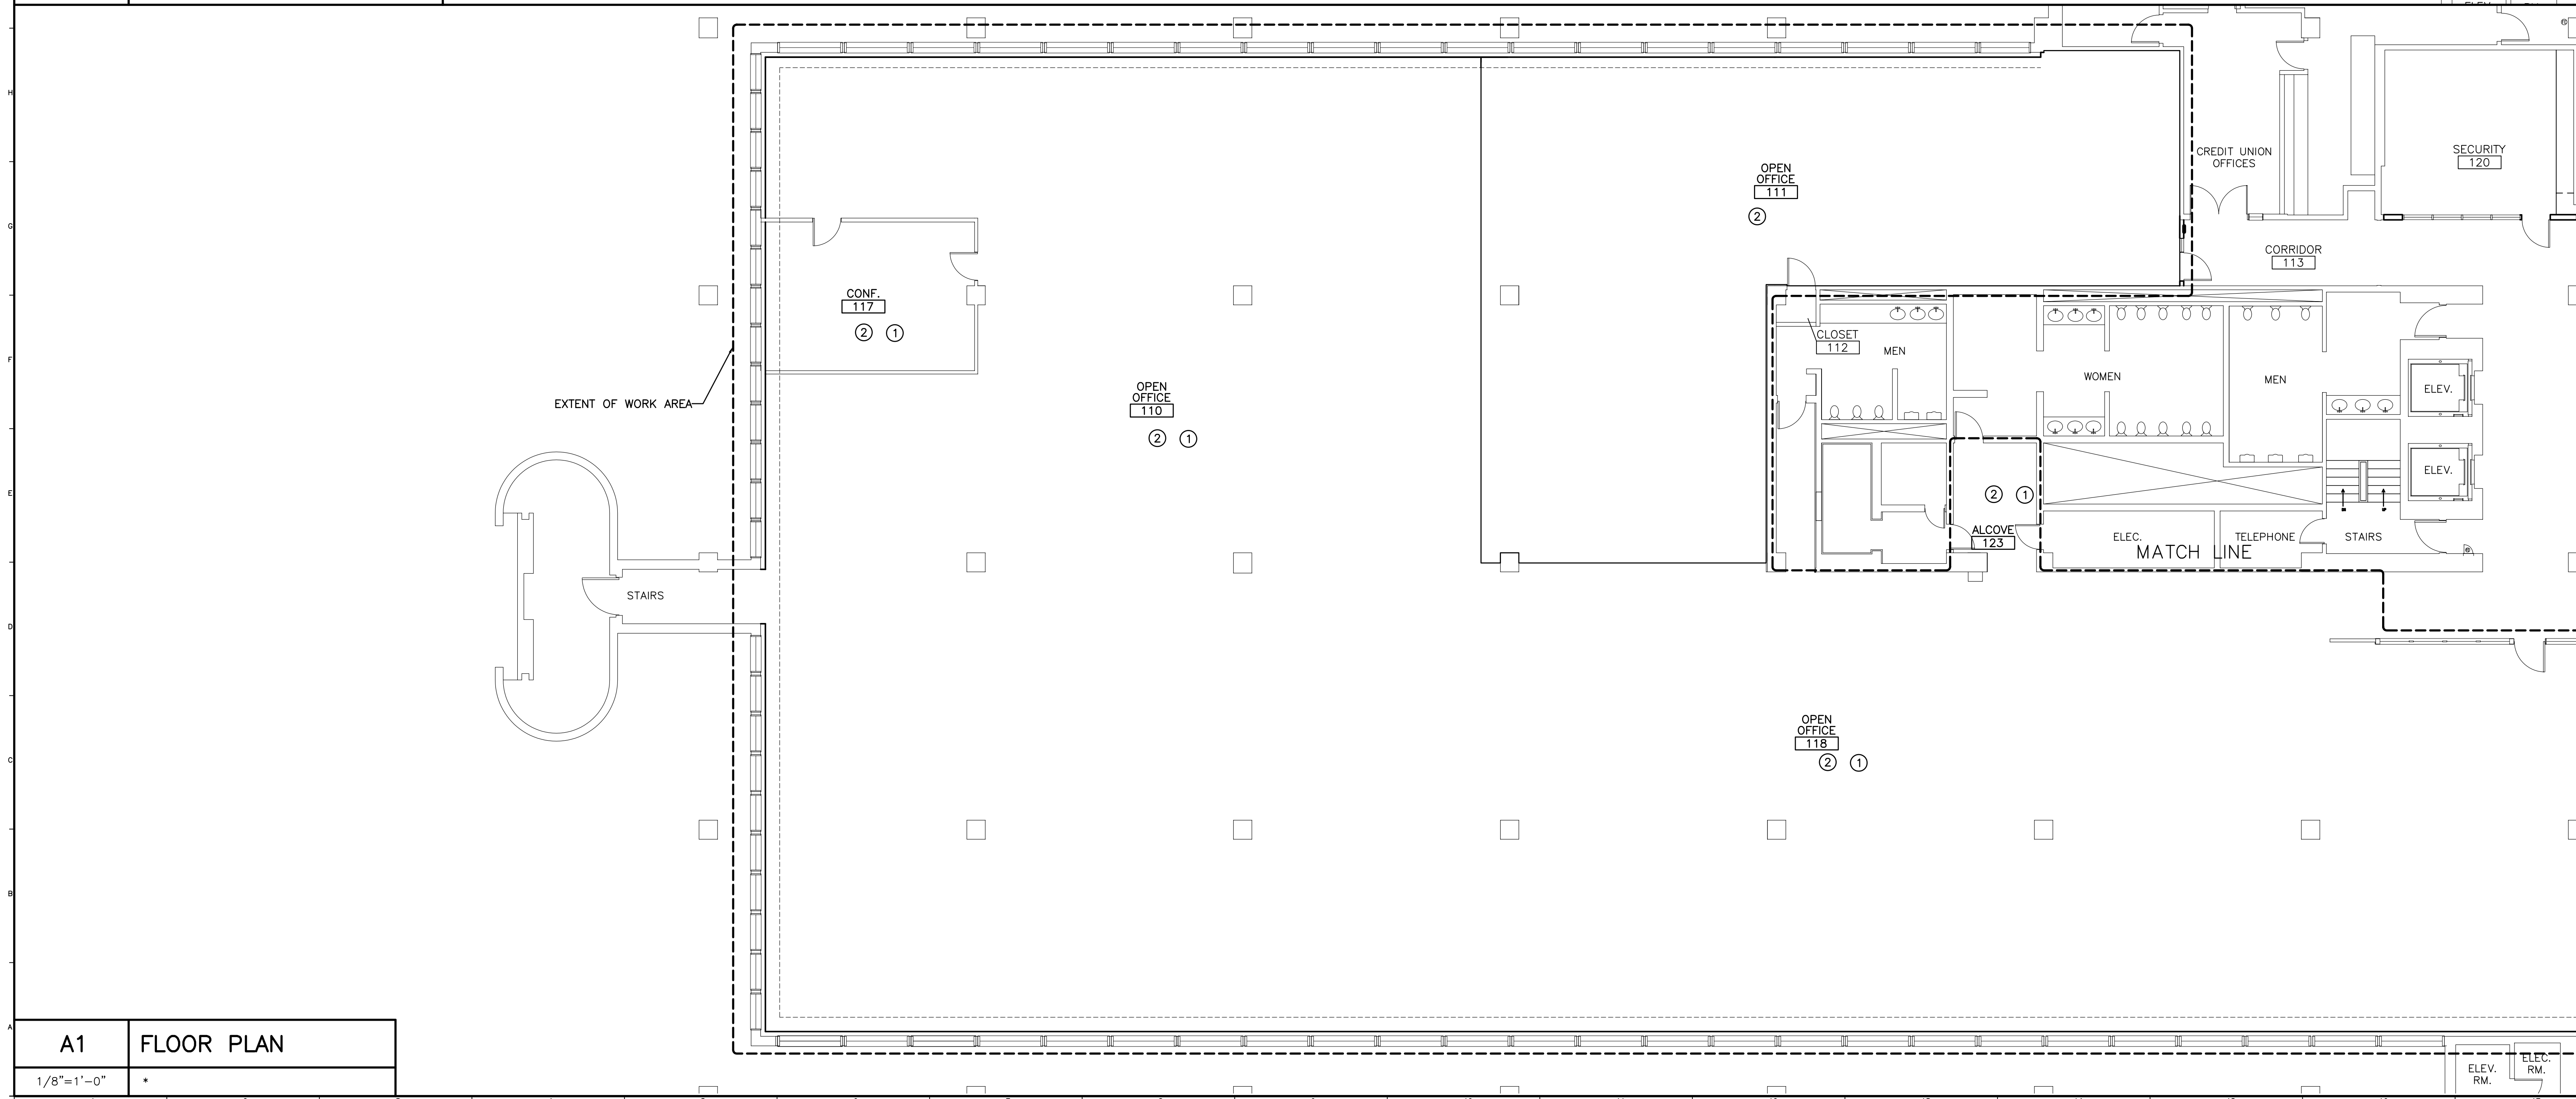

A1 FLOOR PLAN
1/8"=1'-0"

SYMBOL LEGEND

- 2x4 SUSPENDED CEILING PANEL AND GRID ASSEMBLY.
- GWB CEILING.
- 2x2 LAY-IN LIGHT FIXTURE.
- 2x4 LAY-IN LIGHT FIXTURE.
- 1x4 LIGHT FIXTURE.
- FLOURESCENT STRIP SIXTURE.
- DOWN LIGHT.
- CEILING MOUNTED EXIST LIGHT.
- RETURN AIR GRILLE.
- SUPPLY AIR GRILLE.
- EXHAUST AIR GRILLE.
- SPRINKLER HEAD.
- CEILING MOUNTED SPEAKER.
- CEILING MOUNTED SMOKE DETECTOR.

FINISH ABBREVIATIONS

- ACT ACOUSTICAL CEILING TILE
- CPT CARPET
- CT CERAMIC TILE
- GWB GYPSUM WALLBOARD
- PTD PAINTED
- Q.T. QUARRY TILE
- CPT-1 MILLIKEN "SQUIGGLES"
- CPT-2 MILLIKEN "WINDOWPANE"

KEY NOTES:

- ① INSTALL NEW FLOOR FINISH AND BASE.
- ② REPAIR/PATCH ALL WALL SURFACES AND PAINT.
- ③ INSTALL NEW CEILING GRID AND TILES AS INDICATED. REPLACE ANY CRACKED OR DAMAGED TILES AS NECESSARY.

NOTE: SEE AE102 FOR ROOM FINISH SCHEDULE.

0	ISSUED FOR CONSTRUCTION-PHASE 3	6-9-03
REV.	DESCRIPTION	DATE

ISSUED FOR CONSTRUCTION PHASE 3 6-9-03

CURRENT ISSUE STATUS:		

SMRT ARCHITECTURE ENGINEERING PLANNING
144 Fore Street/P.O. Box 618
Portland, Maine 04104
tel. (207) 772-3846
fax. (207) 772-1070

UNUMPROVIDENT H01 OPEN OFFICE RENOVATIONS
PORTLAND, ME.

PHASE 3-FLOOR PLAN, REFLECTED CEILING PLAN & DETAILS

SHEET TITLE:	SCALE: 1/8"=1'-0"	DATE: 6-9-03
PROJECT MANAGER: JLH	JOB CAP/DRAWN: RJL	GRAPHIC SCALE: 0" 1"
A/E OF RECORD: JLH	SMRT CAD FILE: AE103-03051	SHEET No. AE103
PROJECT No. 03051		