


A1 DEMOLITION PLAN

1/8"=1'-0"

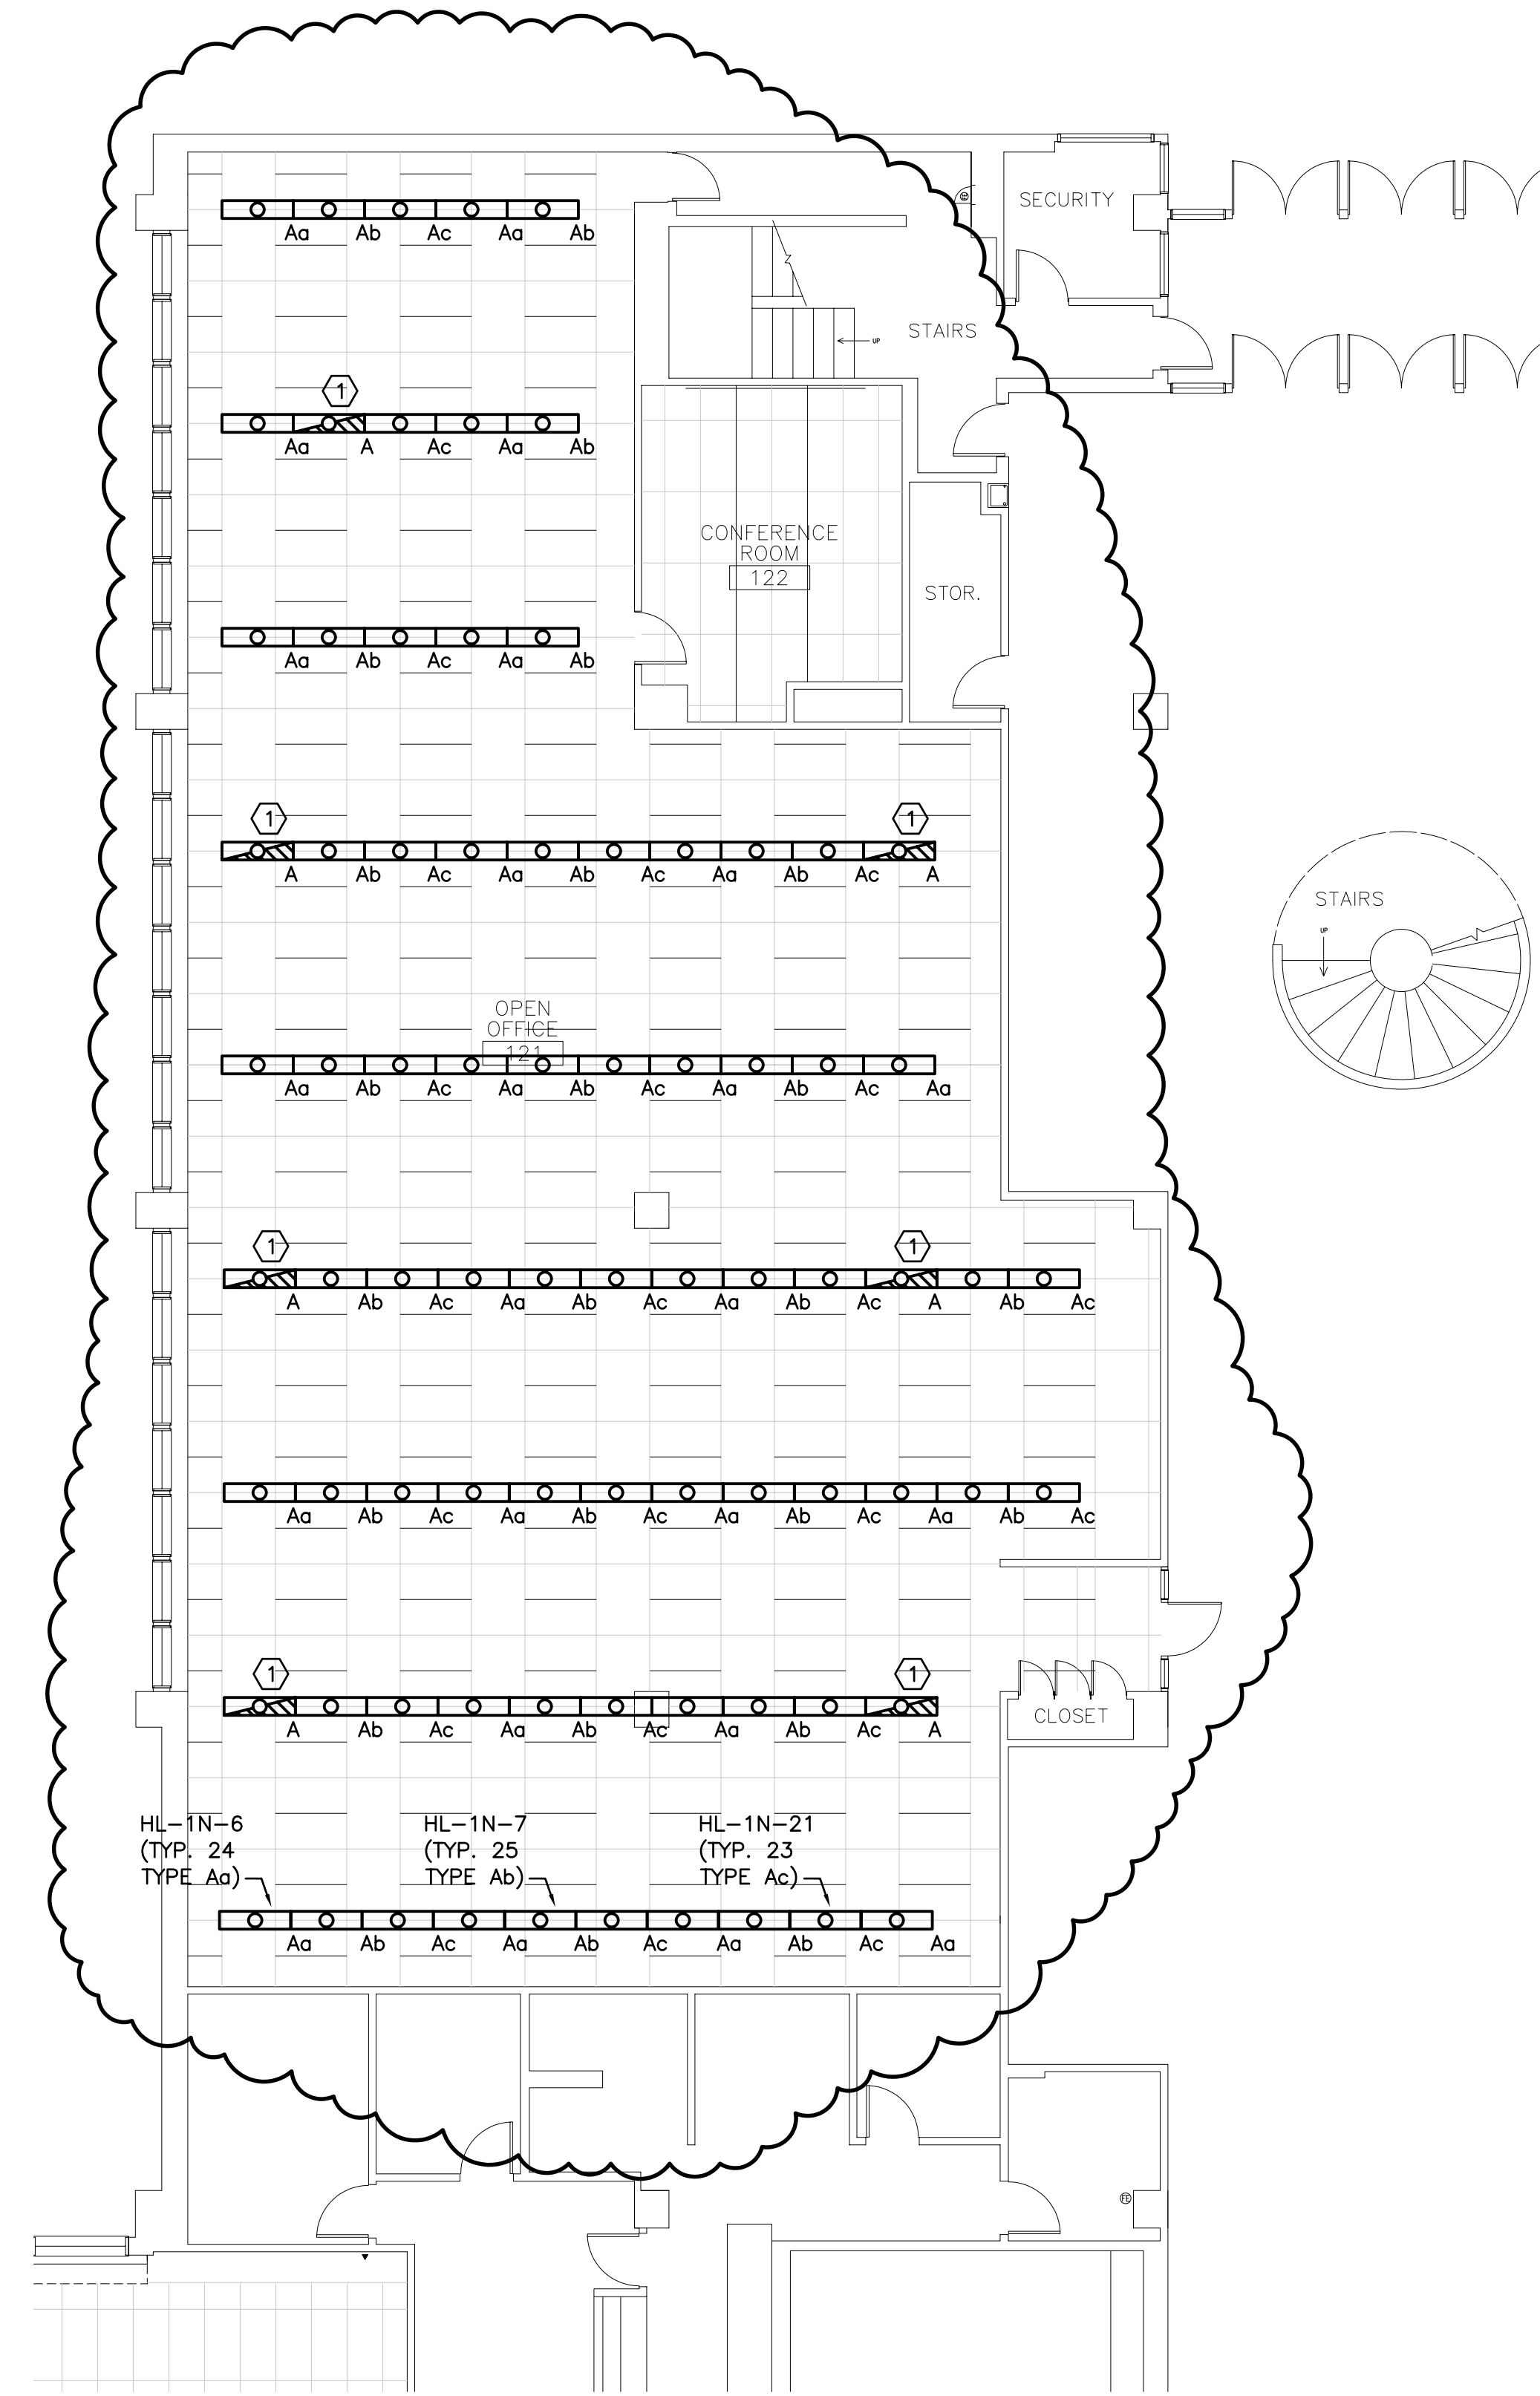

A9 FLOOR PLAN

1/8"=1'-0"

**NOTES:**

1. SEE SHEET E-001 FOR LEGEND AND GENERAL NOTES.
2. REMOVE EXISTING 1x4 & 1x3 FIXTURES AS INDICATED. RE-USE BRANCH CIRCUITS FOR NEW LIGHTING.
3. LIGHTS TO BE CONTROLLED (SWITCHED) BY ANDOVER CONTROL SYSTEM. EACH BRANCH CIRCUIT TO BE CONTROLLED AS A SEPARATE ZONE AND BE WIRED SO THAT EVERY THIRD 4' SECTION TO SWITCH SEPARATELY TO ALLOW FOR THREE DIFFERENT LIGHT LEVELS.
4. EXISTING EXIT SIGNS TO REMAIN AS IS.
5. SEE SHEET E-101 FOR LOCATION OF PANELBOARD HL-1N AND ANDOVER CONTROL PANEL.
6. LIGHT FIXTURES SHOWN AS 4' TO SHOW SWITCHING CONFIGURATION AND CIRCUIT WIRING. COORDINATE WITH LIGHTING SUPPLIER FOR EXACT LENGTH AND CONFIGURATION OF FIXTURES.

**KEYED NOTE:**

- ① RE-USE EXISTING EMERGENCY LIGHTING BRANCH CIRCUIT IN OPEN OFFICE 121 FOR NEW LIGHTS SHOWN. FIELD VERIFY THAT BRANCH CIRCUIT HAS CAPACITY FOR ADDITIONAL (420 WATTS) LOAD.

1	ISSUED FOR SI-2	6-9-03
0	ISSUED FOR CONSTRUCTION - PHASE 2	6-2-03
REV.	DESCRIPTION	DATE

**ISSUE FOR SI-2  
6-9-03**

CURRENT ISSUE STATUS:		

**SMRT** ARCHITECTURE ENGINEERING PLANNING  
 SMRT  
 144 Fore Street/P.O. Box 618  
 Portland, Maine 04104  
 tel. (207) 772-3846  
 fax. (207) 772-1070

**UNUMPROVIDENT  
H01 OPEN OFFICE RENOVATIONS  
PORTLAND, ME.**

**PHASE 2-  
ELECTRICAL PLAN**

SHEET TITLE:	1/8"=1'-0"	DATE:	6-2-03
PROJECT MANAGER:	JLH	GRAPHIC SCALE:	0" 1"
JOB CAP/DRAWN:	RJL/JAC	A/E OF RECORD:	DJT
SMRT CAD FILE:	E-102-03051	SHEET No.	E-102
PROJECT No.	03051		