 
 
 
 
 
 













SYMBOL LEGEND

-  2x4 SUSPENDED CEILING PANEL AND GRID ASSEMBLY.
-  GWB CEILING.
-  2x2 LAY-IN LIGHT FIXTURE.
-  2x4 LAY-IN LIGHT FIXTURE.
-  1x4 LIGHT FIXTURE.
-  FLOURESCENT STRIP SIXTURE.
-  DOWN LIGHT.
-  CEILING MOUNTED EXIST LIGHT.
-  RETURN AIR GRILLE.
-  SUPPLY AIR GRILLE.
-  EXHAUST AIR GRILLE.
-  SPRINKLER HEAD.
-  CEILING MOUNTED SPEAKER.
-  CEILING MOUNTED SMOKE DETECTOR.



| | | |
|--|--|--------------|
| | | |
| 0 | ISSUED FOR CONSTRUCTION | 6-2-03 |
| REV. | DESCRIPTION | DATE |
| ISSUED FOR CONSTRUCTION | | |
| 6-2-03 | | |
| CURRENT ISSUE STATUS: | | |
| PROJECT NORTH  | | |
|  | ARCHITECTURE ENGINEERING PLANNING SMRT 144 Fore Street/P.O. Box 618 Portland, Maine 04104 tel. (207) 772-3846 fax. (207) 772-1070 | |
| UNUMPROVIDENT H01 | | |
| THE BEACON | | |
| PORTLAND, ME. | | |
| PROJECT: | | |
| ALTERNATE 1- REFLECTED CEILING PLAN | | |
| SHEET TITLE: | | |
| SCALE: 1/8"=1'-0" | DATE: 6-2-03 | |
| PROJECT MANAGER: JLH | GRAPHIC SCALE: 0" 1" | |
| JOB CAP/DRAWN: RJL | | |
| A/E OF RECORD: JLH | SHEET No. | |
| SMRT CAD FILE: AE102-02140 | | |
| PROJECT No. 02140 | | AE102 |

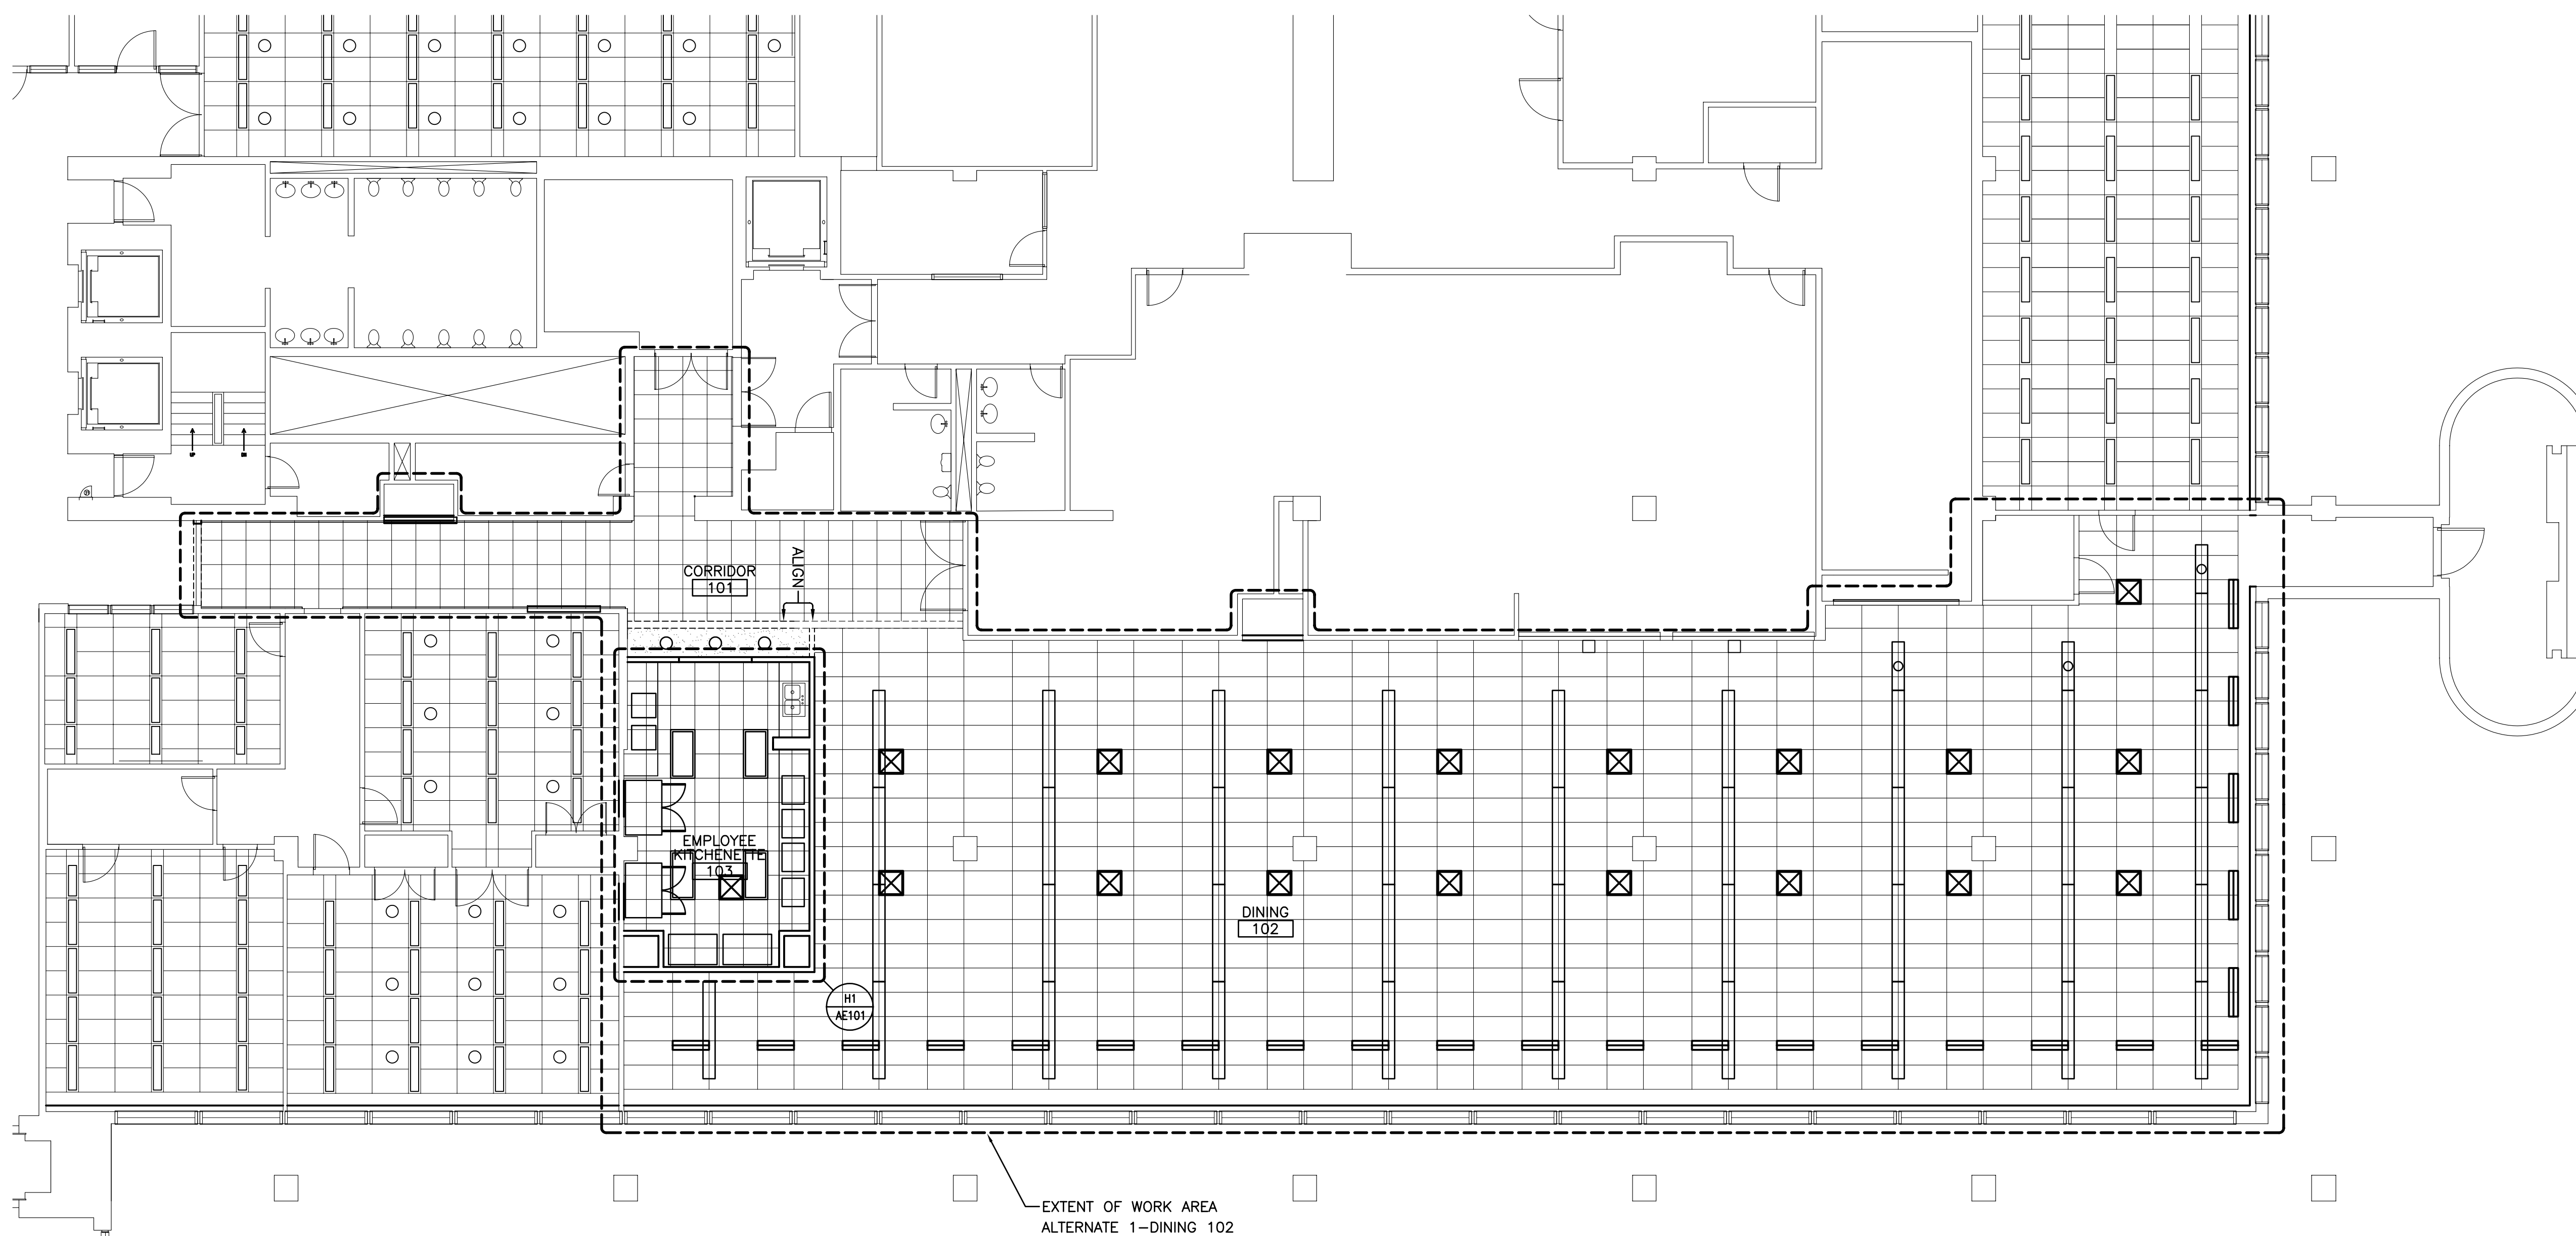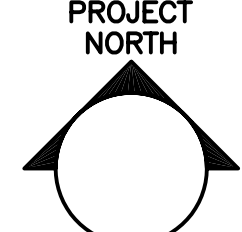A1 REFLECTED CEILING PLAN

1/8"=1'-0"