

NOTES:


- SEE SHEET E-001 FOR LEGEND AND GENERAL NOTES.
- EXTEND EXISTING FIRE ALARM NOTIFICATION CIRCUIT TO NEW FIRE ALARM NOTIFICATION DEVICE IN EMPLOYEE KITCHENETTE.
- PROVIDE EMPTY OUTLET BOX & 3/4" EMT TO ABOVE CEILING FOR NEW WALL PHONE.

KEYED NOTES:


- NEW DOWNLIGHTS TO BE FED FROM BRANCH CIRCUIT FEEDING EXISTING CORRIDOR LIGHTS. CONTROLS FOR NEW LIGHTS TO BE FROM SAME ZONE AS EXISTING CORRIDOR LIGHTS.
- MOUNT DOUBLE DUPLEX RECEPTACLE 45" AFF. TO CENTER OF DEVICE. EACH DUPLEX RECEPTACLE TO BE FED FROM A SEPARATE BRANCH CIRCUIT.
- MOUNT RECEPTACLE 45" AFF TO CENTER OF DEVICE.
- INSTALL 11 NEW 20A, 1P CIRCUIT BREAKERS IN EXISTING PANELBOARD AND RE-USE 4 EXISTING 20A, 1P SPARE CIRCUIT BREAKERS FOR NEW RECEPTACLES SHOWN.
- RELOCATE POWER WIRING FOR INSTANT HOT WATER HEATER LOCATED UNDER EXISTING SINK TO NEW SINK LOCATION. COORDINATE MOUNTING LOCATION WITH PLUMBING CONTRACTOR.
- RE-USE EXISTING CIRCUIT BREAKERS IN EXISTING PANELBOARD FOR NEW LIGHTING AND EXHAUST.
- RE-USE EXISTING EMERGENCY LIGHTING BRANCH CIRCUIT FOR NEW CAFETERIA EMERGENCY LIGHTS. FIELD VERIFY THAT BRANCH CIRCUIT HAS CAPACITY FOR ADDITIONAL (960 WATTS) LOAD.

ALTERNATE:


PROVIDE ALTERNATE PRICING FOR NEW PENDANT LIGHTS IN CAFETERIA. ALTERNATE PRICE TO ALSO INCLUDE DEMOLITION OF EXISTING LIGHTS. EVERY THIRD 4' SECTION TO BE SWITCHED SEPARATELY BY ANDOVER CONTROL SYSTEM TO ALLOW FOR THREE DIFFERENT LIGHTING LEVELS.

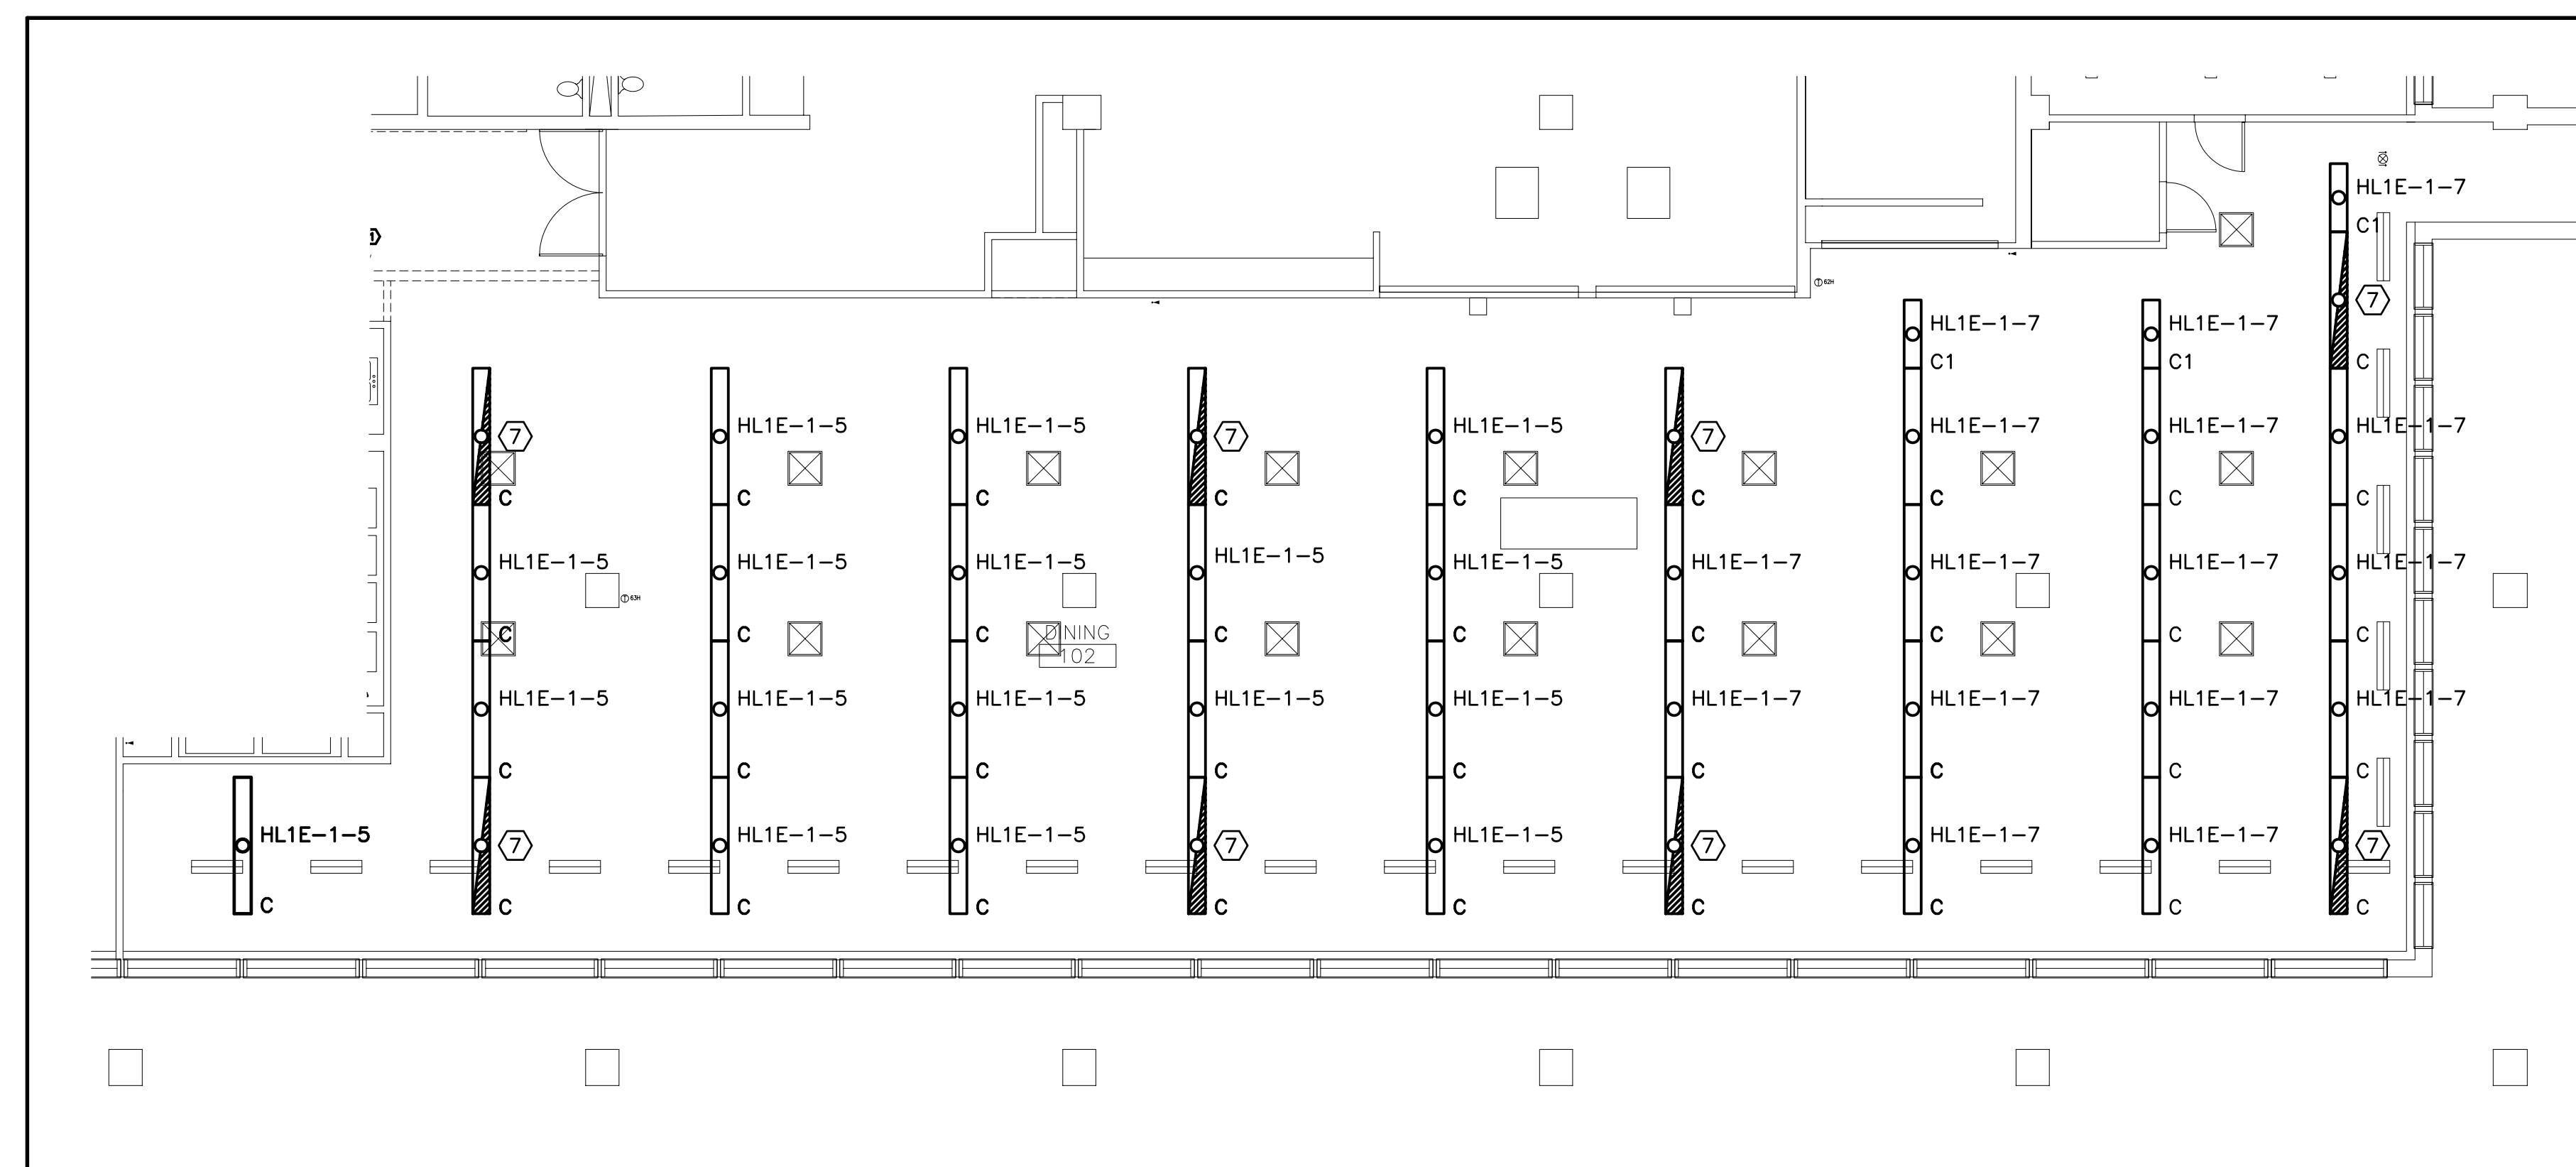


J1 DINING 102 LIGHTING PLAN
1/8"=1'-0"

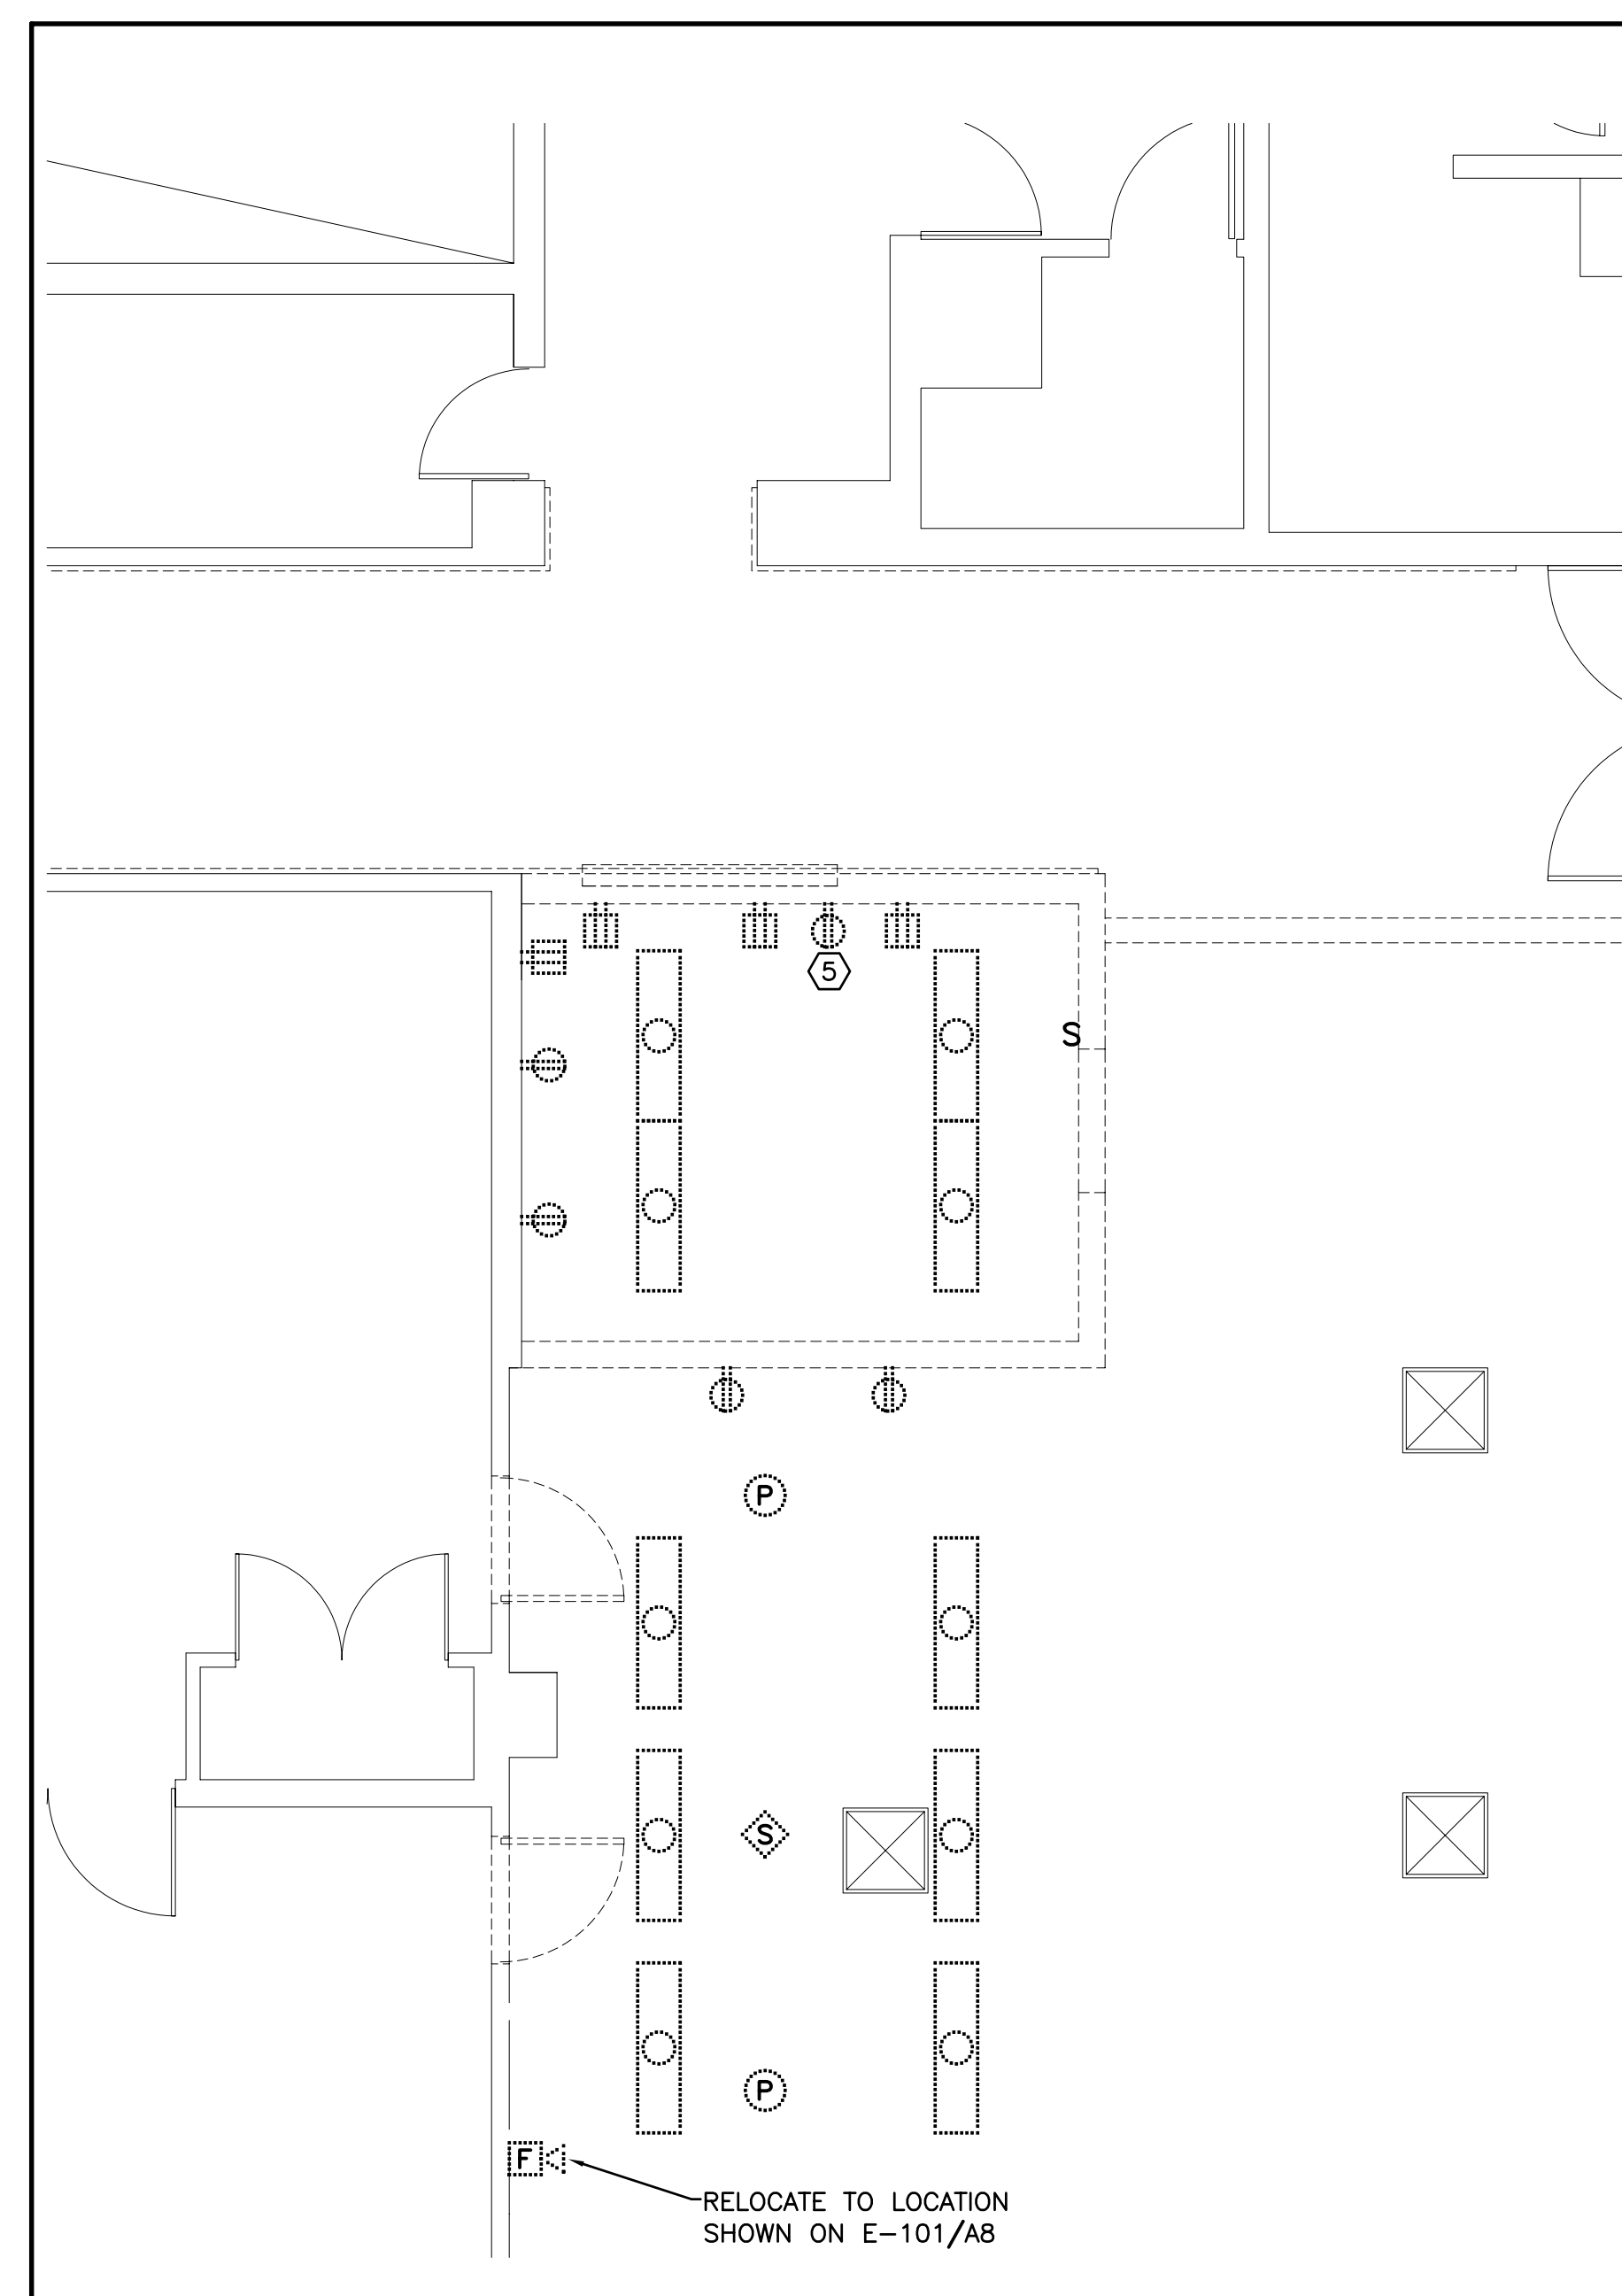

A1 DEMOLITION PLAN
1/4"=1'-0"

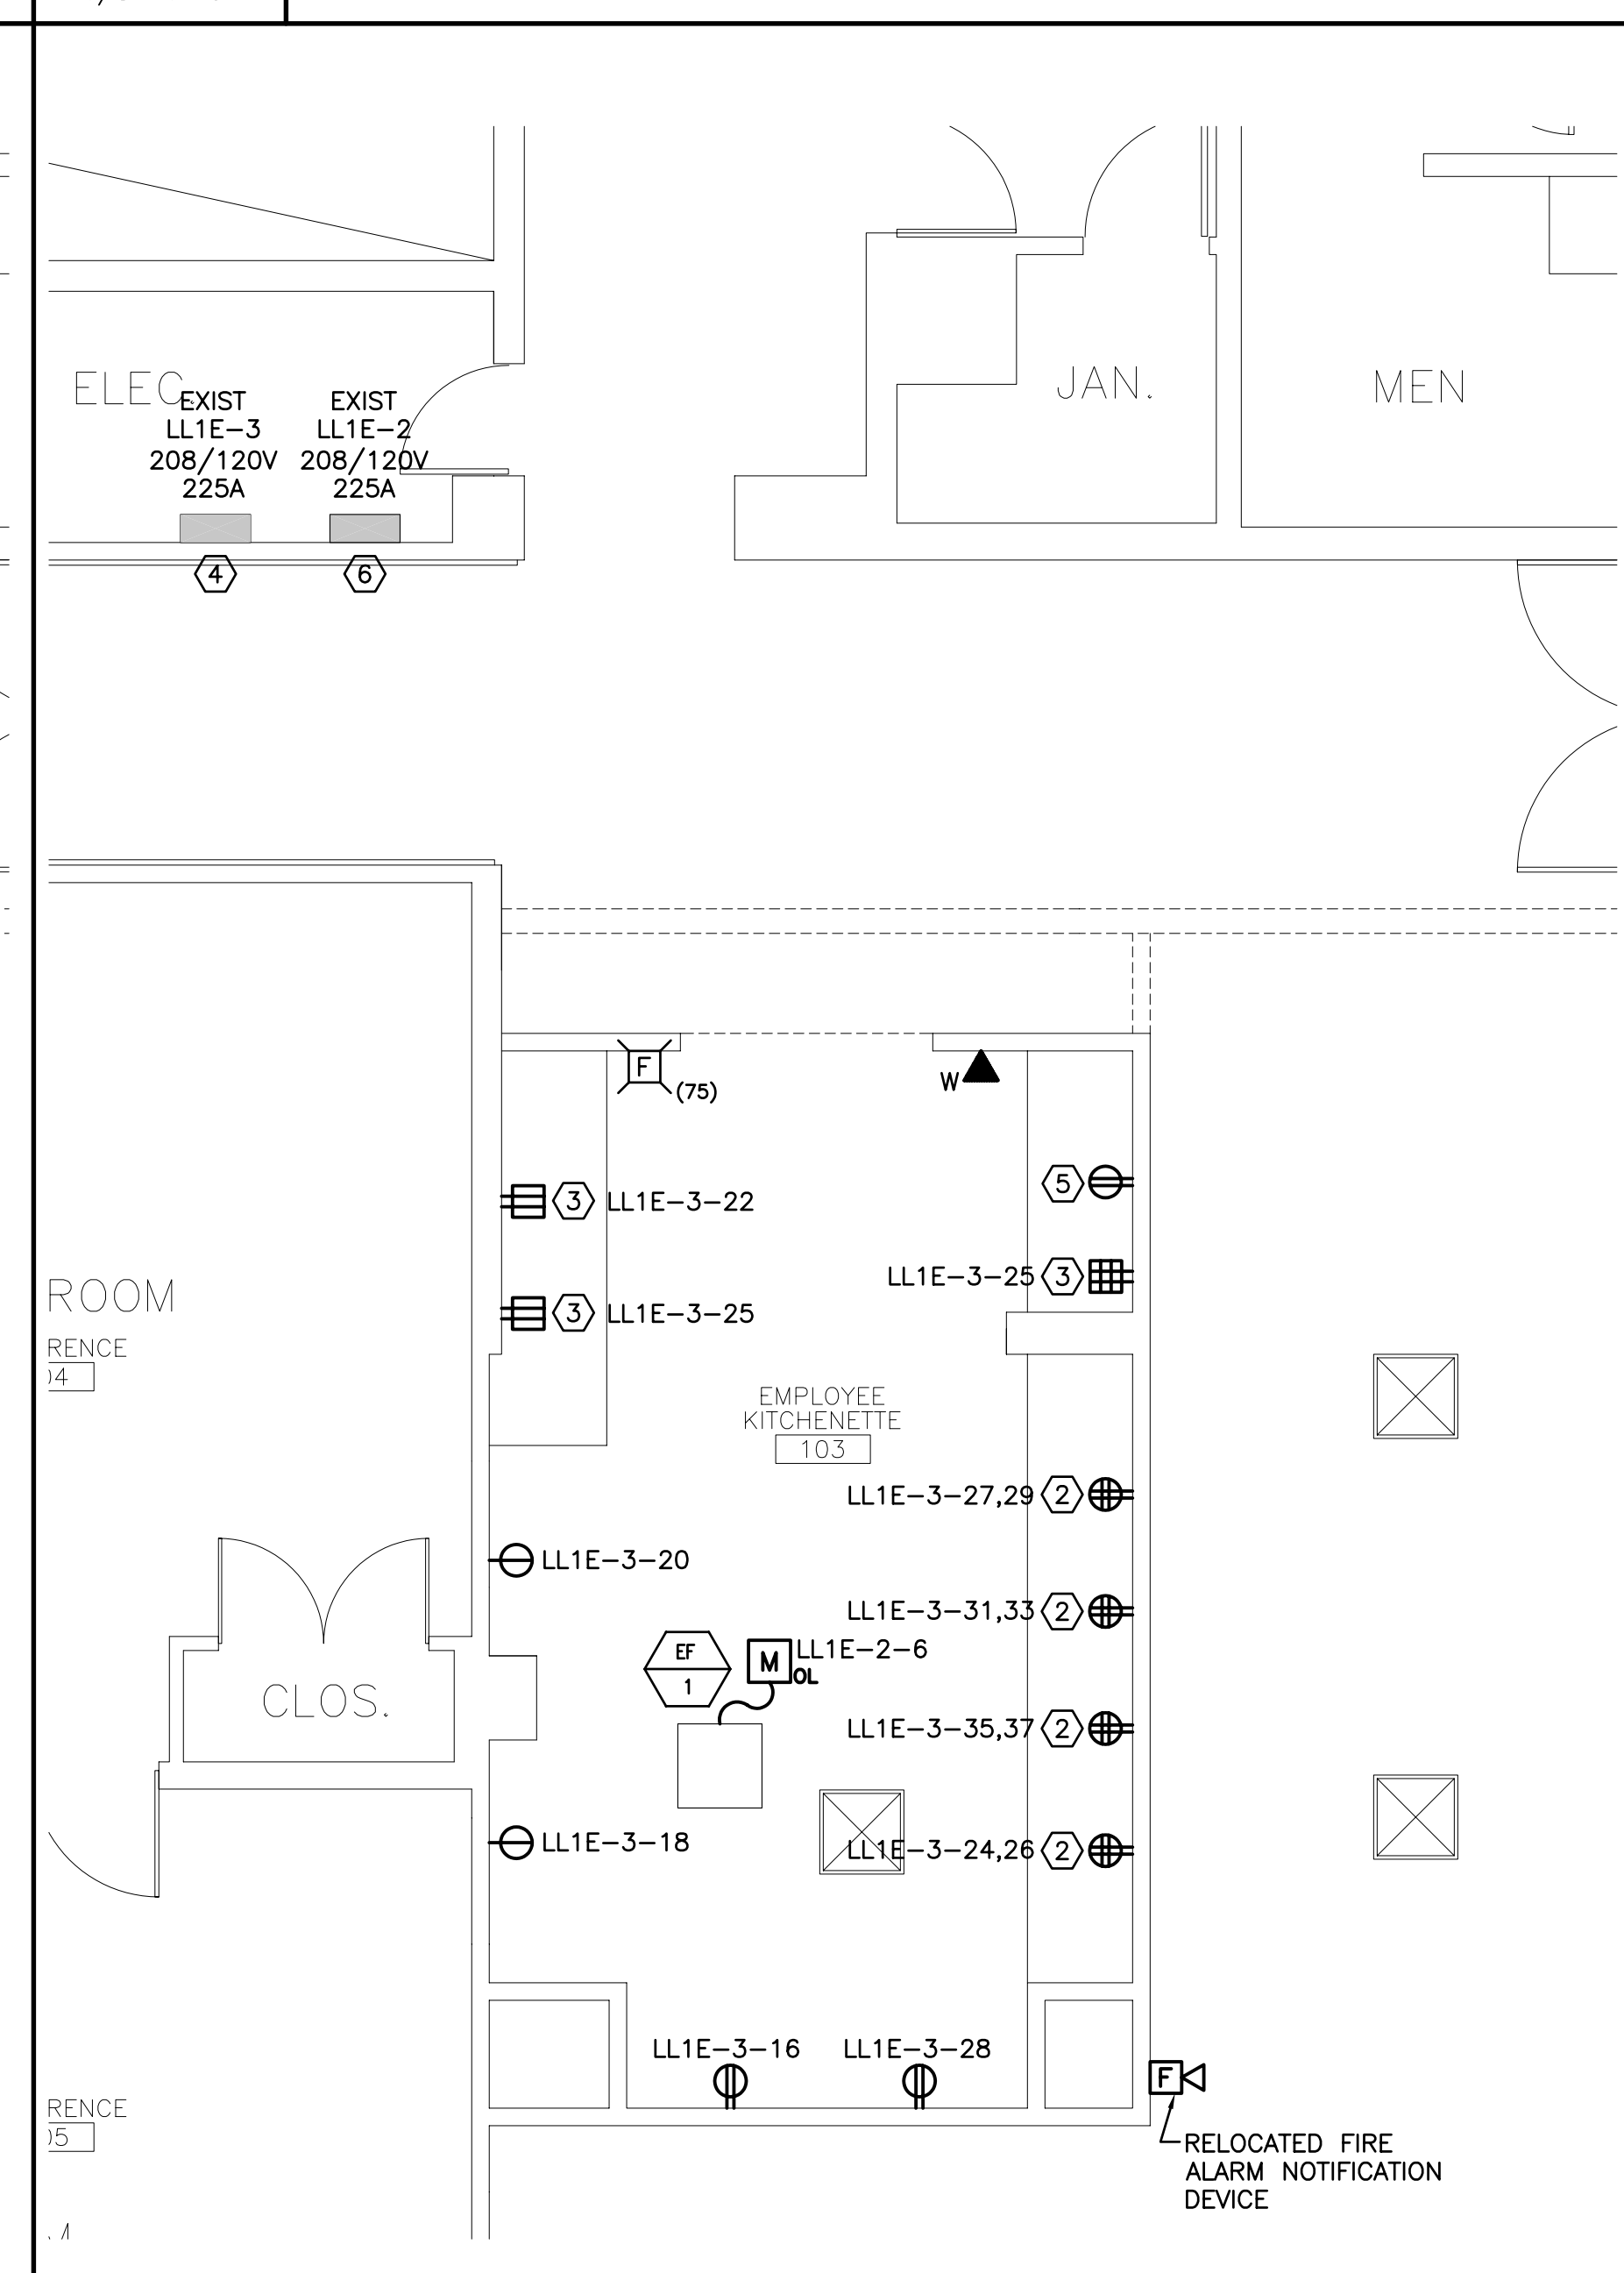

A8 POWER & SYSTEMS PLAN
1/4"=1'-0"

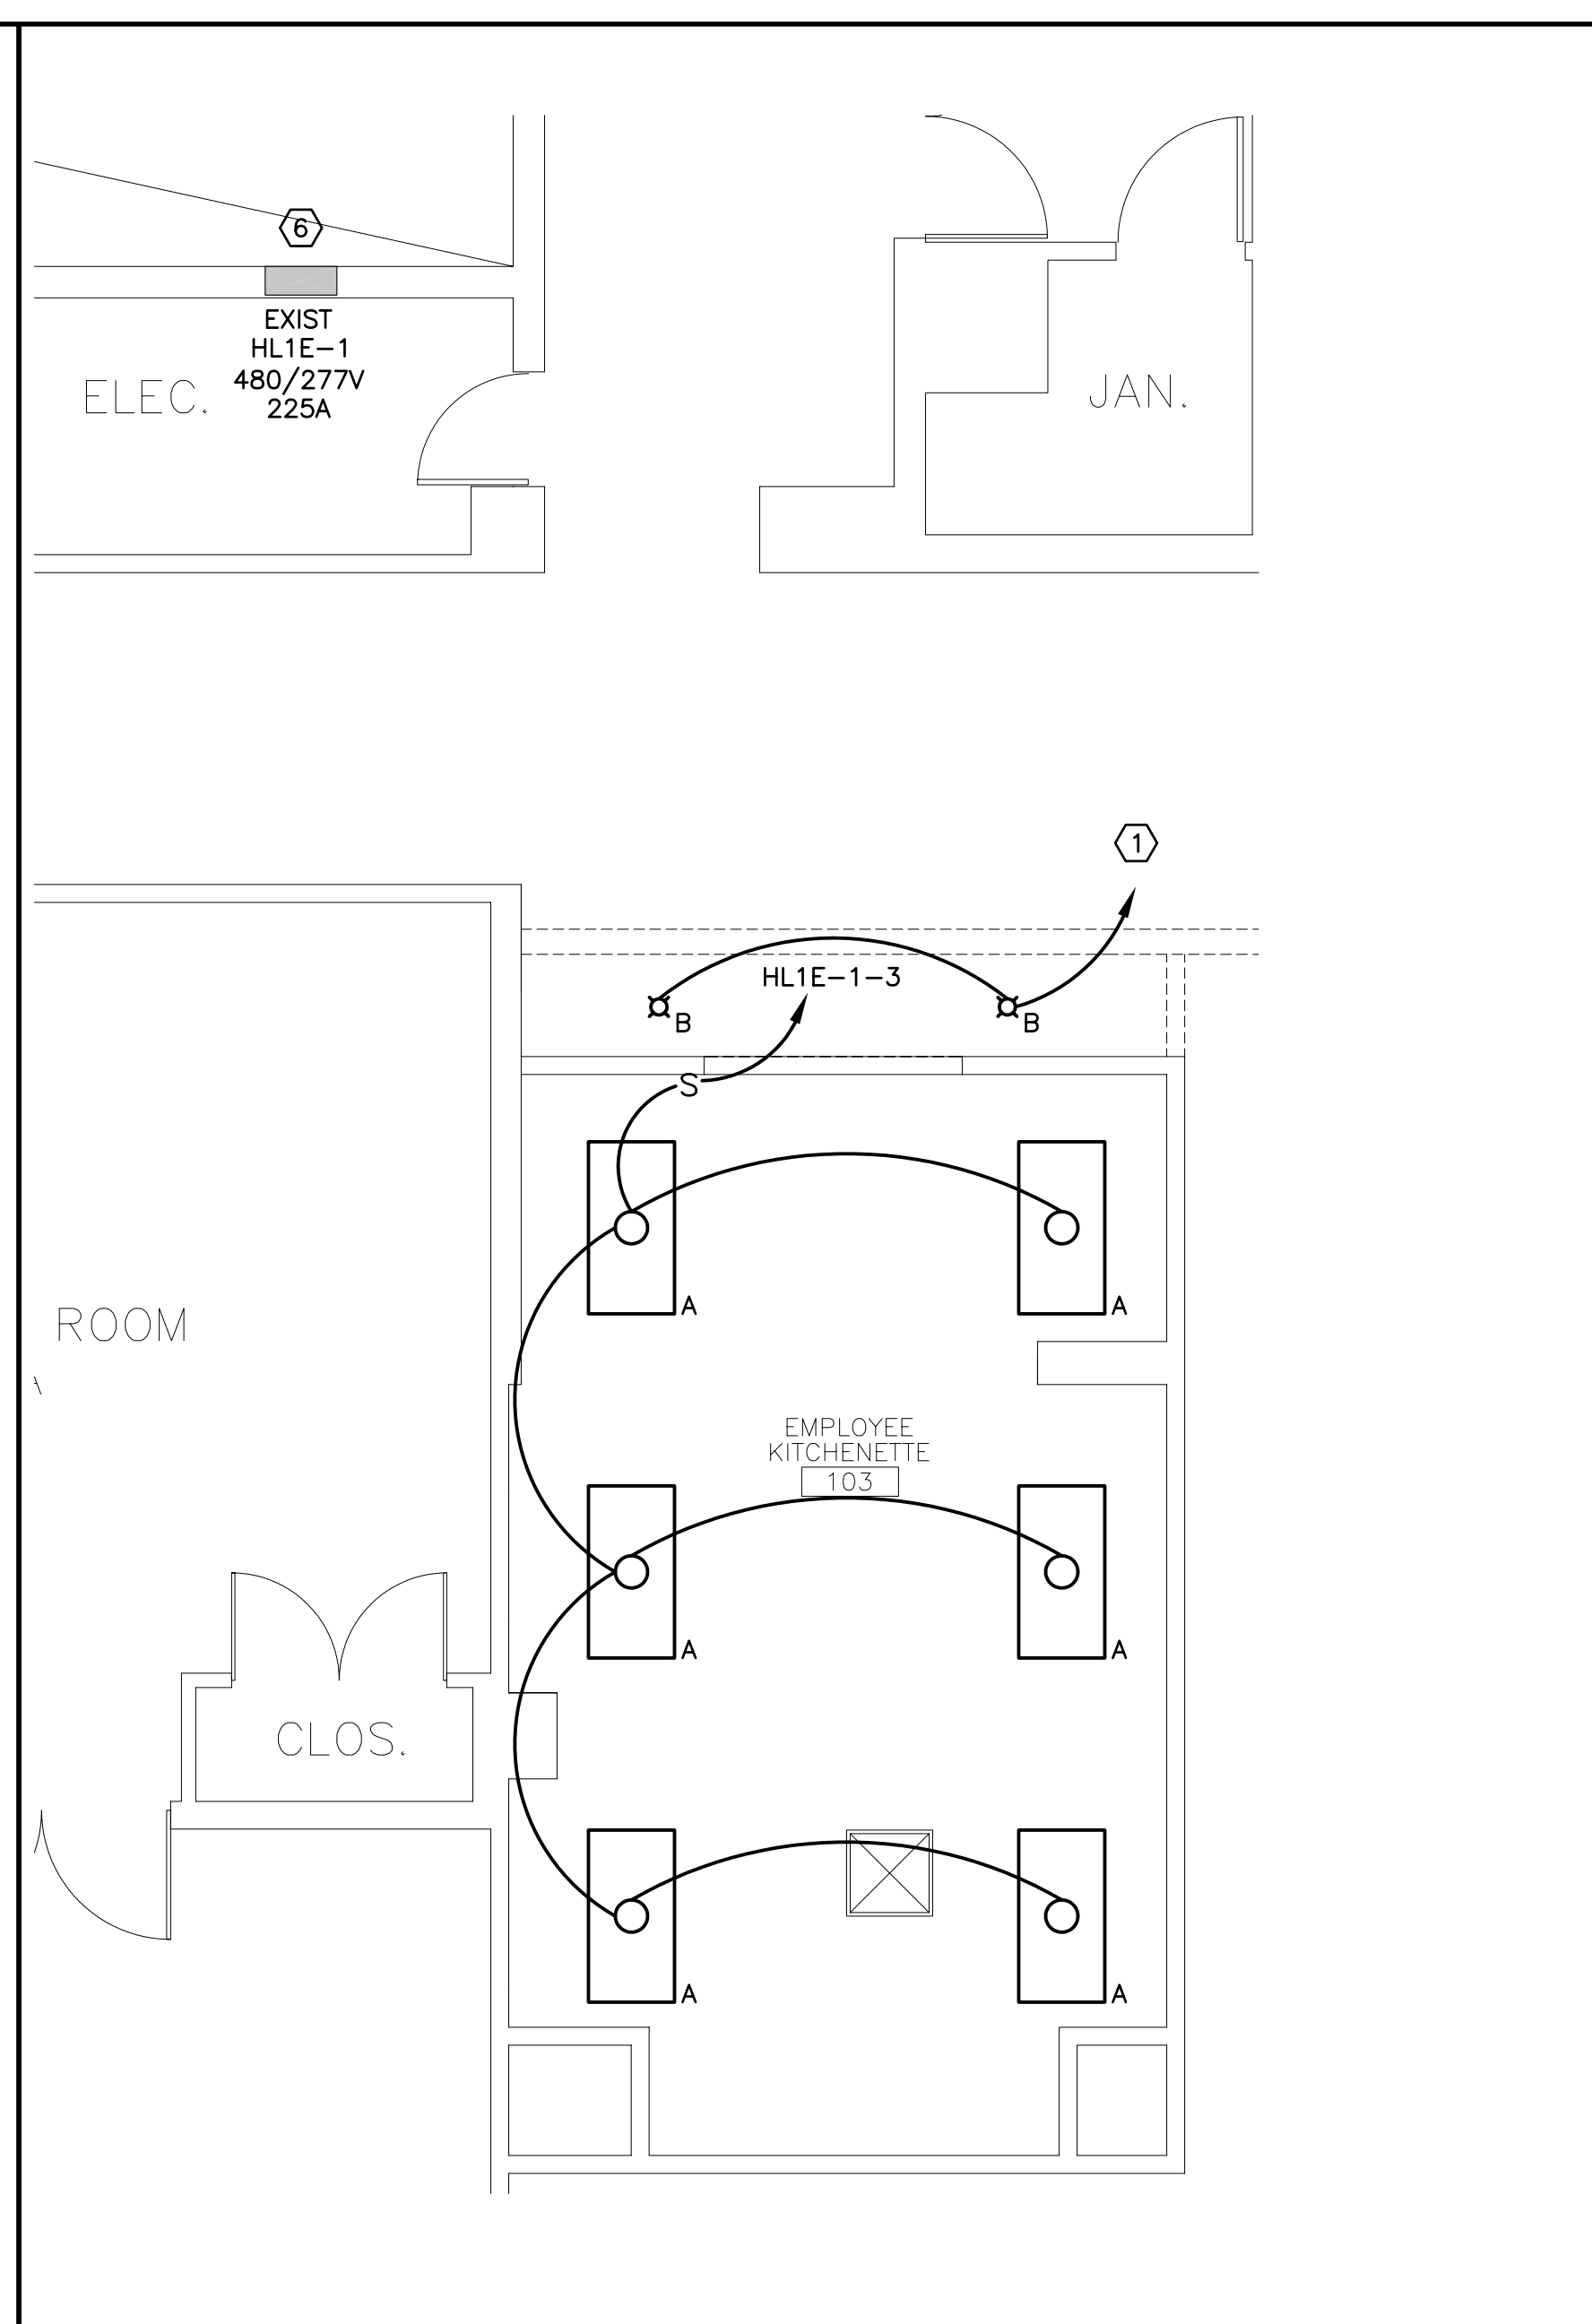

A13 EMPLOYEE KITCHENETTE 103 LIGHTING PLAN
1/4"=1'-0"

0	ISSUED FOR CONSTRUCTION	6-2-03
REV.	DESCRIPTION	DATE

ISSUED FOR CONSTRUCTION
6-2-03

CURRENT ISSUE STATUS:	

SM RT ARCHITECTURE ENGINEERING PLANNING
SMRT
144 Fore Street/P.O. Box 618
Portland, Maine 04104
tel. (207) 772-3846
fax. (207) 772-1070

UNUMPROVIDENT HO1
THE BEACON
PORTLAND, ME.

PROJECT: **ELECTRICAL POWER, SYSTEMS, LIGHTING & DEMOLITION PLANS**

SHEET TITLE:	AS NOTED	DATE:	6-2-03
SCALE:	AS NOTED	GRAPHIC SCALE:	0" = 1'
PROJECT MANAGER:	JLH	DATE:	6-2-03
JOB CAP/DRAWN:	RJL/JAC		
A/E OF RECORD:	DJT	SHEET No.	
SMRT CAD FILE:	E-101-02140		
PROJECT No.	02140		