
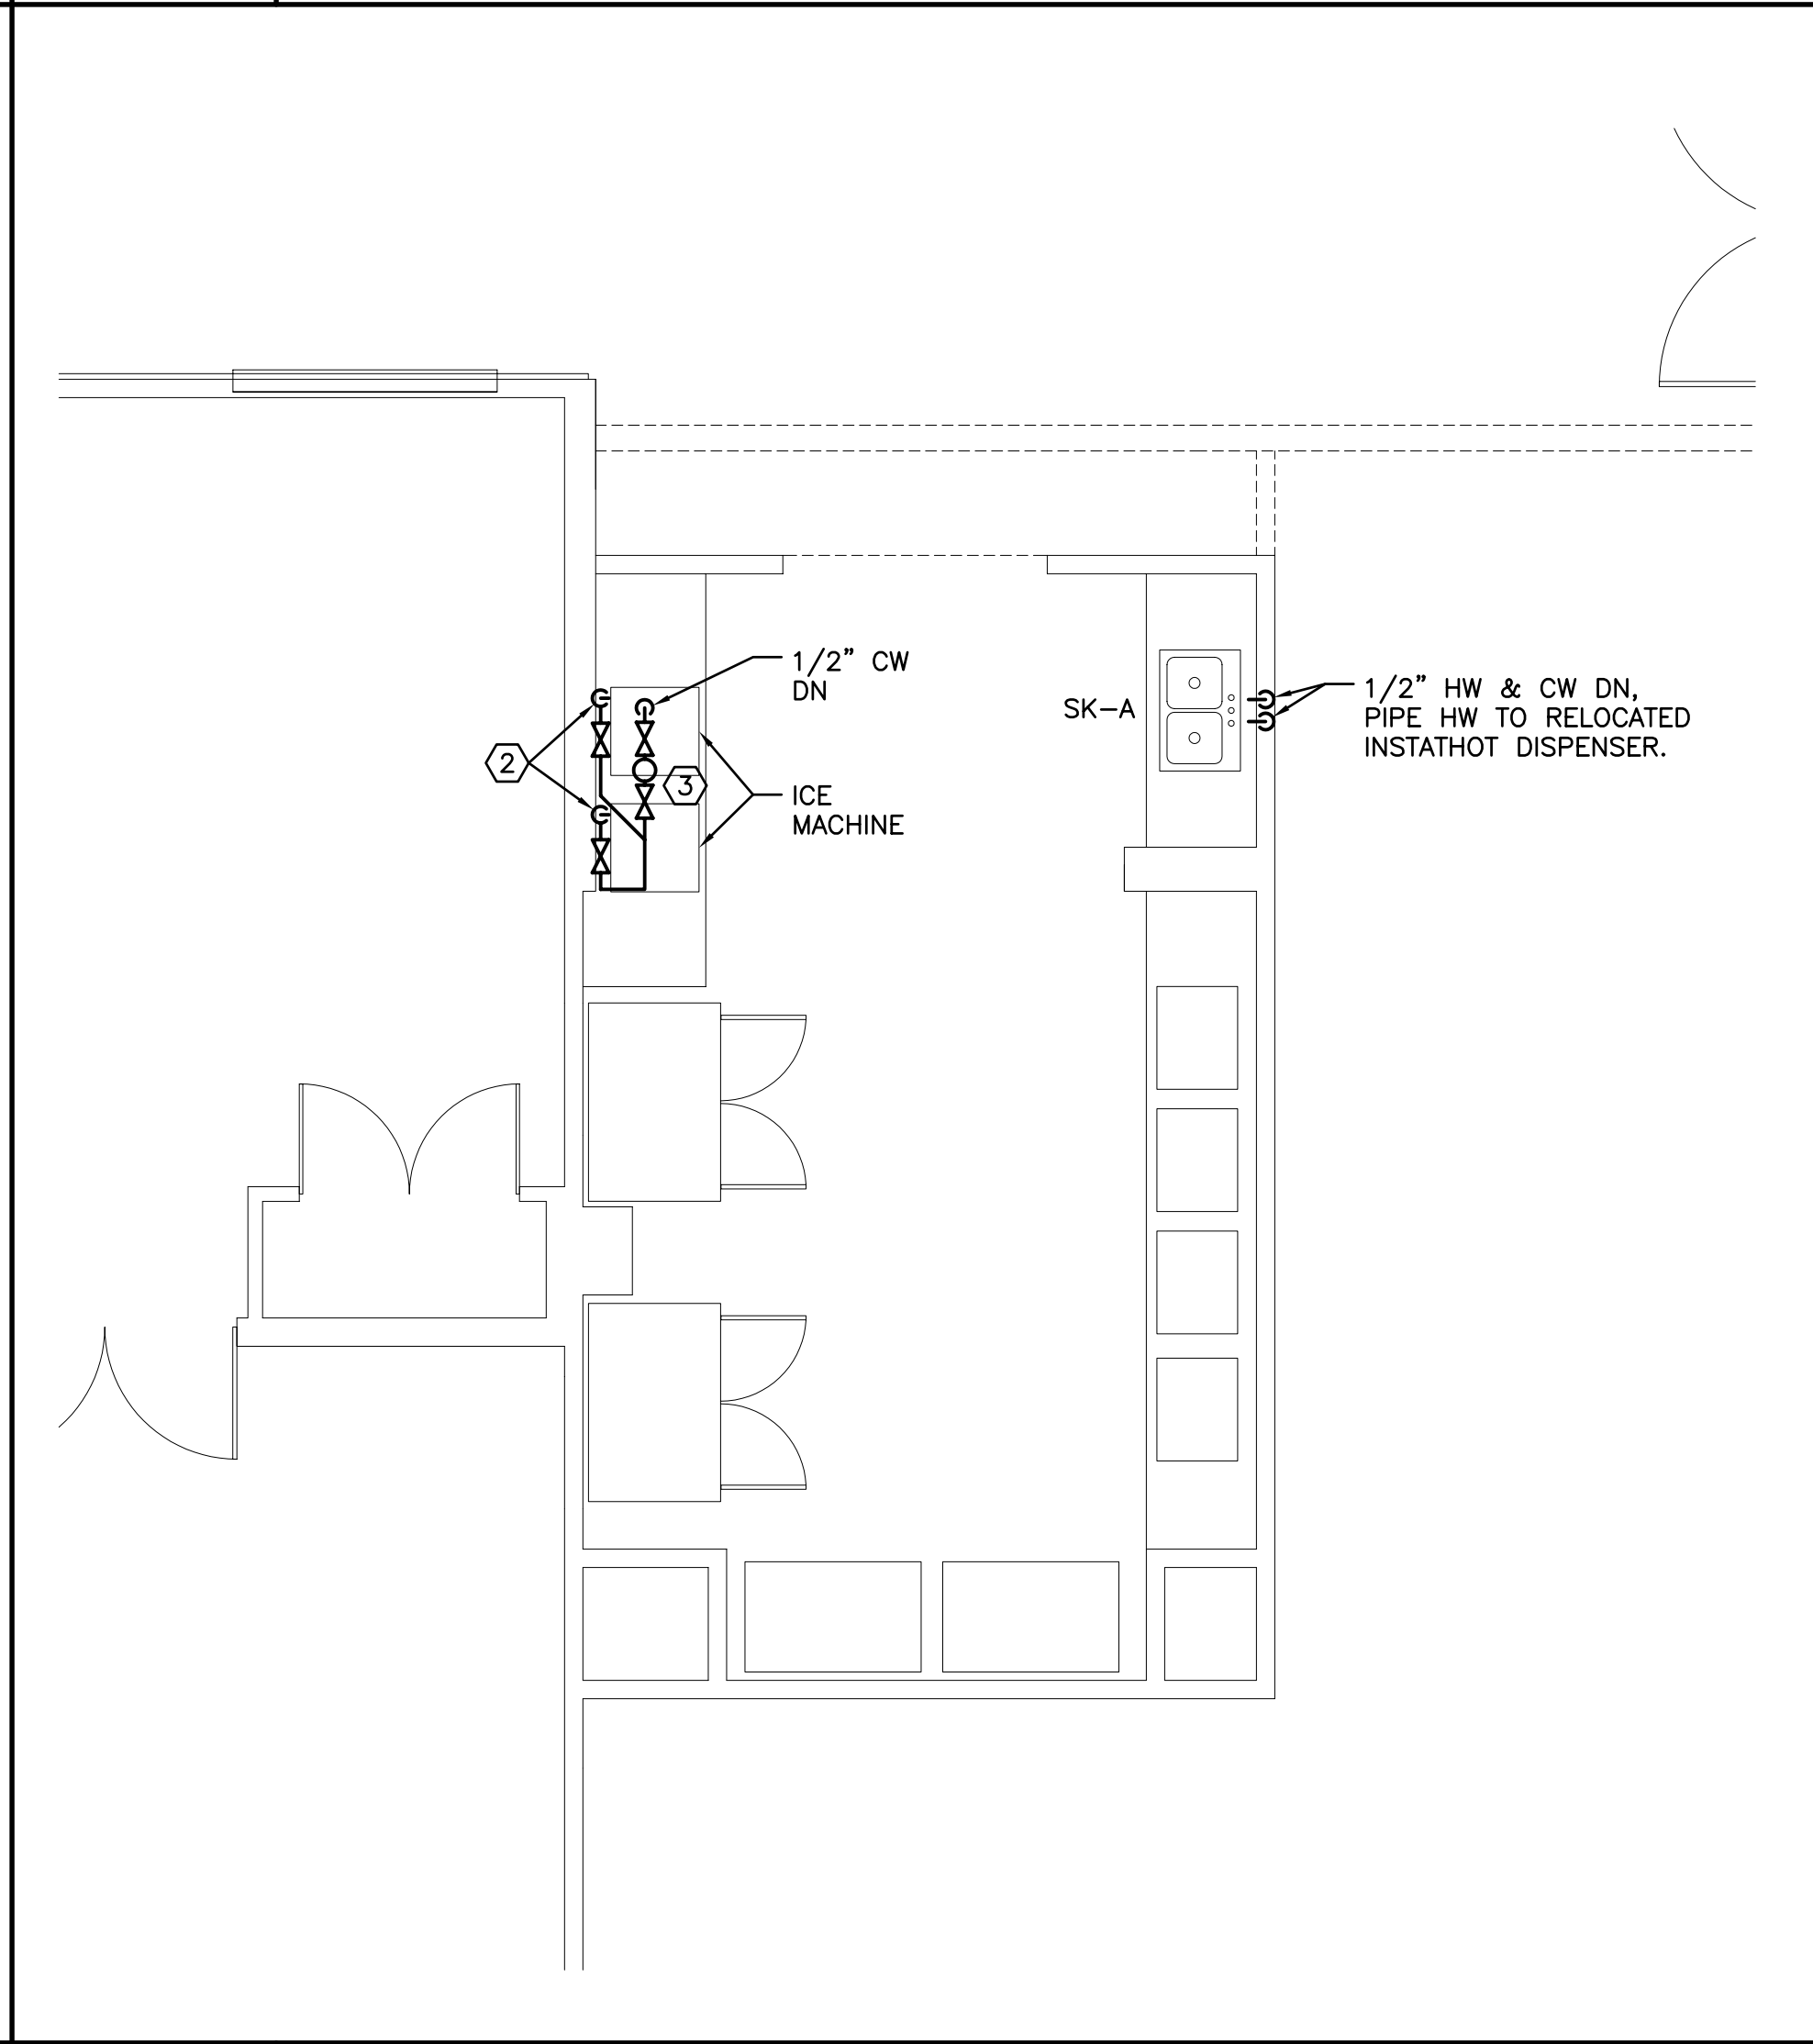


H1 DEMOLITION PLAN
1/8"=1'-0"

H7 GROUND LEVEL DEMOLITION PLAN
1/8"=1'-0"

H13 GROUND LEVEL SUPPLY PIPING PLAN
1/8"=1'-0"

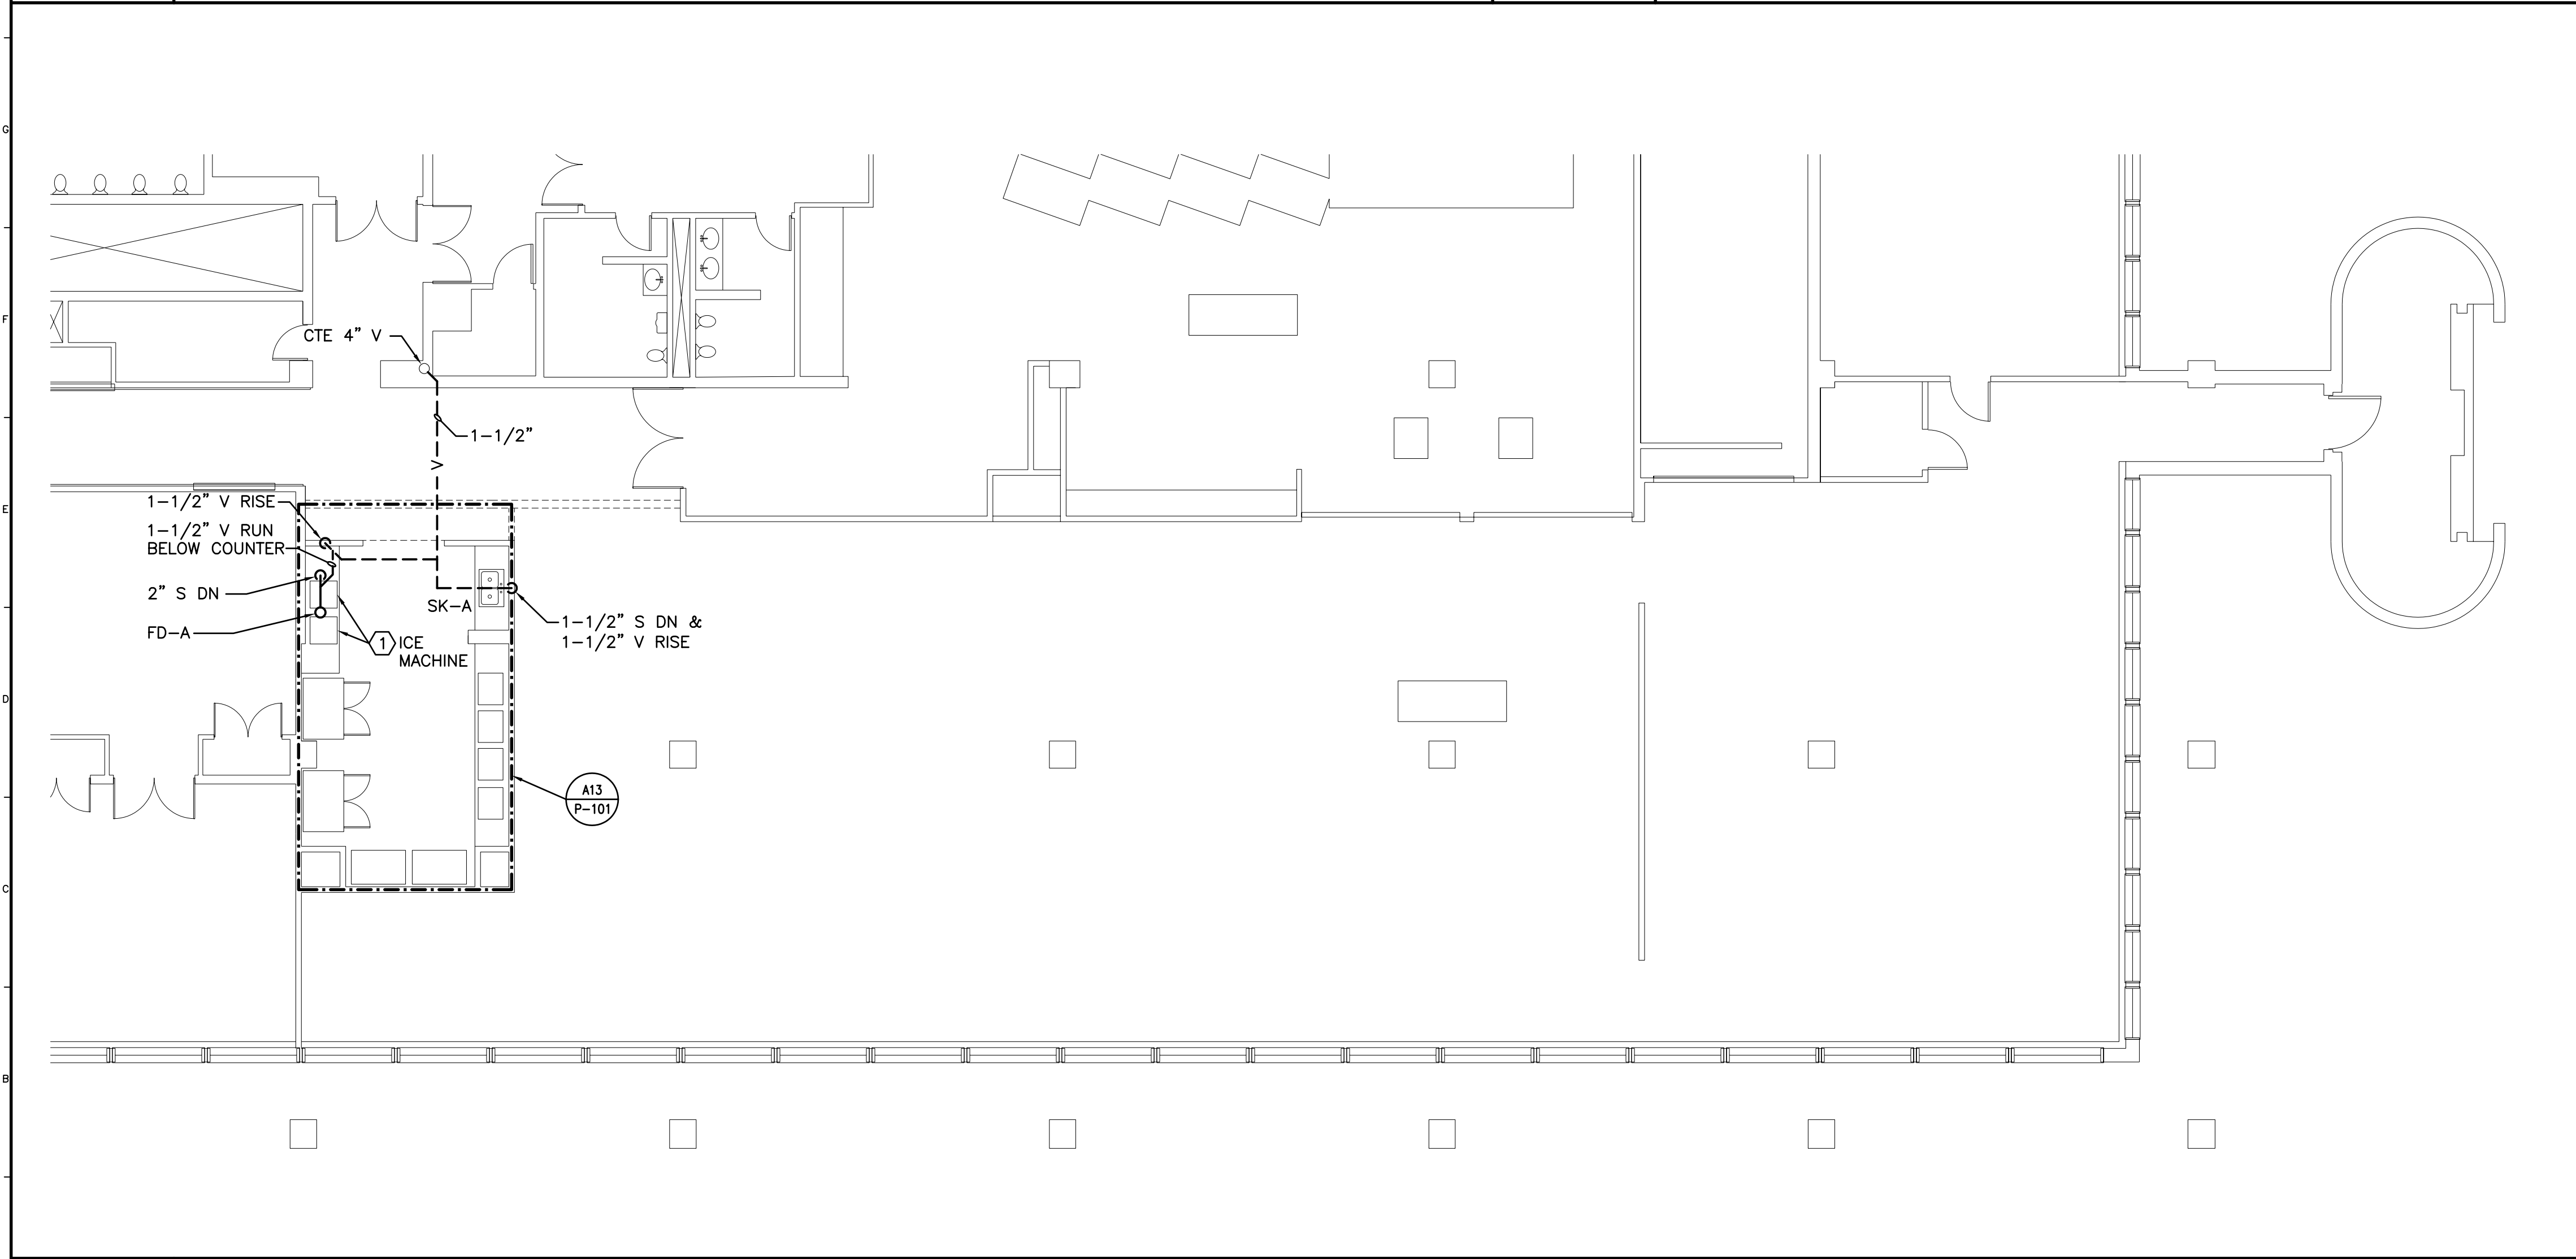

A1 DWV PIPING PLAN
1/8"=1'-0"

A13 SUPPLY PIPING PLAN
1/4"=1'-0"

- NOTES:**
- SEE SHEET M-001 FOR LEGEND AND ABBREVIATIONS.
 - CHECK EXISTING DUCTWORK WITH NEW DUCTWORK PLAN AND ELIMINATE ANY REDUNDANT BALANCING DAMPERS.
- KEYED NOTES:**
- PIPE 3/4" INDIRECT WASTE FROM EACH ICE MACHINE TO FUNNEL DRAIN, FD-A.
 - 1/2" CW W/ SHUT-OFF VALVE BELOW COUNTER, CONNECT TO ICE MACHINE (TYP. 2).
 - RELOCATED WATER FILTER BELOW COUNTER. PROVIDE NEW CARTRIDGE. INSTALL SHUT-OFF VALVES.

0	ISSUED FOR CONSTRUCTION	6-2-03
REV.	DESCRIPTION	DATE

ISSUED FOR CONSTRUCTION
6-2-03

CURRENT ISSUE STATUS:

--	--	--

SM RT ARCHITECTURE ENGINEERING PLANNING
SMRT
144 Fore Street/P.O. Box 618
Portland, Maine 04104
tel. (207) 773-3846
fax. (207) 772-1070

UNUMPROVIDENT H01
THE BEACON
PORTLAND, ME.

PROJECT: **PLUMBING PLANS**

SHEET TITLE:	AS NOTED	DATE:	6-2-03
SCALE:	JLH	GRAPHIC SCALE:	0" = 1'
PROJECT MANAGER:	RJL/BGG	SHEET No.	P-101
JOB CAP/DRAWN:	LPA	PROJECT No.	02140
A/E OF RECORD:	P-101-02140		
SMRT CAD FILE:	02140		