

GENERAL CEILING NOTES:

1. CEILING PLANS DO NOT SHOW EVERY FIXTURE OR COMPONENT. REFER TO ELECTRICAL, PLUMBING, MECHANICAL AND STRUCTURAL DRAWINGS FOR EXTENT OF ALL CEILING PENETRATIONS AND INSTALLATIONS AND COORDINATE PRIOR TO INSTALLATION.
2. SEE MECH. DRAWINGS FOR RETURNS AND DIFFUSER LOCATIONS AND SIZES. SHOWN HERE FOR REFERENCE ONLY.
3. SEE ELECT. DRAWINGS FOR LIGHT TYPES AND ADDITIONAL INFORMATION.
4. ALLOW FOR 15% OF INTENDED CEILING TILE REUSE / REINSTALLATION TO BE REPLACED.

CEILING TYPES:

C1 2X4' ACOUSTICAL CEILING TILE
 C2 2X2' ACOUSTICAL CEILING TILE
 GWB GWB SOFFIT OR CEILING
 EXP EXPOSED STRUCTURE




CEILING FIXTURES LEGEND:

- NEW OR RELOCATED LIGHT (SEE ELECTRICAL)
- RELOCATED RECESSED LINEAR LIGHT (SEE ELECTRICAL)
- RELOCATED DIRECT / INDIRECT (SEE ELECTRICAL)
- NEW OR RELOCATED RECESSED CAN (SEE ELECTRICAL)
- NEW OR RELOCATED DIFFUSER (SEE MECHANICAL)
- CEILING MOUNTED SECURITY CAMERA - SEE ELECTRICAL DRAWINGS FOR TYPE AND POSITION
- NEW OR RELOCATED SPEAKER
- NEW OR RELOCATED SMOKE DETECTOR
- MIRROR (REINSTALLED)
- OCCUPANCY SENSOR
- CEILING MOUNTED STROBE/HORN


NOTE: SEE ELECTRICAL DRAWINGS FOR NEW EXIST SIGN LOCATIONS

EXISTING CEILING TYPES:

XC1 EXISTING 2X2' CEILING TILE
 XC2 EXISTING 2X4' CEILING TILE
 XGWB EXISTING GWB SOFFIT OR CEILING
 EXP EXPOSED STRUCTURE

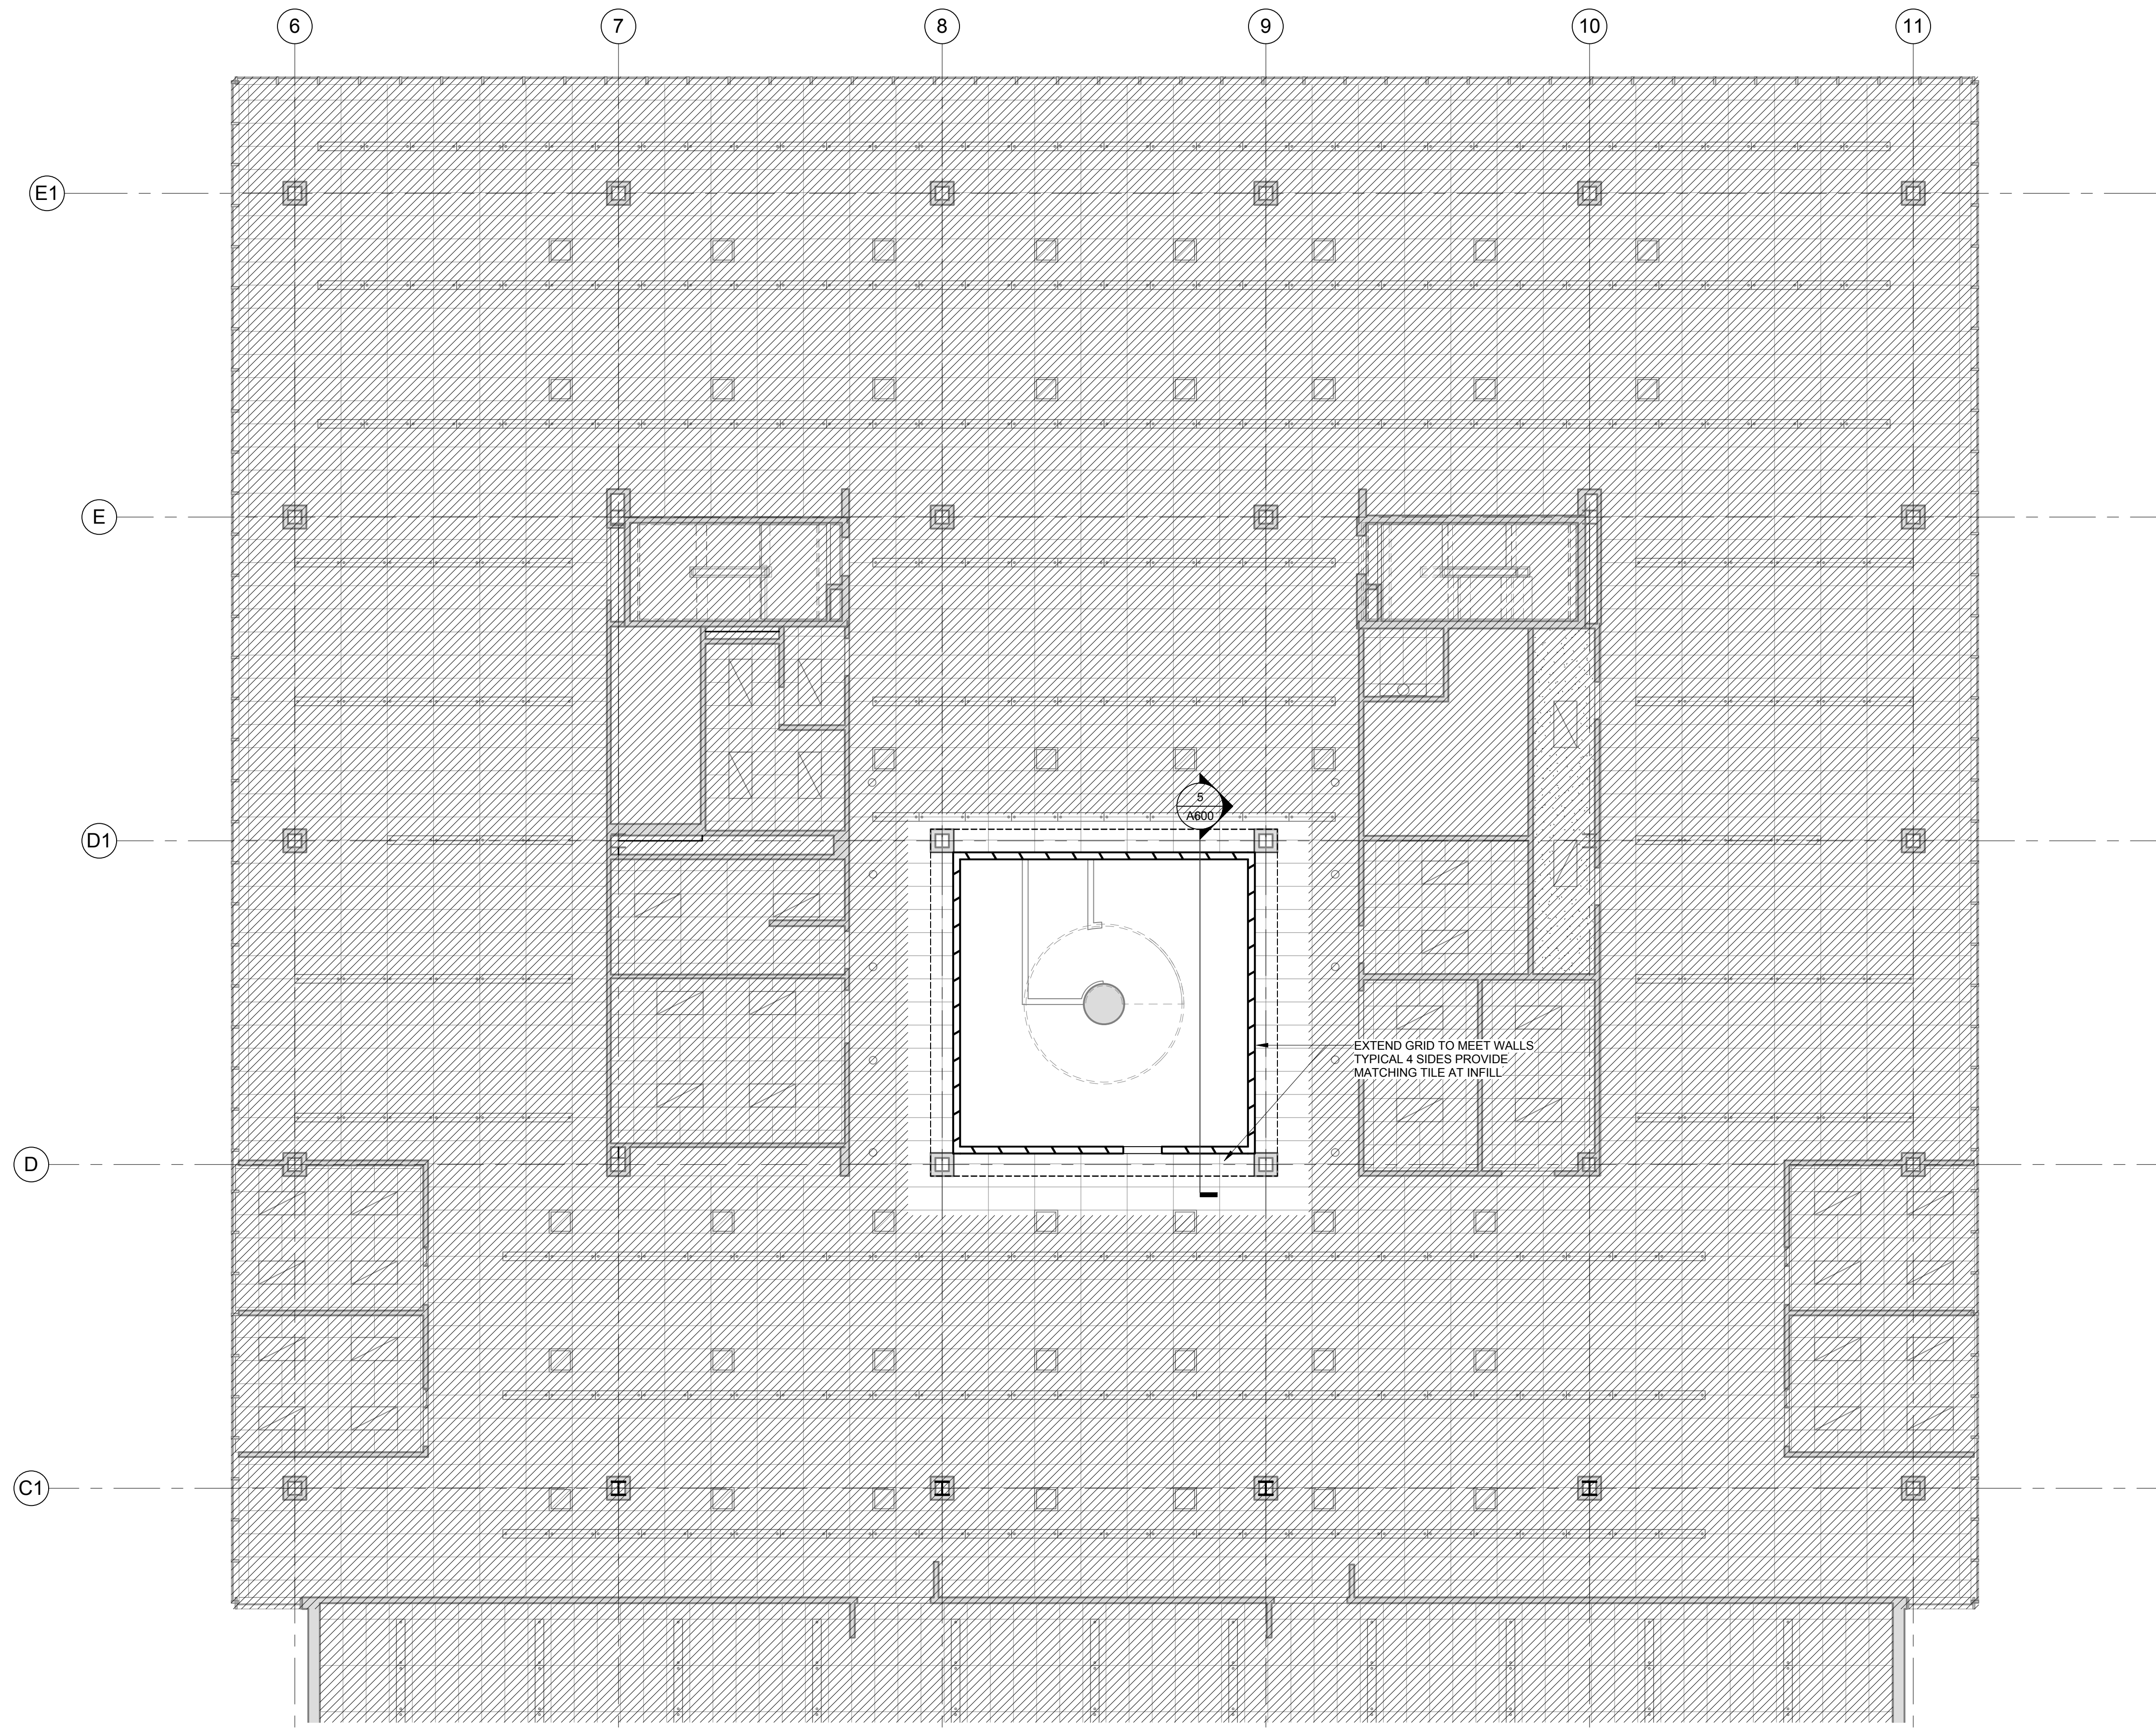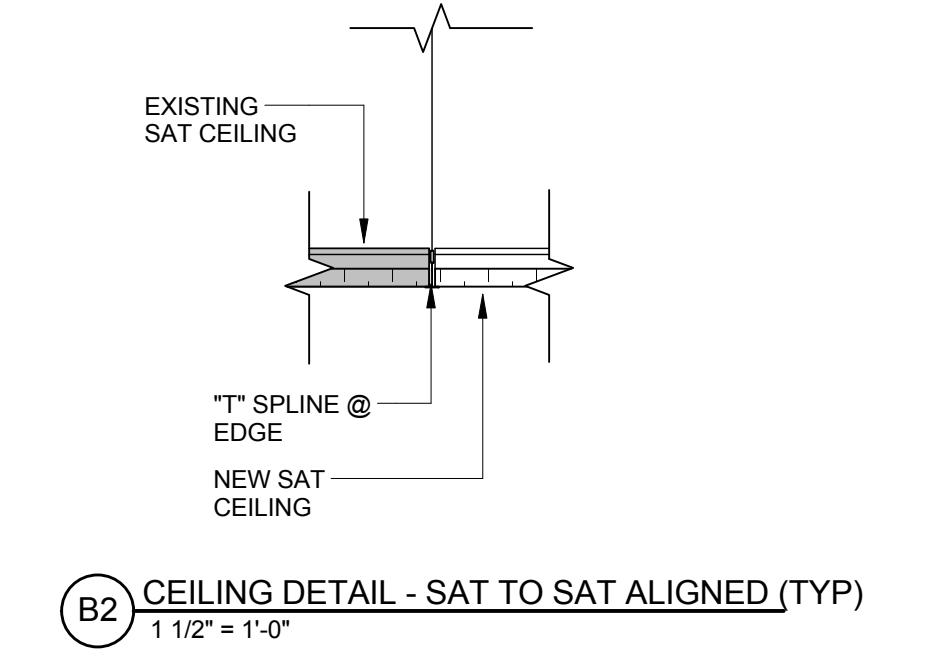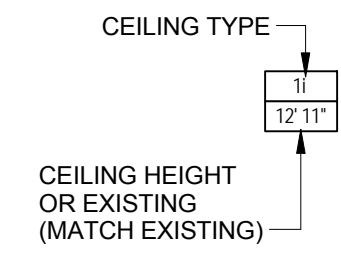

1 SECOND FL. - REFLECTED CEILING PLAN
 1/8" = 1'-0"

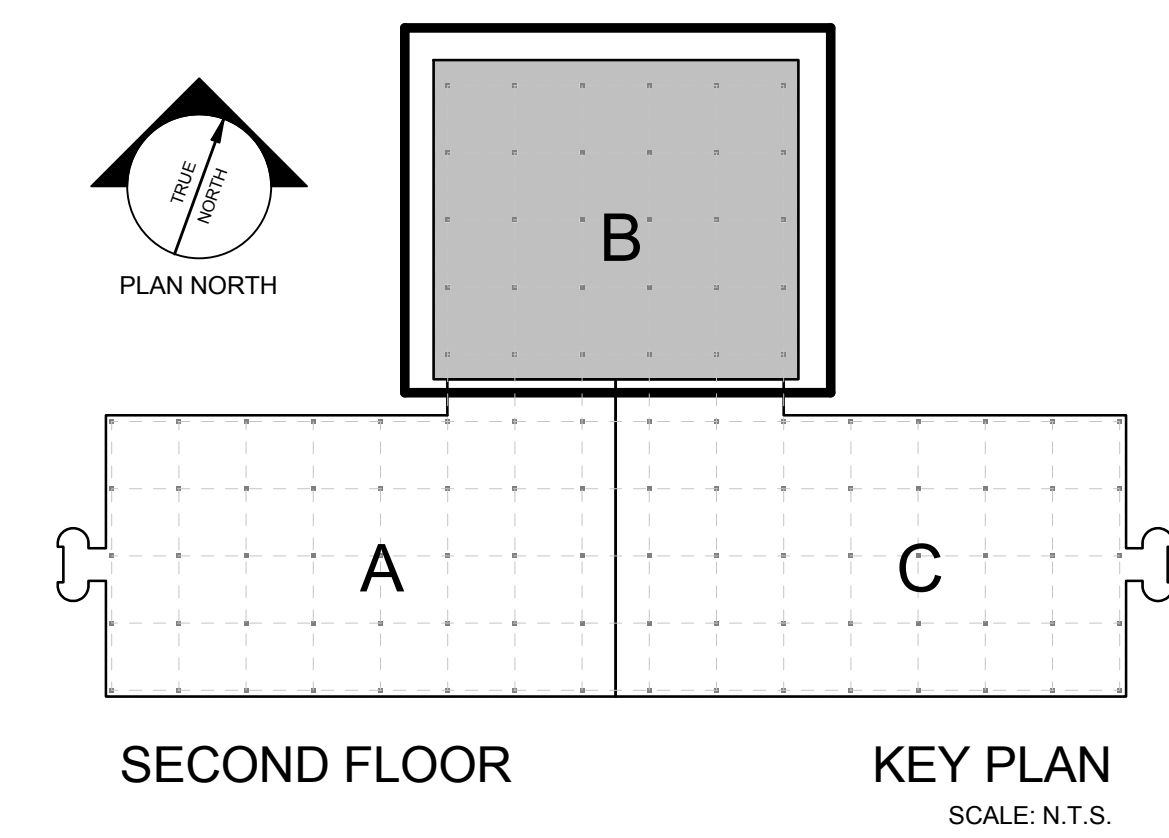


Allied Project No: 14072
 CAD file: 14072M.DWG

COPYRIGHT 2016 PDT Architects
 Reuse or reproduction of the contents of this document is not permitted without written permission of PDT Architects.

2016 UNUM - HO1 3RD FLOOR FIT UP (NORTH WING)
 2211 CONGRESS STREET, PORTLAND, MAINE 04112

No.	Date	Description

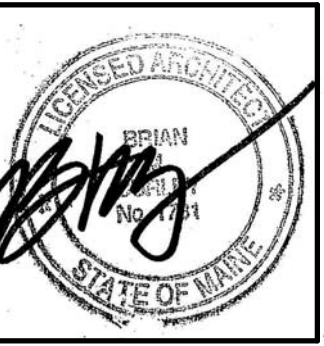

JOB NO. 14-074

DRWN: SMD CHK: CDR

SCALE: As indicated

ISSUE: 12 FEB 2016 PERMIT SET

TITLE: 2ND FLR. REFLECTED CEILING PLAN

SHEET: A112