




**03 ENLARGED PLAN - CENTRAL EXISTING RESTROOM 1104 & 1106**  
SCALE: 3/8" = 1'-0"

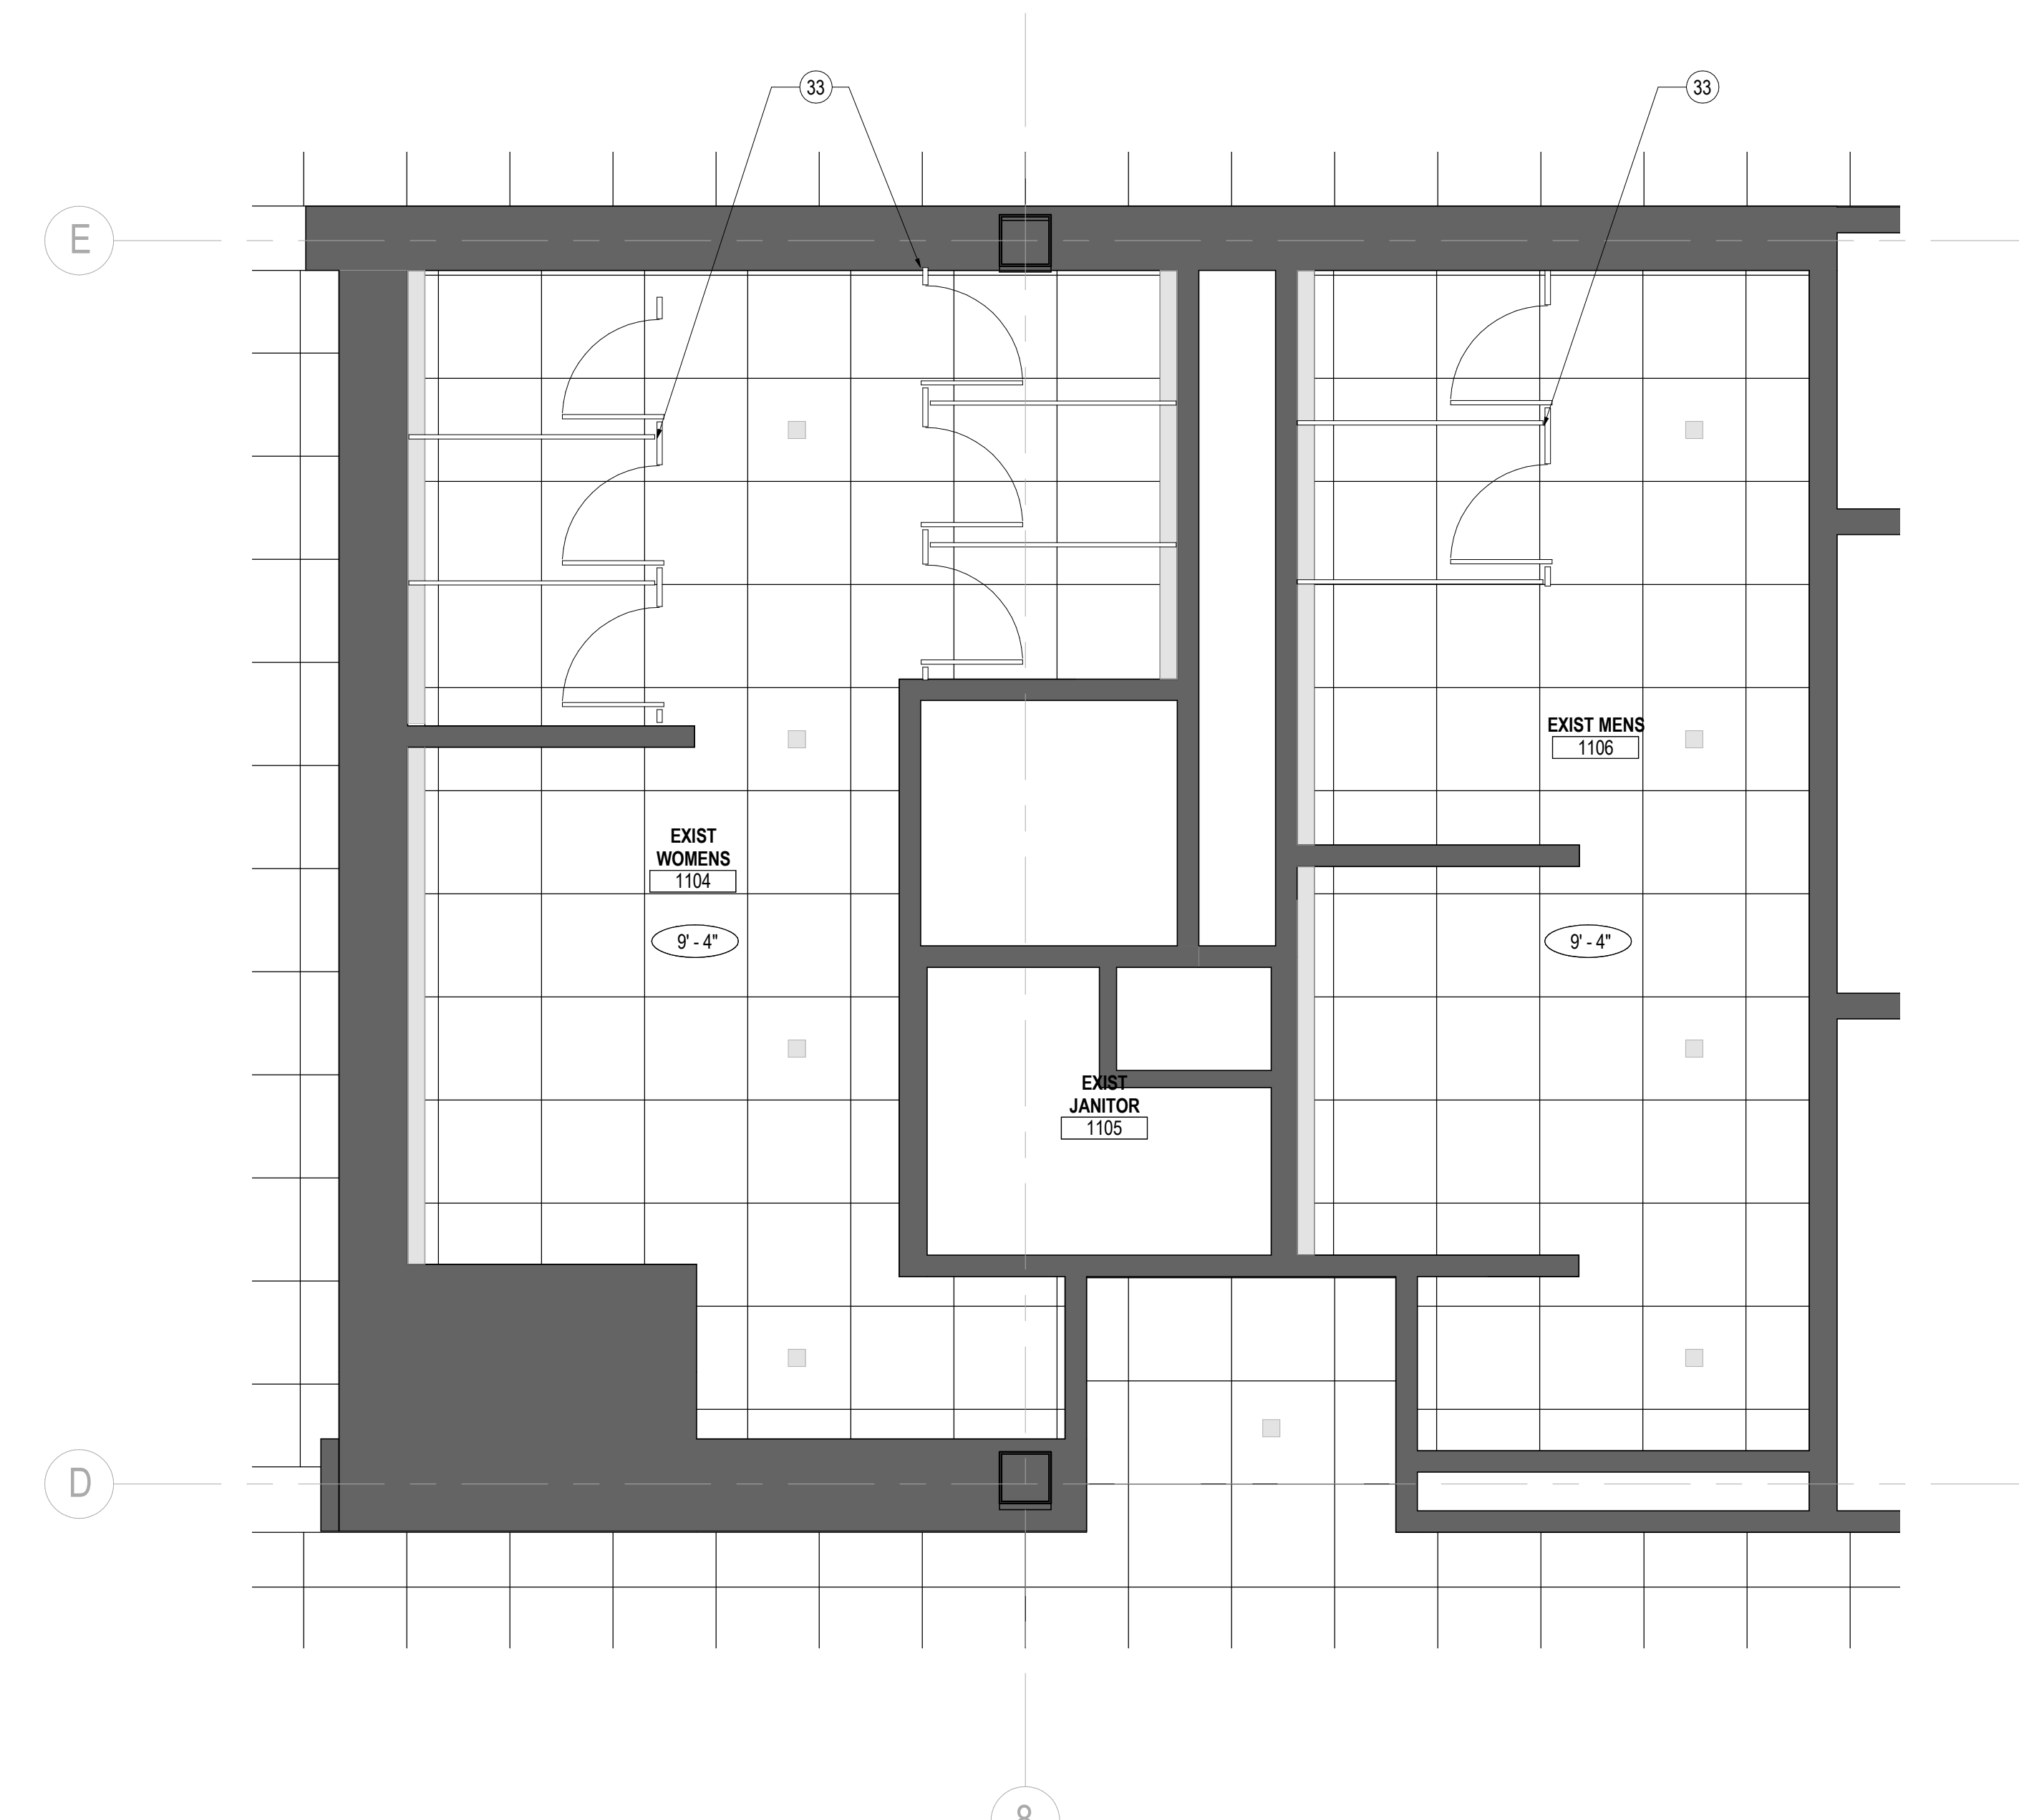

**01 ENLARGED RCP - CENTRAL EXISTING RESTROOM 1104 & 1106**  
SCALE: 3/8" = 1'-0"

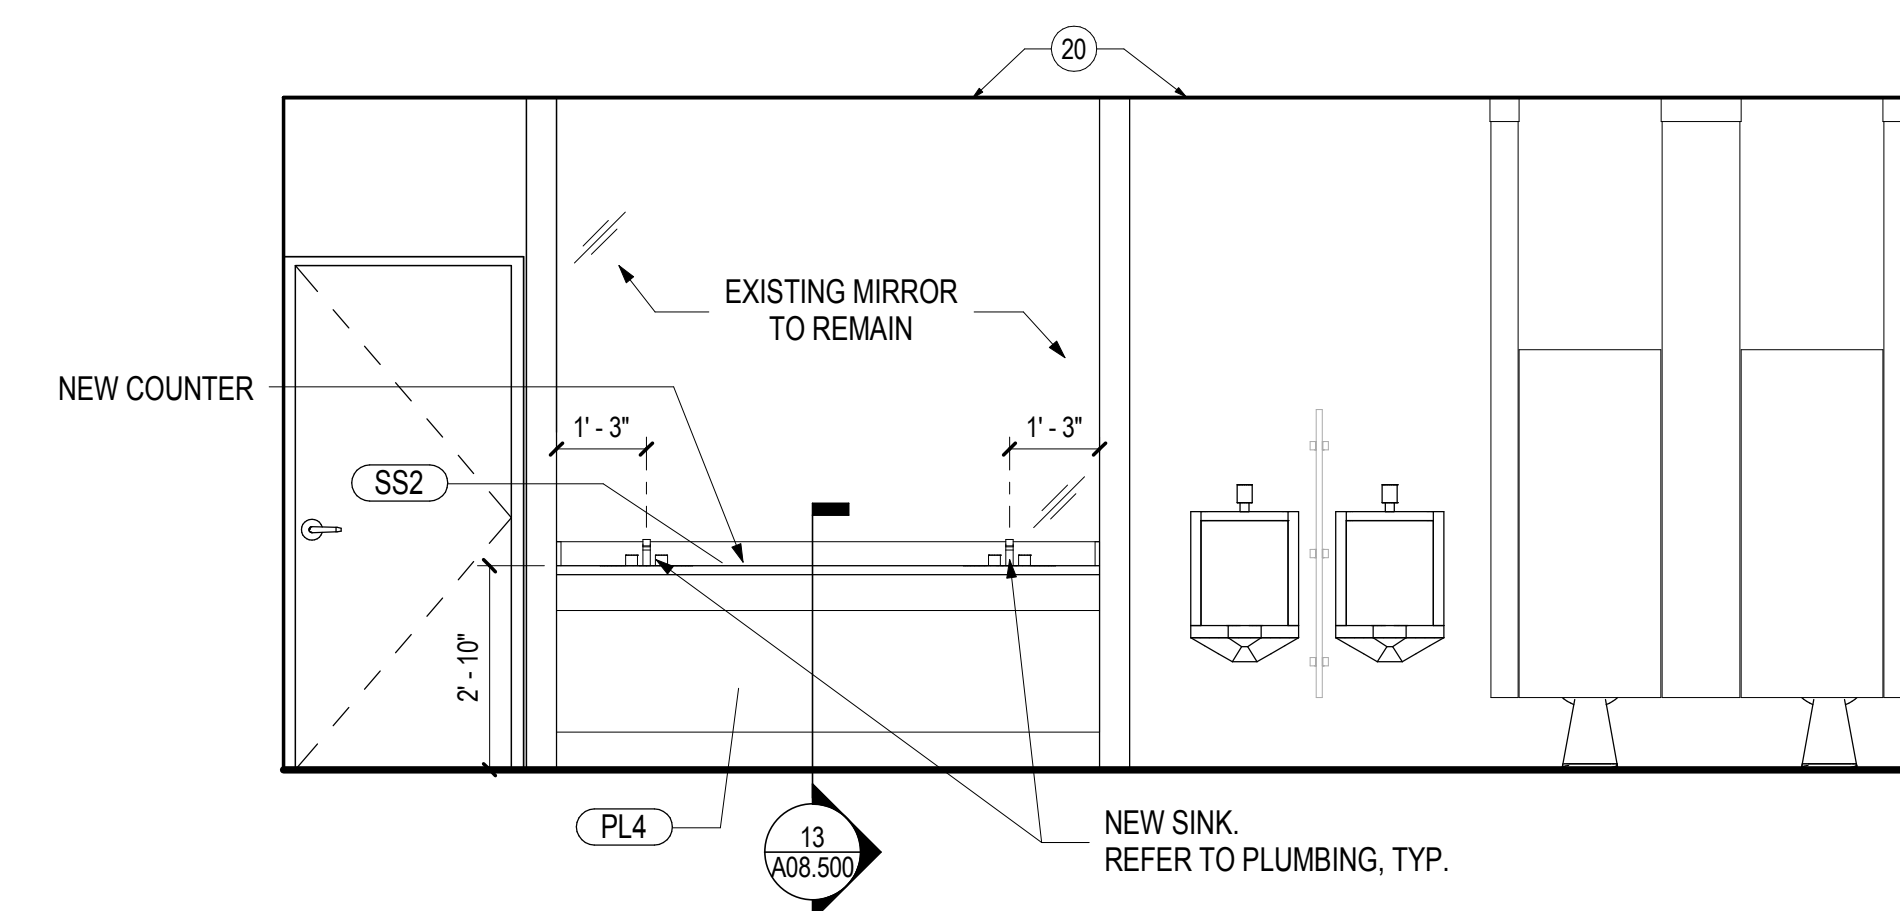

**04 1106 & 2106 EXISTING MENS - EAST ELEVATION**  
SCALE: 3/8" = 1'-0"

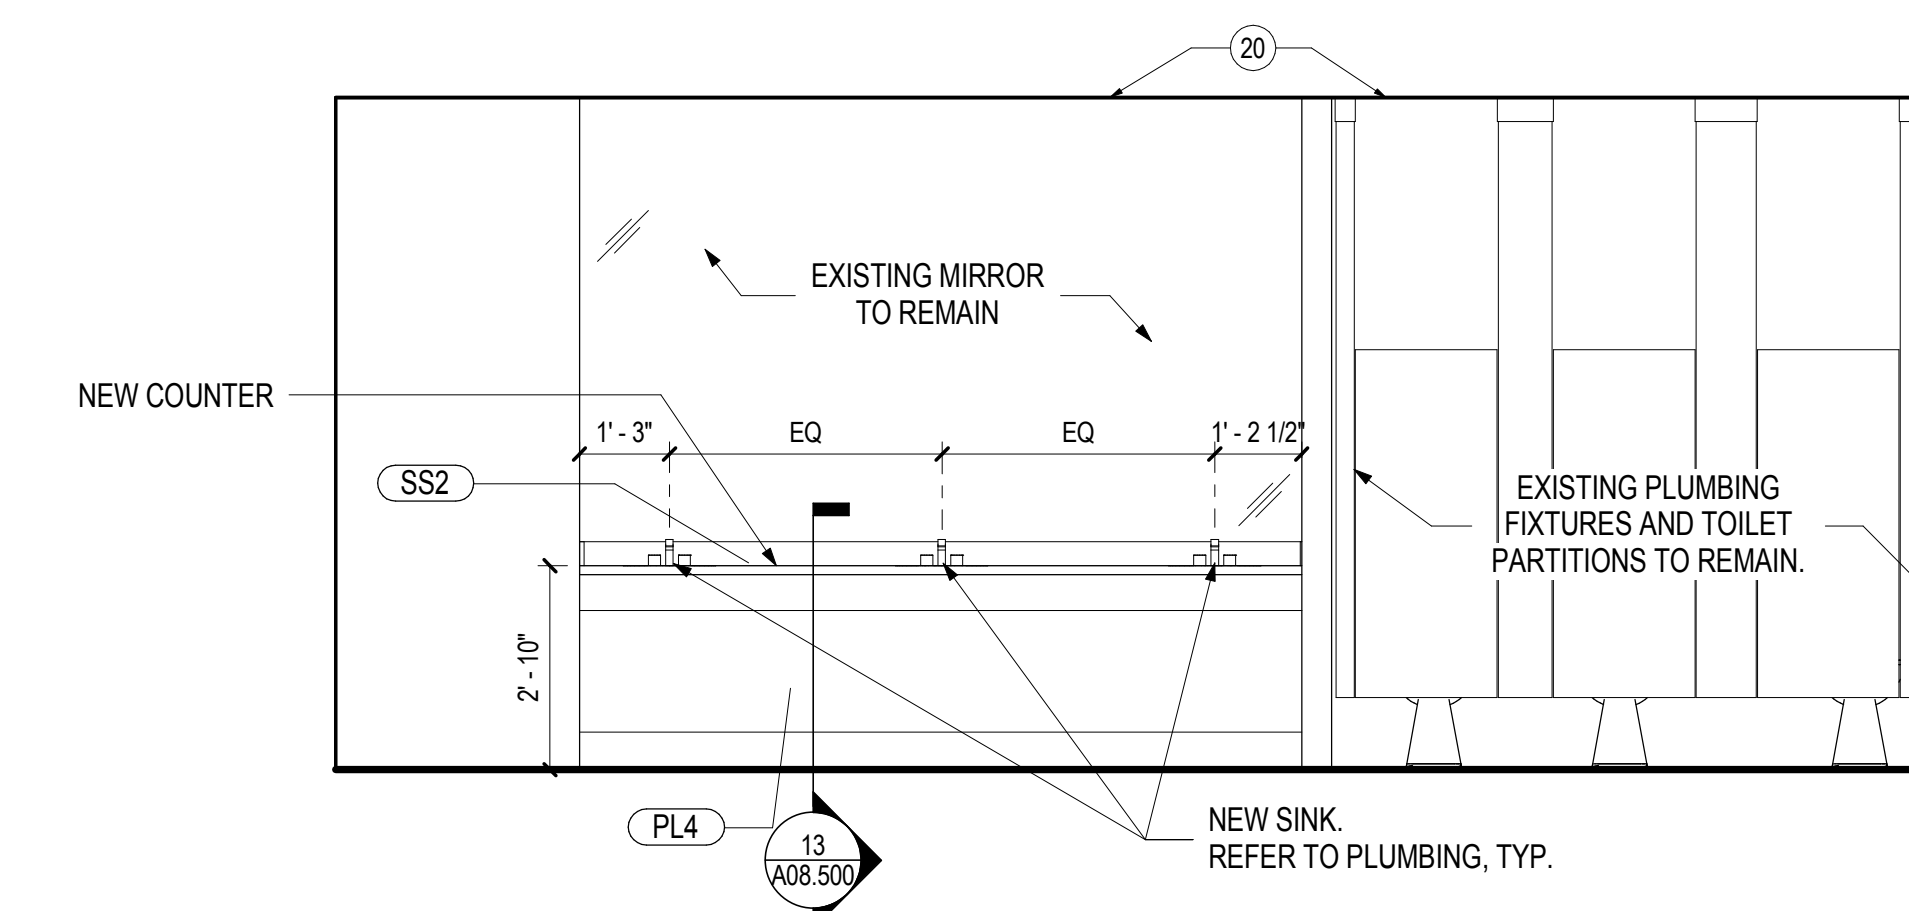

**02 1104 & 2104 EXISTING WOMENS - EAST ELEVATION**  
SCALE: 3/8" = 1'-0"

**SHEET NOTES**

- 20 LIGHT FIXTURE. REFER TO ELECTRICAL DRAWINGS, TYP. CONFIRM BOTTOM OF HEIGHT FIXTURE WITH ARCHITECT PRIOR TO INSTALLATION, TYP.
- 32 EXISTING PLUMBING FIXTURE TO REMAIN U.O.N.
- 33 NEW CEILING HUNG TOILET PARTITIONS
- 35 RECESSED DRINKING FOUNTAIN TO REMAIN


**GENERAL NOTES**

- A. REFER TO SHEETS SERIES A02.100, A02.200 AND I02.100 FOR CONSTRUCTION, REFLECTED CEILING AND FINISH PLAN GENERAL NOTES.
- B. REFER TO FINISH PLAN FOR WALL BASE AS SCHEDULED, TYPICAL.

**KEY PLAN**

Date	Description
08/18/17	ISSUE FOR PERMIT & CONSTRUCTION

Seal / Signature

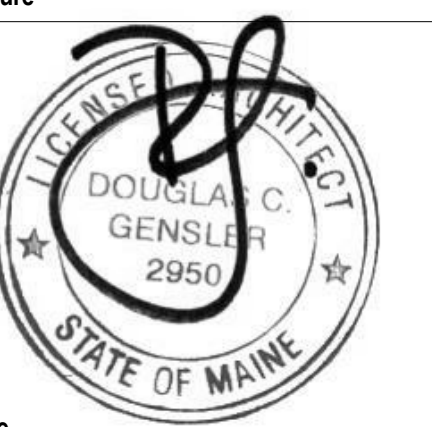

Project Name

Unum Workplace Transformation- Phase 1 (HO2)

Project Number

59.6481.003

Description

ALTERNATE #1 - ENLARGED PLANS - EXISTING RESTROOMS LEVEL 02

Scale

3/8" = 1'-0"

**A03.302**