




04 WATER DESK
SCALE: 3/8" = 1'-0"

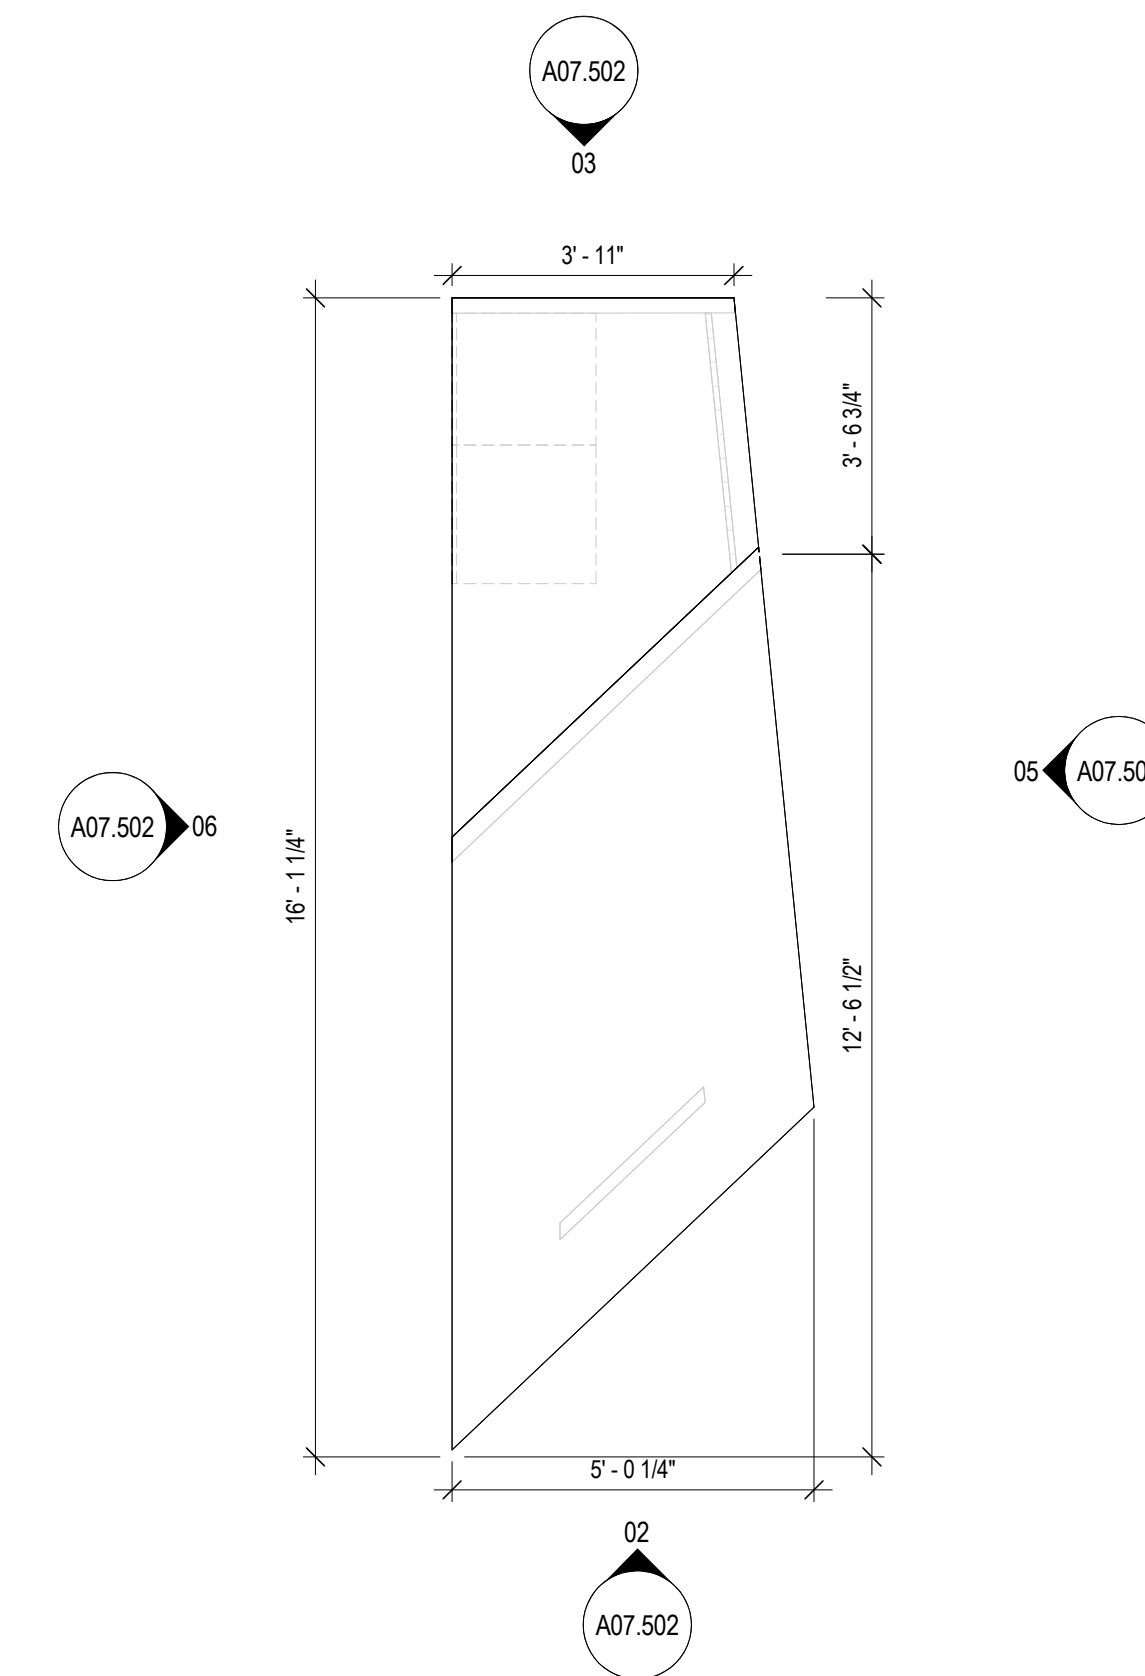


01 ENLARGED PLAN - LEVEL 01 - WATER STATION
SCALE: 3/8" = 1'-0"

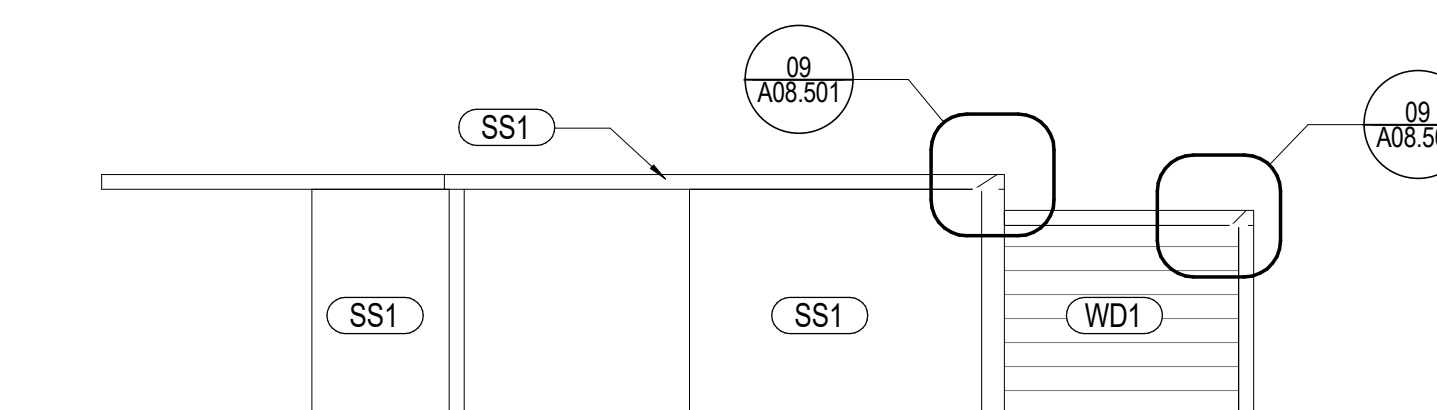


05 ANGLED DESK - WEST ELEVATION
SCALE: 3/8" = 1'-0"

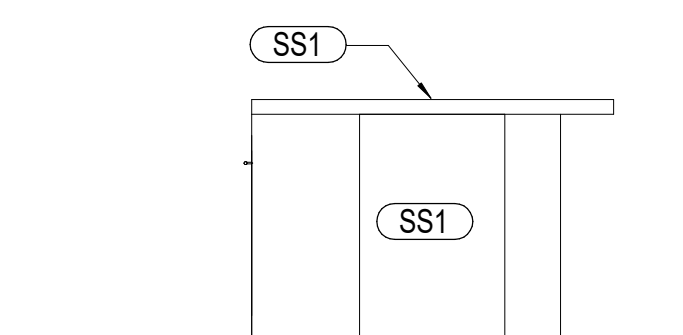

02 ANGLED DESK - NORTH ELEVATION
SCALE: 3/8" = 1'-0"

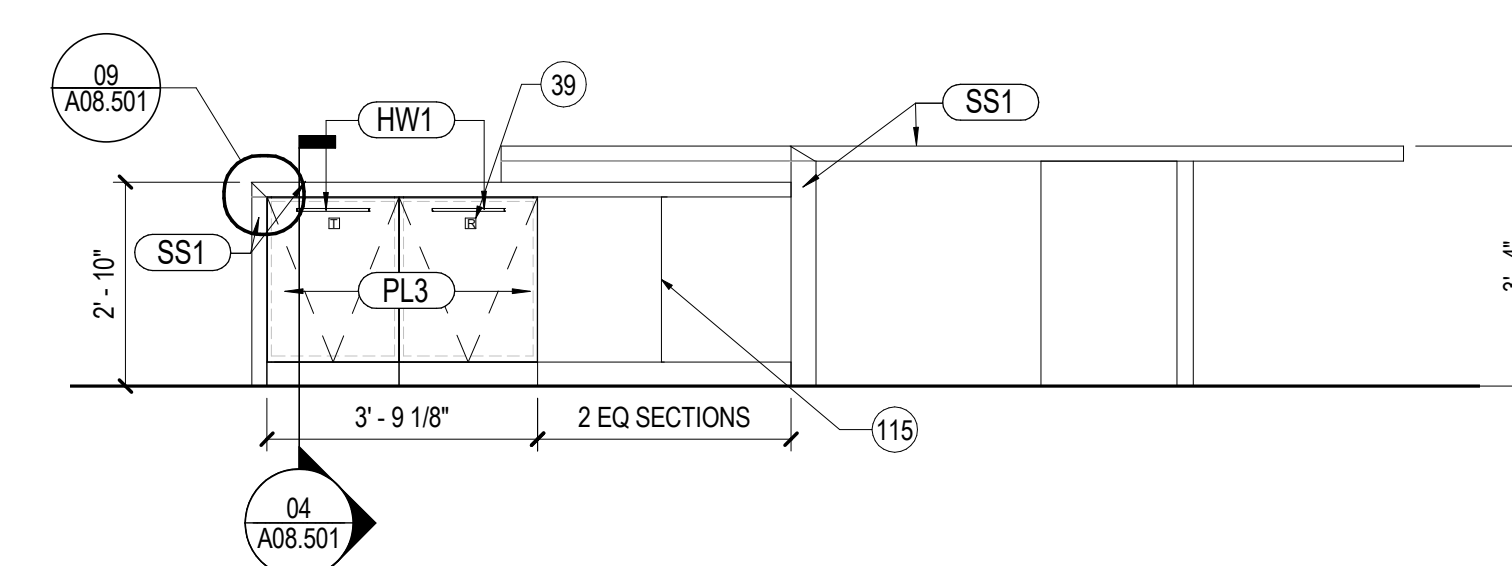

06 ANGLED DESK - EAST ELEVATION
SCALE: 3/8" = 1'-0"

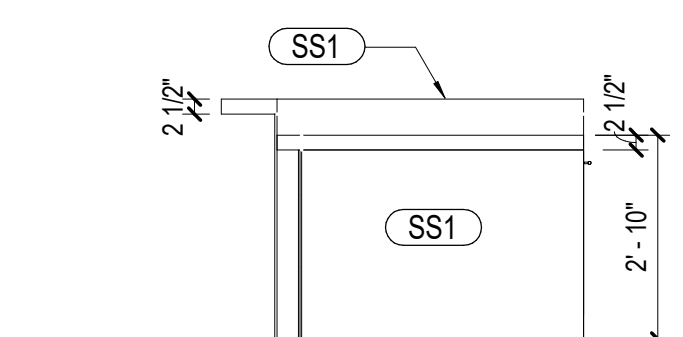

03 ANGLED DESK - SOUTH ELEVATION
SCALE: 3/8" = 1'-0"

SHEET NOTES

- 39 TRASH PULL CABINET WITH COYLE AND COMPANY ALUMINUM 1 3/4" X 1 3/4" SIGNAGE; DE-F 0 TRASH ID. SIGNAGE PLACED ABOVE CABINET HARDWARE. GC TO SUBMIT SIGNAGE PRODUCT DATA SUBMITTAL BEFORE ORDERING.
- 115 FALSE PANEL


GENERAL NOTES

- A. REFER TO SHEETS SERIES A02.100, A02.200 AND I02.100 FOR CONSTRUCTION, REFLECTED CEILING AND FINISH PLAN GENERAL NOTES.
- B. REFER TO FINISH PLAN FOR WALL BASE AS SCHEDULED, TYPICAL.

KEY PLAN

Date	Description
12/15/17	ISSUE FOR PERMIT & CONSTRUCTION

Seal / Signature

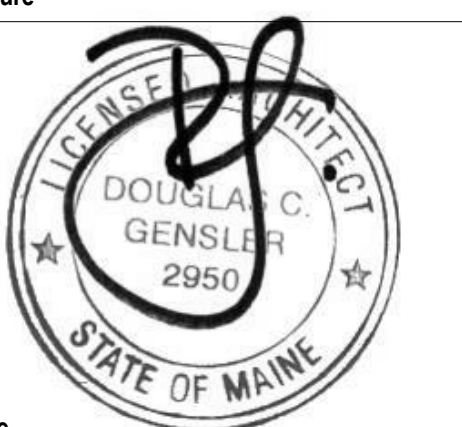

Project Name

Unum Workplace Transformation
- Phase 2 & 3 (HO2 & HO3)

Project Number

59.6481.003

Description

ENLARGED ELEVATIONS - LEVEL 01 -
WATER STATION

Scale

3/8" = 1'-0"

A07.502