


**GENERAL NOTES:**  
(APPLY THIS SHEET ONLY)

- COORDINATE ALL DEVICE LOCATIONS AND MOUNTING HEIGHTS WITH THE ARCHITECT & FURNITURE VENDOR PRIOR TO INSTALLATION.
- HATCHED AREA NOT IN THIS SCOPE OF WORK.
- 'E' DENOTES EXISTING DEVICE TO REMAIN. 'R' DENOTES EXISTING DEVICE TO BE RELOCATED. 'D' DENOTES EXISTING ITEM TO BE REMOVED.
- VERIFY PROPER FUNCTIONALITY OF ALL EXISTING AND RELOCATED FIRE ALARM DEVICES, INCLUDING THEIR HOUSING, LENSES, ETC... PROVIDE REPLACEMENTS AS REQUIRED IF ANY ARE NOT OPERATING AS INTENDED OR HAVE ABOVE NORMAL WEAR OR DEFECTS.
- ALL WIRING WITHIN AND THROUGH THE OPEN TO STRUCTURE AREAS SHALL BE IN EMT.

**LEGEND NOTES:**  
(APPLY TO THIS SHEET ONLY)


- ① EXISTING DEVICE TO BE RELOCATED INTO NEW CEILING. EXTEND ALL ASSOCIATED CONDUIT AND WIRING AS REQUIRED.

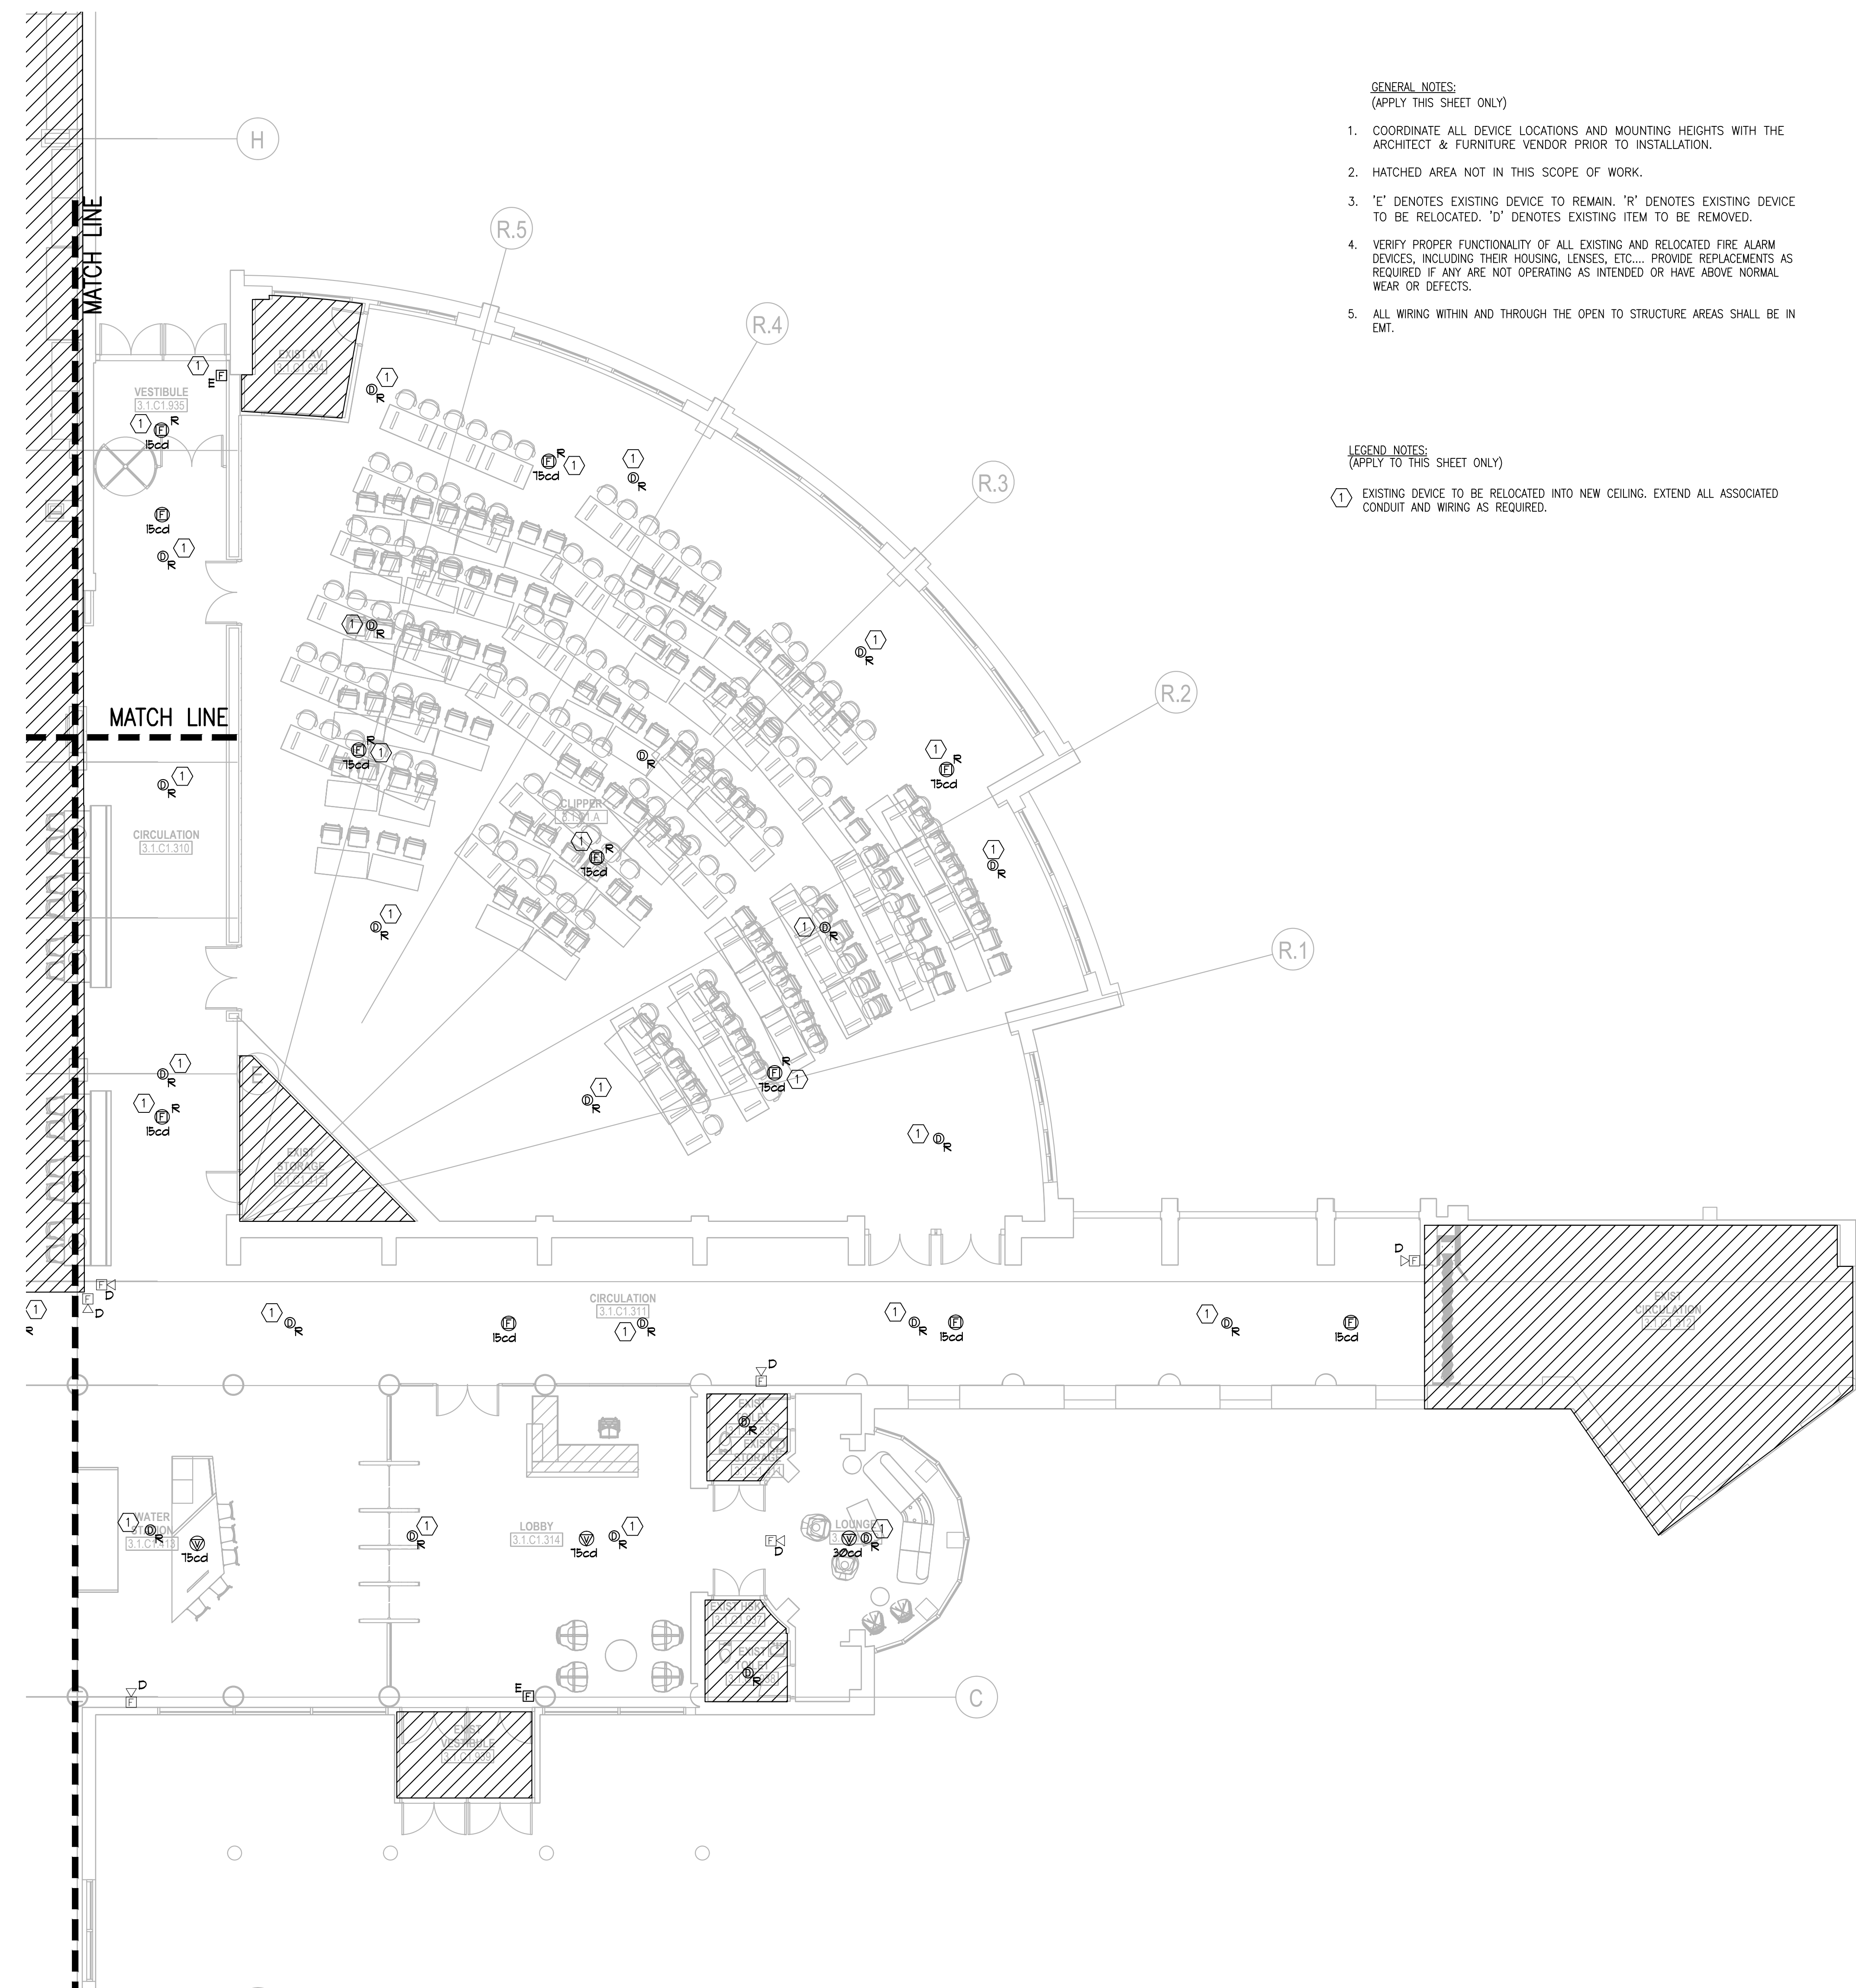

① 1ST FLOOR PLAN (AREA C1) - FIRE ALARM  
E2.301C.1 1/8"=1'-0"

Date	Description
12.15.2017	ISSUE FOR PERMIT AND CONSTRUCTION

Seal / Signature

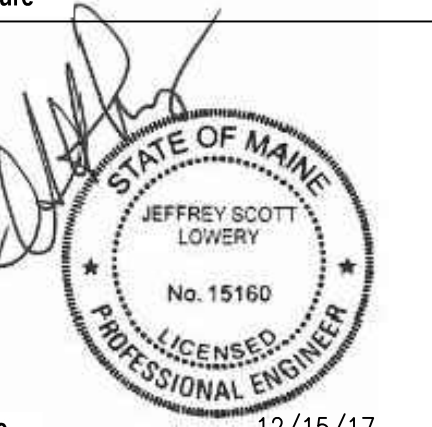

Project Name 12/15/17

Unum Workplace Transformation  
- Phase 2 & 3 (HO2 & HO3)

Project Number  
59.6481.003

Description  
1ST FLOOR PLAN (AREA C1) - H03 -  
FIRE ALARM

Scale  
1/8" = 1'-0"

**E2.301C.1**