


FILE PATH: C:\Users\sechpman\Box\Current Projects\147 002887501 - Unum HQ2 FA Device\Fire Alarm FA_102_103.dwg
 LAST PRINTED: 11/3/2017 12:40 PM
 LAST SAVED BY: SECHAPMAN
 3P 42' x 60' E Size

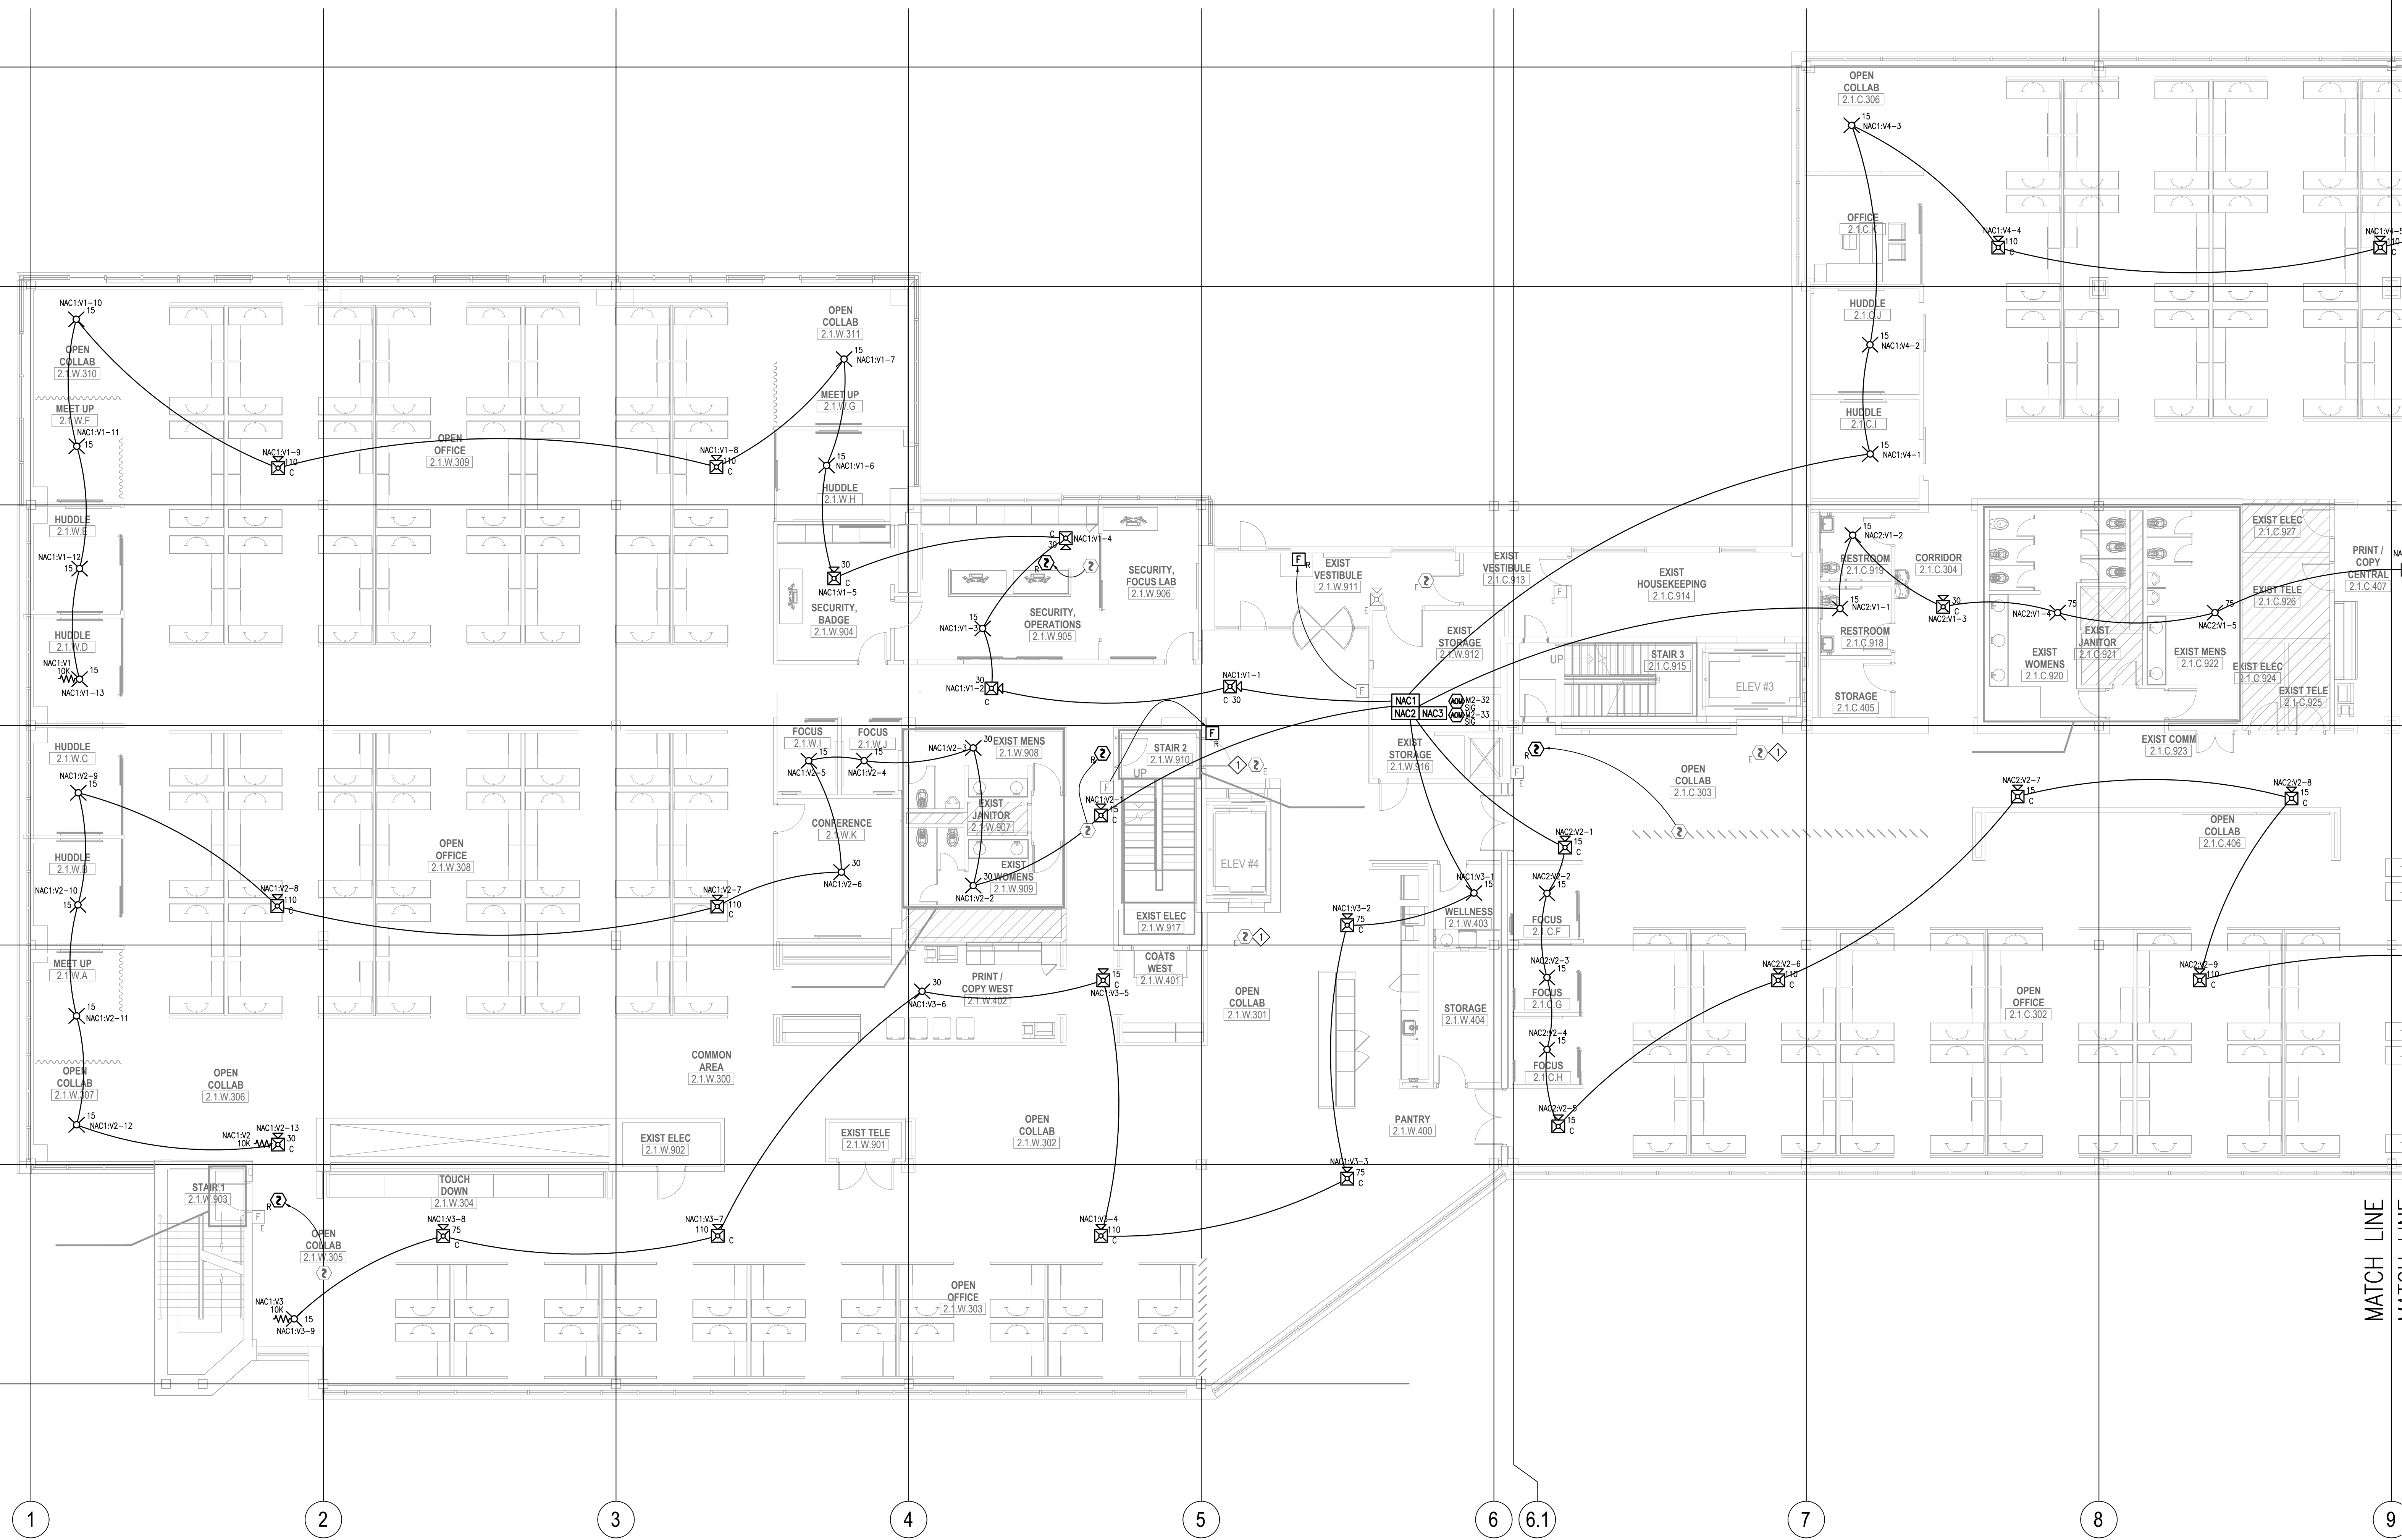

GENERAL NOTES:

- COORDINATE ALL DEVICE LOCATION AND MOUNTING HEIGHTS WITH THE ARCHITECT & FURNITURE VENDOR PRIOR TO INSTALLATION.
- HATCHED AREA NOT IN THIS SCOPE OF WORK.
- 'R' DENOTES EXISTING DEVICE TO REMAIN, 'R' DENOTES EXISTING DEVICES TO BE RELOCATED, 'R' DENOTES EXISTING ITEM TO BE REMOVED.
- VERIFY PROPER FUNCTIONALITY OF ALL EXISTING AND RELOCATED FIRE ALARM DEVICES, INCLUDING THEIR HOUSING, LENSES, ETC., OPERATING AS INTENDED OR HAVE ABOVE NORMAL WEAR OR DEFECTS.
- ALL WIRING WITHIN AND THROUGH THE OPEN TO STRUCTURE AREAS SHALL BE IN EMT.

KEYNOTES:

- EXISTING DEVICE TO BE RELOCATED INTO NEW CEILING. EXTEND ALL ASSOCIATED CONDUIT AND WIRING AS REQUIRED.

PLAN NORTH
FIRST FLOOR DEVICE PLACEMENT PLAN—WEST
 SCALE: 1/8" = 1'-0"
 0 4 8 16
 (IN FEET)

tyco
 SimplexGrinnell
 Safer. Smarter. Tyco.[™]
 DISTRICT - 147
 30 THOMAS DRIVE
 SERVICE CENTER
 PORTLAND, ME 04106
 PHONE: 207-866-8400
 FAX: 207-866-8409

unum

UNUM WORKPLACE TRANSFORMATION - H02
 UNUM HQ2
 2211 CONGRESS ST, MAIL STOP B146
 PORTLAND, ME 04102-1941

ISSUE NO.	DATE	BY	CHK	DESCRIPTION

DRAWN BY: PRANESH
 CHECKED BY: AO
 ISSUE DATE: 11/3/17
 JOB #: 002887501
 PROJECT #: 147
 SIMPLEXGRINNELL © 2017
 SYSTEM:
 FIRE ALARM SYSTEM
 SHEET:
 FIRST FLOOR DEVICE
 PLACEMENT PLAN—WEST

FA-102

This document is the property of Tyco Fire Protection Products, Inc. and is intended for use only for the project and location specified. It is not to be reproduced, stored in a retrieval system, or transmitted in any form or by any means, electronic, mechanical, photocopying, recording, or by any information storage and retrieval system, without the prior written permission of Tyco Fire Protection Products, Inc.