


NOTE: PAINT CONGRESS STREET FACE OF DUCTWORK ADJACENT TO THE EXTERIOR WALL FLAT BLACK TO REDUCE ITS VISIBILITY FROM CONGRESS STREET. SEE MECHANICAL DRAWINGS FOR LOCATIONS OF DUCTWORK.

- SUSPENDED ACOUSTICAL TILE CEILING
- PENDANT LIGHT FIXTURES
- RETURN AIR GRILLES
- HVAC CEILING-MOUNTED DIFFUSERS

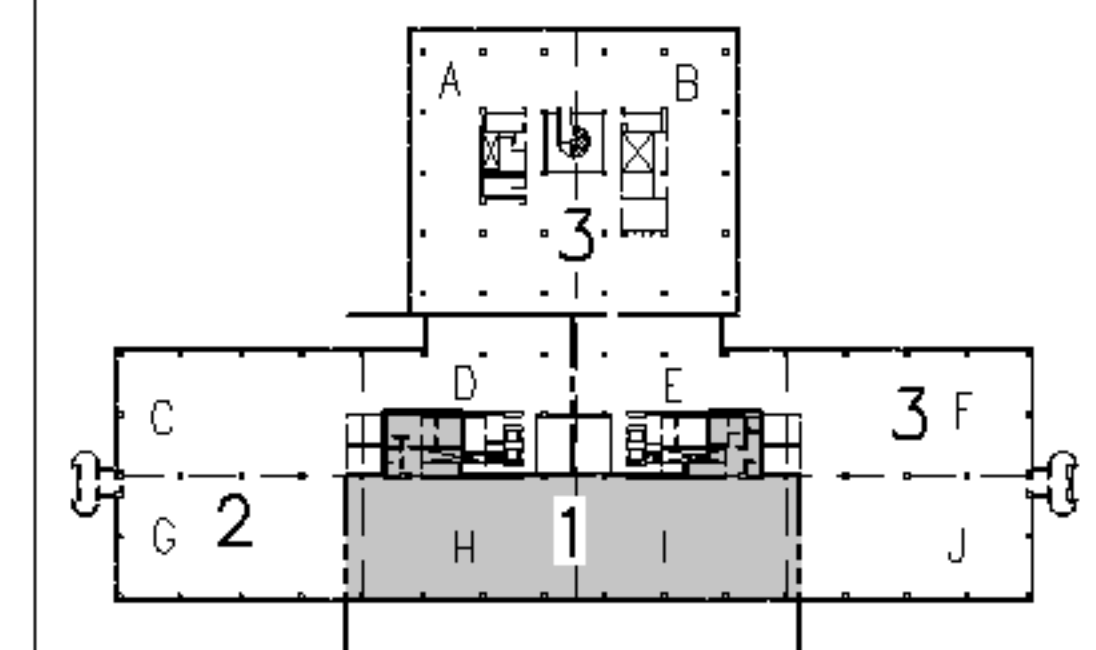


F18 KEY PLAN

0	ISSUED FOR CONSTRUCTION	3-10-05
REV.	DESCRIPTION	DATE

ISSUED FOR CONSTRUCTION
3-10-05

CURRENT ISSUE STATUS:

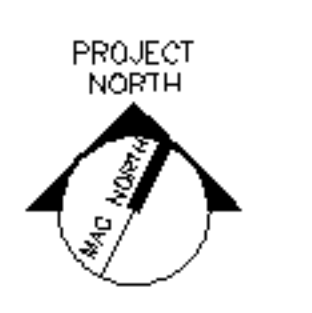

ARCHITECTURE ENGINEERING PLANNING
SMRT
144 Fore Street, P.O. Box 618
Portland, Maine 04104
Tel. (207) 772-3846
Fax. (207) 772-1070

UnumProvident HO-1
3rd FLOOR OFFICE RENOVATIONS
PORTLAND, ME.

PHASE I
REFLECTED CEILING PLAN

SHEET TITLE:	PHASE I REFLECTED CEILING PLAN		
SCALE:	1/8"=1'-0"	DATE:	
PROJECT MANAGER:	JLH	GRAPHIC SCALE:	0" 1"
JOB CAP/DRAWN:	CEB	SHEET No.:	AE101
A/E OF RECORD:	JLH	SMRT CAD FILE:	AE101-05004
PROJECT No.:	05004		

A1 PHASE I REFLECTED CEILING PLAN

1/8"=1'-0"