


COVER PLATES ON PERIMETER RETURN AIR SOFFIT, TYPICAL AT PRIVATE OFFICES - SEE DETAIL L4/AE001

- SUSPENDED ACOUSTICAL CEILING TILES
- EXISTING CEILING GRID
- ADDITIONAL GRID PIECES
- PENDANT LIGHT FIXTURES
- HVAC CEILING-MOUNTED DIFFUSERS
- RETURN AIR GRILLES

EXHAUST GRILLE
SUSPENDED ACOUSTICAL TILE CEILING
CEILING-MOUNTED DOWN LIGHTS


NOTE: PAINT CONCRESS STREET FACE OF DUCTWORK ADJACENT TO THE EXTERIOR WALL FLAT BLACK TO REDUCE ITS VISIBILITY FROM CONGRESS STREET. SEE MECHANICAL DRAWINGS FOR LOCATIONS OF DUCTWORK

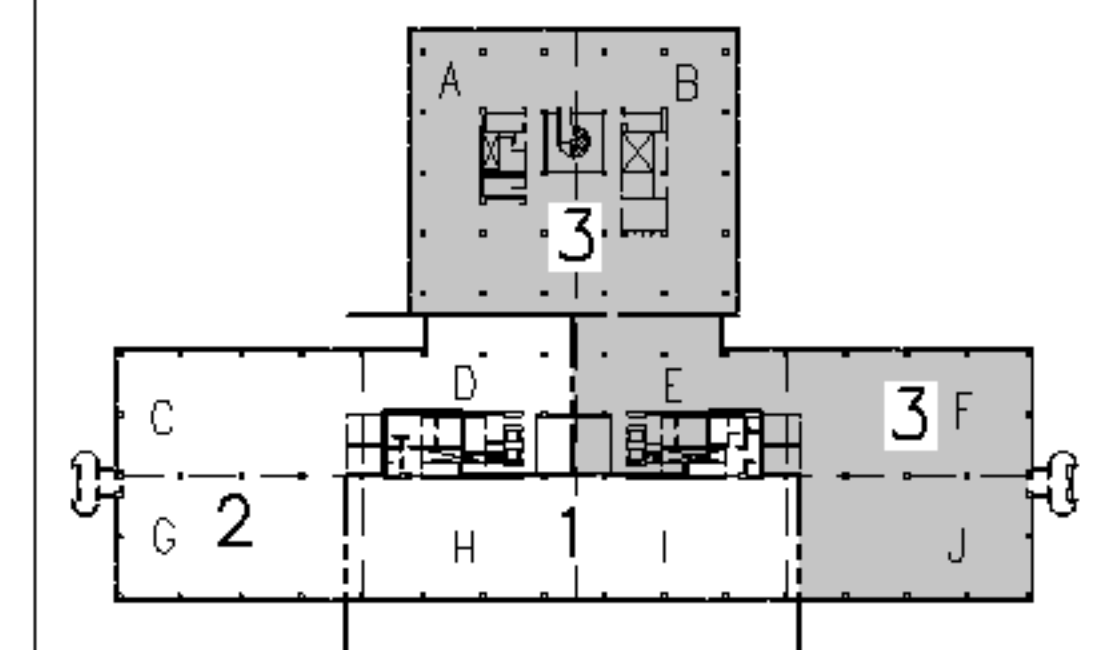

F18 KEY PLAN

0	ISSUED FOR CONSTRUCTION	3-10-05
REV.	DESCRIPTION	DATE

ISSUED FOR CONSTRUCTION
3-10-05

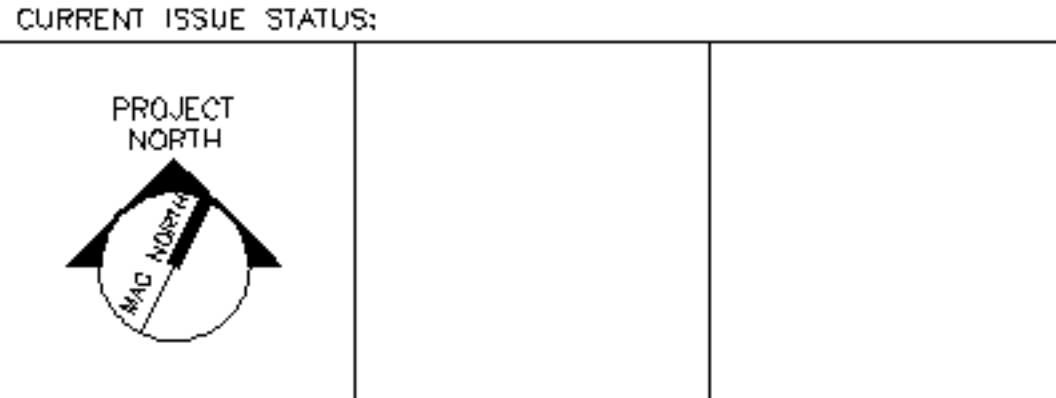

ARCHITECTURE ENGINEERING PLANNING
SMRT
144 Fore Street, P.O. Box 618
Portland, Maine 04104
Tel. (207) 772-3846
Fax. (207) 772-1070

UnumProvident HO-1
3rd FLOOR OFFICE RENOVATIONS
PORTLAND, ME.

PROJECT: **PHASE III - PARTIAL REFLECTED CEILING PLAN - EAST**

SCALE:	1/8"=1'-0"	DATE:	
PROJECT MANAGER:	JLH	GRAPHIC SCALE:	0" 1"
JOB CAP/DRAWN:	CEB	SHEET No.	
A/E OF RECORD:	JLH		
SMRT CAD FILE:	AE103-05004		
PROJECT No.	05004		

A1 PHASE III - PARTIAL REFLECTED CEILING PLAN - EAST

1/8"=1'-0"

AE103