
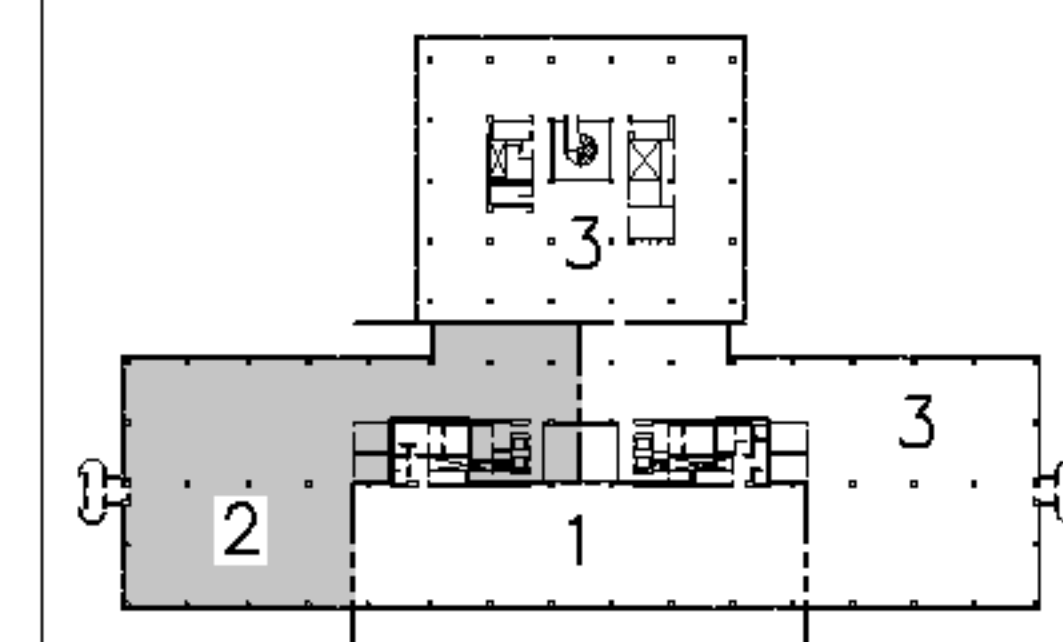


NOTE:

- SEE SHEET E-001 FOR LEGEND AND GENERAL NOTES.

KEYED NOTES:

- (NOT USED)
- WIRING FOR VAV BOXES TO BE FED VIA CONTROL POWER TRANSFORMER FURNISHED BY DIVISION 15000. WIRING TO BE 2#12 AWG & #12 GND, 3/4" C.
- FURNISH & INSTALL A DOUBLE GANG BOX FOR MODULAR FURNITURE FEED. MOUNT BOX 8" AFF.
- (NOT USED)

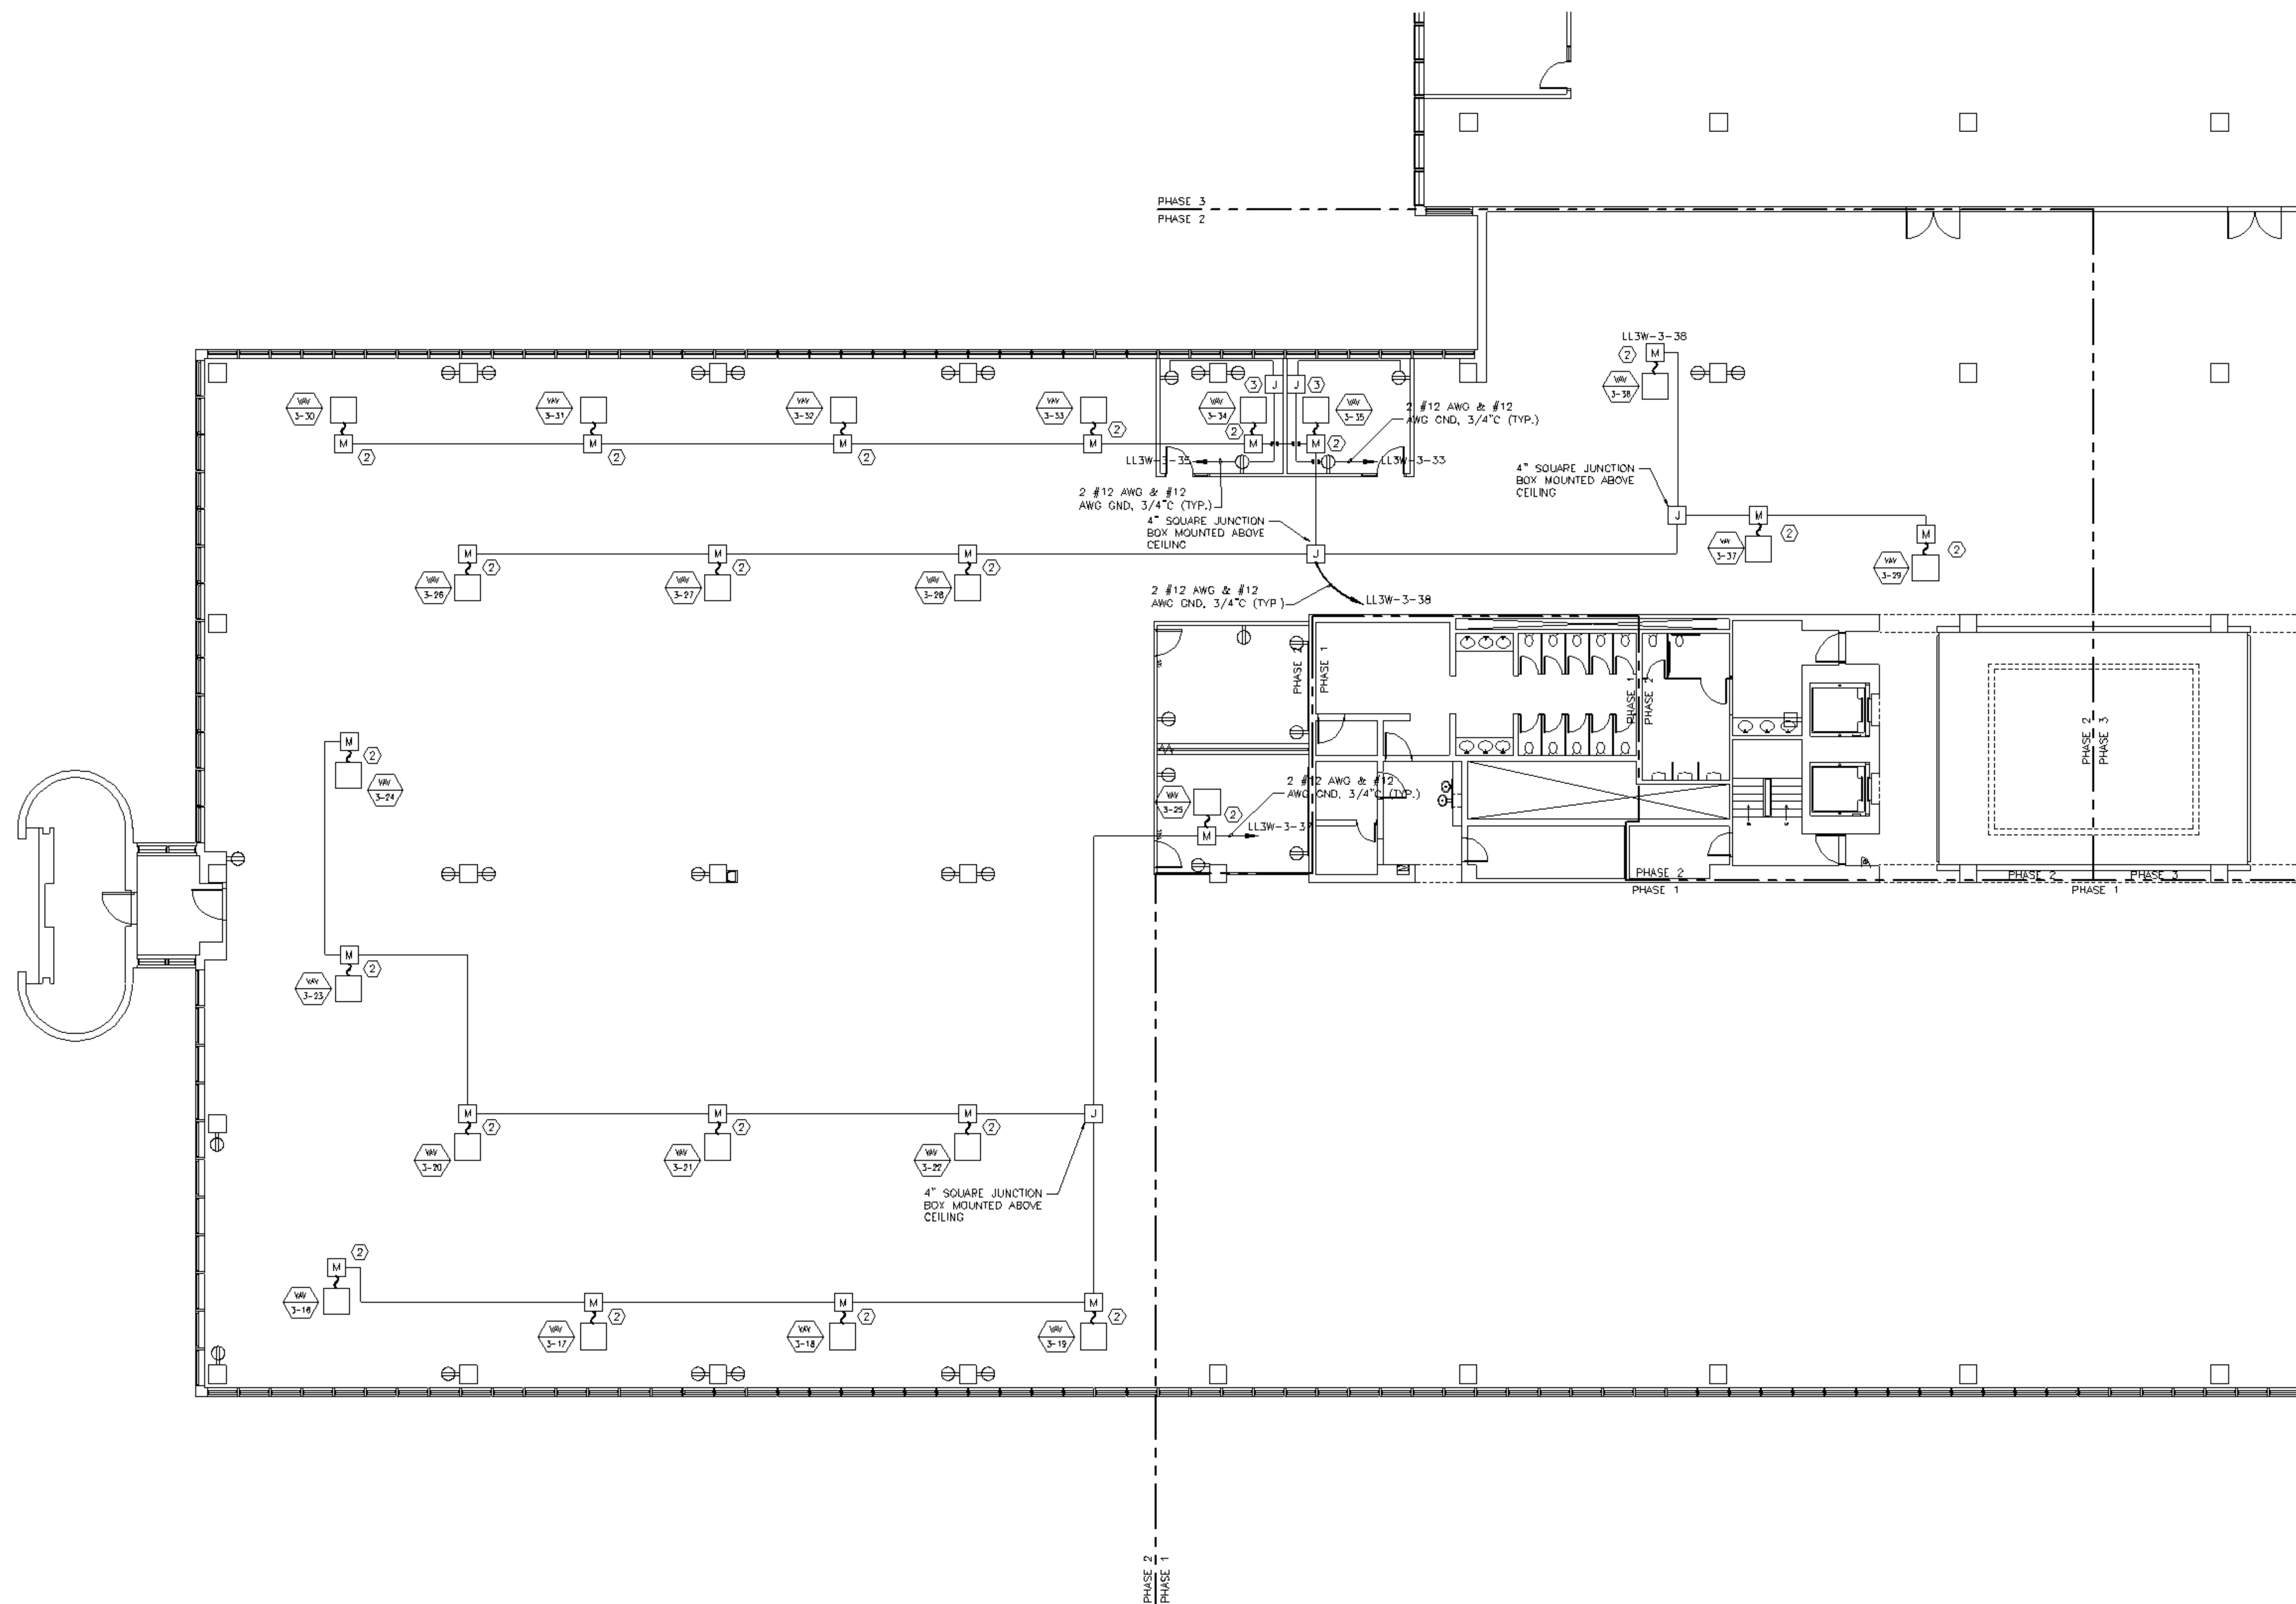

F18	KEY PLAN	
NOT TO SCALE		
0	ISSUED FOR CONSTRUCTION	3-10-05
REV.	DESCRIPTION	DATE

ISSUED FOR CONSTRUCTION
3-10-05

CURRENT ISSUE STATUS:

PROJECT NORTH

ARCHITECTURE ENGINEERING PLANNING
SMRT
144 Fore Street, P.O. Box 618
Portland, Maine 04104
Tel. (207) 772-3846
Fax. (207) 772-1070

UnumProvident HO-1
3rd FLOOR OFFICE RENOVATIONS
PORTLAND, ME.

PHASE II POWER PLAN	
SHEET TITLE:	
SCALE: 1/8"=1'-0"	DATE: 3-10-05
PROJECT MANAGER: JLH	GRAPHIC SCALE: 0" 1"
JOB CAP/DRAWN: CEB/LAM	
A/E OF RECORD: DJT	SHEET No.
SMRT CAD FILE: EP102-05004	EP102
PROJECT No. 05004	