



- NOTE:**
- SEE SHEET E-001 FOR LEGEND AND GENERAL NOTES.
- KEYED NOTES:**
- (NOT USED)
 - WIRING FOR VAV BOXES TO BE FED VIA CONTROL POWER TRANSFORMER FURNISHED BY DIVISION 15000. WIRING TO BE 2#12 AWG & #12 GND, 3/4\".
 - FURNISH & INSTALL A DOUBLE GANG BOX FOR MODULAR FURNITURE FEED. MOUNT BOX 8\" AFF.
 - (NOT USED)

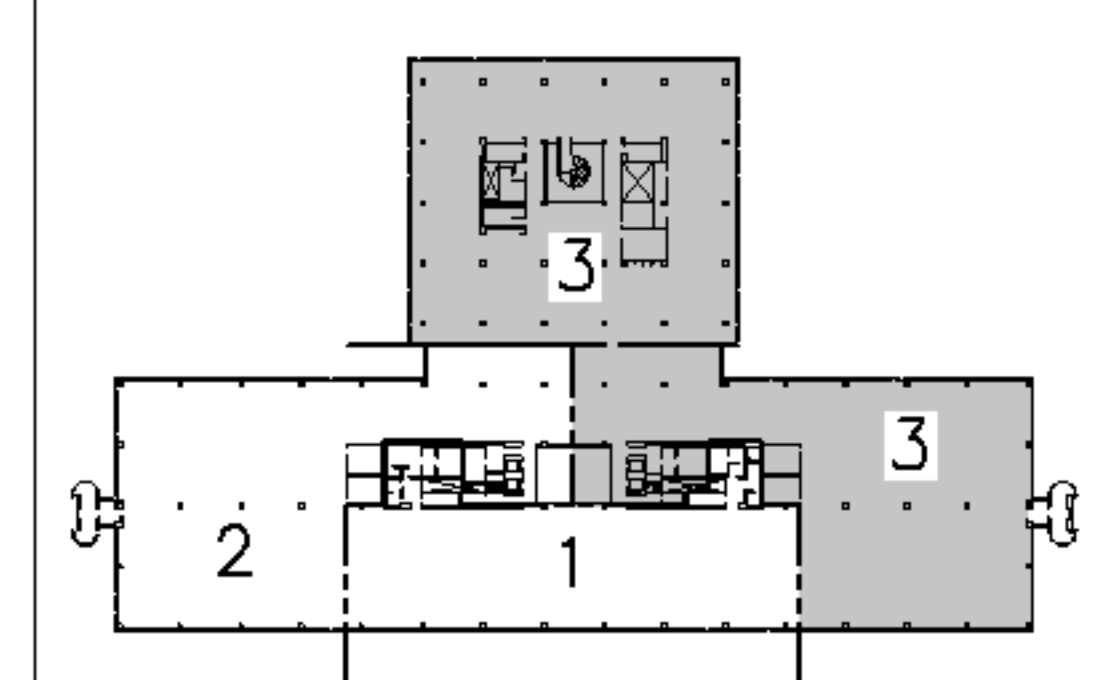

F18	KEY PLAN	
NOT TO SCALE		
0	ISSUED FOR CONSTRUCTION	3-10-05
REV.	DESCRIPTION	DATE

ISSUED FOR CONSTRUCTION
3-10-05

CURRENT ISSUE STATUS:

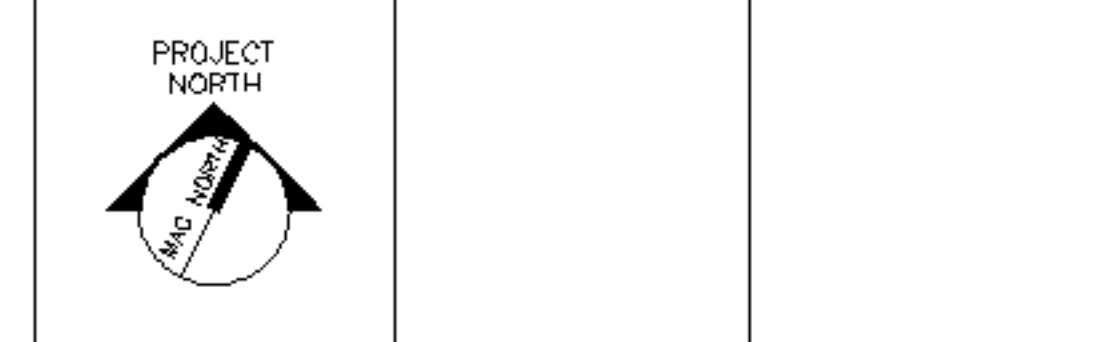

ARCHITECTURE ENGINEERING PLANNING
 SMRT
 144 Fore Street, P.O. Box 618
 Portland, Maine 04104
 Tel. (207) 772-3846
 Fax. (207) 772-1070

UnumProvident HO-1
 3rd FLOOR OFFICE RENOVATIONS
 PORTLAND, ME.

PROJECT: PHASE III - PARTIAL POWER PLAN

SHEET TITLE:	1/8"=1'-0"	DATE:	3-10-05
PROJECT MANAGER:	JLH	GRAPHIC SCALE:	0" 1"
JOB CAP/DRAWN:	CEB/LAM	SHEET No.	
A/E OF RECORD:	DJT	SMRT CAD FILE:	EP103-05004
PROJECT No.	05004		EP103

A1 FLOOR PLAN
 1/8"=1'-0"