


**NOTES:**

1. SEE SHEET E-001 FOR LEGEND AND GENERAL NOTES.
2. RELOCATE SMOKE DETECTORS AT LOCATIONS SHOWN. PROVIDE NEW WIRING FOR SMOKE DETECTORS. NEW WIRING TO BE UL LISTED FIRE ALARM MC CABLE. EXISTING PLENUM RATED CABLE TO BE REMOVED.
3. TEST FIRE ALARM SYSTEM AFTER COMPLETION OF EACH PHASE TO VERIFY PROPER SYSTEM OPERATION.
4. RE-INSTALL WHITE NOISE SYSTEM SPEAKERS AT LOCATIONS SHOWN ON DRAWINGS.
5. FOR ALL VOICE/DATA OUTLETS SHOWN PROVIDE EMPTY OUTLET BOX AND 3/4" CONDUIT (W/PULL STRING) TO ABOVE AN ACCESSIBLE CEILING.

**KEYED NOTES:**

- ① EXISTING FIRE ALARM NOTIFICATION AND INITIATING DEVICES TO BE RE-WIRED WITH UL LISTED FIRE ALARM MC CABLE.
- ② INSTALL EXISTING CLOCKS AT A NEW HEIGHT OF +84" AFF. EXTEND AND RECONNECT EXISTING WIRING TO NEW LOCATION.
- ③ RUN 2#14 AWC WIRING FOR FIRE ALARM AUDIBLE NOTIFICATION CIRCUIT TO JUNCTION BOX ABOVE CEILING SHOWN ON EY102 AND RUN 2#14 AWC FOR FIRE ALARM VISUAL NOTIFICATION CIRCUIT TO POWER EXTENDER LOCATED IN ELECTRICAL RM.
- ④ RUN WIRING FOR INITIATING DEVICES TO JUNCTION BOX LOCATED ABOVE CEILING AT LOCATION SHOWN ON SHEET EY102.

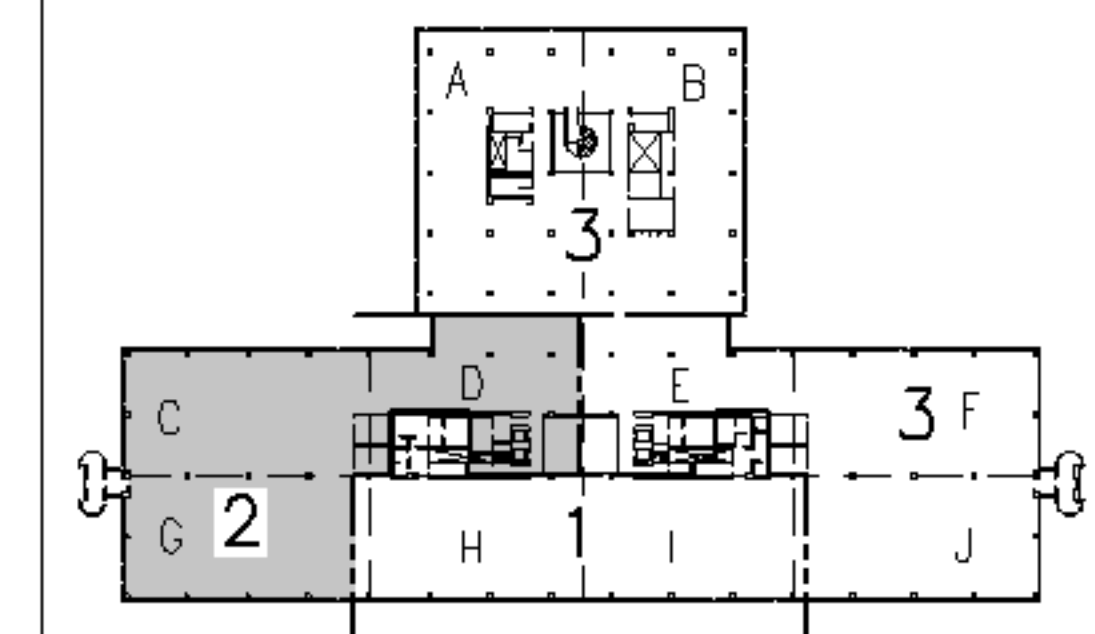


F18 KEY PLAN

NOT TO SCALE

REV.	DESCRIPTION	DATE
<b>ISSUED FOR CONSTRUCTION</b>		
<b>3-10-05</b>		
CURRENT ISSUE STATUS:		

PROJECT NORTH

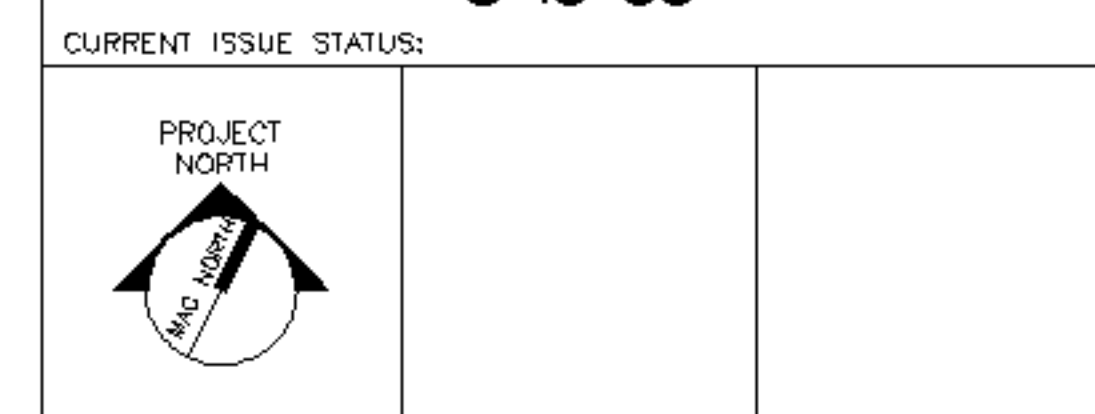

**ARCHITECTURE ENGINEERING PLANNING**  
 SMRT  
 144 Fore Street, P.O. Box 618  
 Portland, Maine 04104  
 Tel. (207) 772-3846  
 Fax. (207) 772-1070

UnumProvident HO-1  
 3rd FLOOR OFFICE RENOVATIONS  
 PORTLAND, ME.

PROJECT: **PHASE II SYSTEMS PLAN**

SHEET TITLE:	
SCALE: 1/8"=1'-0"	DATE:
PROJECT MANAGER: JLH	GRAPHIC SCALE: 0" 1"
JOB CAP/DRAWN: CEB/LAM	SHEET No. EY102
A/E OF RECORD: DJT	PROJECT No. 05004
SMRT CAD FILE: EY102-05004	

A1 FLOOR PLAN  
 1/8"=1'-0"