


- NOTES:**
- SEE SHEET E-001 FOR LEGEND AND GENERAL NOTES.
  - RELOCATE SMOKE DETECTORS AT LOCATIONS SHOWN. PROVIDE NEW WIRING FOR SMOKE DETECTORS. NEW WIRING TO BE UL LISTED FIRE ALARM MC CABLE. EXISTING PLENUM RATED CABLE TO BE REMOVED.
  - TEST FIRE ALARM SYSTEM AFTER COMPLETION OF EACH PHASE TO VERIFY PROPER SYSTEM OPERATION.
  - RE-INSTALL WHITE NOISE SYSTEM SPEAKERS AT LOCATIONS SHOWN ON DRAWINGS.
  - FOR ALL VOICE/DATA OUTLETS SHOWN PROVIDE EMPTY OUTLET BOX AND 3/4" CONDUIT (W/PULL STRING) TO ABOVE AN ACCESSIBLE CEILING.


- KEYED NOTES:**
- EXISTING FIRE ALARM NOTIFICATION AND INITIATING DEVICES TO BE RE-WIRED WITH UL LISTED FIRE ALARM MC CABLE.
  - INSTALL EXISTING CLOCKS AT A NEW HEIGHT OF +84" AFF. EXTEND AND RECONNECT EXISTING WIRING TO NEW LOCATION.
  - RUN 2#14 AWG WIRING FOR FIRE ALARM AUDIBLE NOTIFICATION CIRCUIT TO JUNCTION BOX ABOVE CEILING SHOWN ON EY102 AND RUN 2#14 AWG FOR FIRE ALARM VISUAL NOTIFICATION CIRCUIT TO POWER EXTENDER LOCATED IN ELECTRICAL RM.
  - RUN WIRING FOR INITIATING DEVICES TO JUNCTION BOX LOCATED ABOVE CEILING AT LOCATION SHOWN ON SHEET EY102.

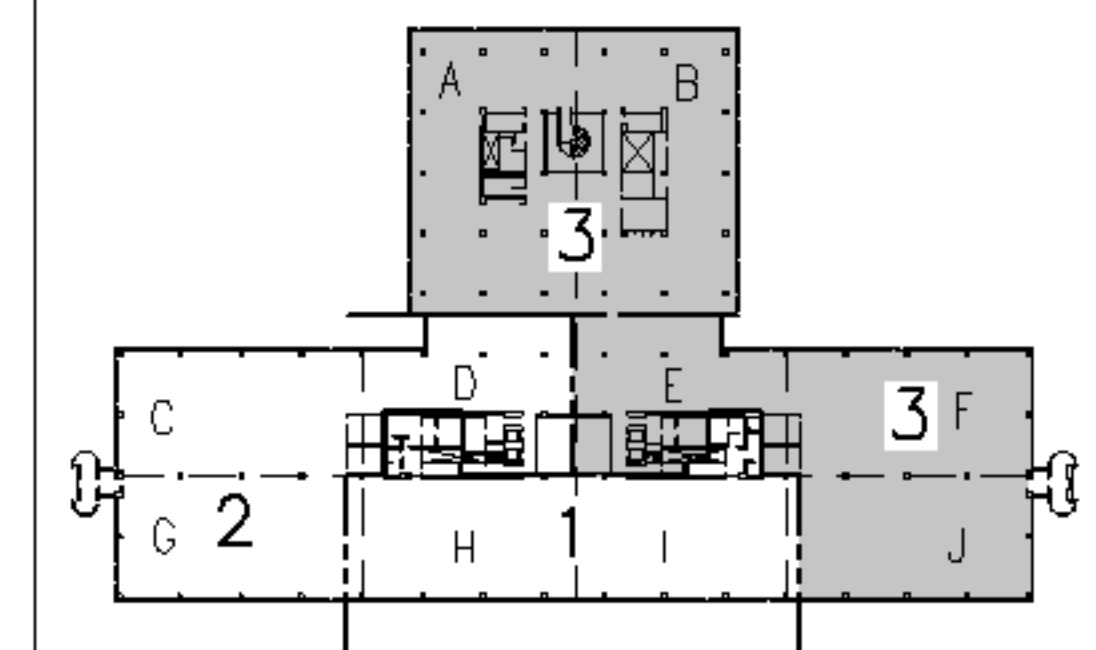

F18	KEY PLAN	
NOT TO SCALE		
0	ISSUED FOR CONSTRUCTION	3-10-05
REV.	DESCRIPTION	DATE

**ISSUED FOR CONSTRUCTION**  
**3-10-05**

CURRENT ISSUE STATUS:

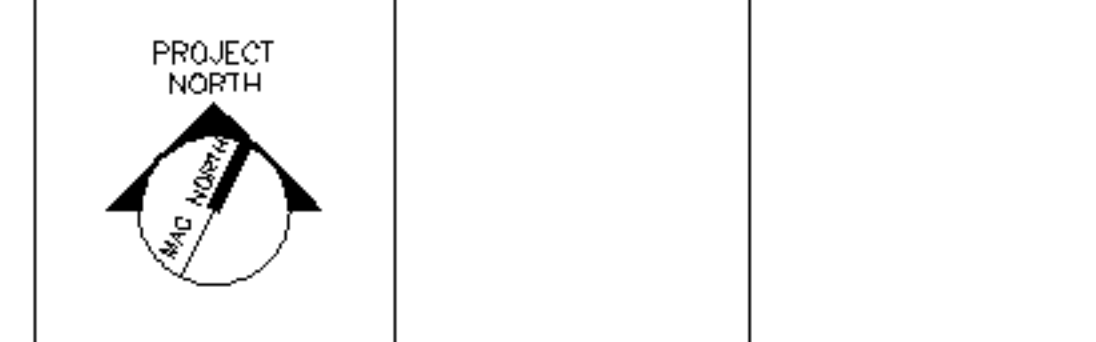

**ARCHITECTURE ENGINEERING PLANNING**  
 SMRT  
 144 Fore Street, P.O. Box 618  
 Portland, Maine 04104  
 Tel. (207) 772-3846  
 Fax. (207) 772-1070

UnumProvident HO-1  
 3rd FLOOR OFFICE RENOVATIONS  
 PORTLAND, ME.

PROJECT: **PHASE III - PARTIAL SYSTEMS PLAN**

SHEET TITLE:	
SCALE: 1/8"=1'-0"	DATE: 3-10-05
PROJECT MANAGER: JLH	GRAPHIC SCALE: 0" 1"
JOB CAP/DRAWN: CEB/LAM	
A/E OF RECORD: DJT	SHEET No. EY103
SMRT CAD FILE: EY103-05004	
PROJECT No. 05004	

A1 FLOOR PLAN  
 1/8"=1'-0"