


UnumProvident HO-1

3rd FLOOR OPEN OFFICE RENOVATIONS PORTLAND, MAINE

ISSUED FOR CONSTRUCTION
3-10-05

GENERAL SYMBOL LEGEND

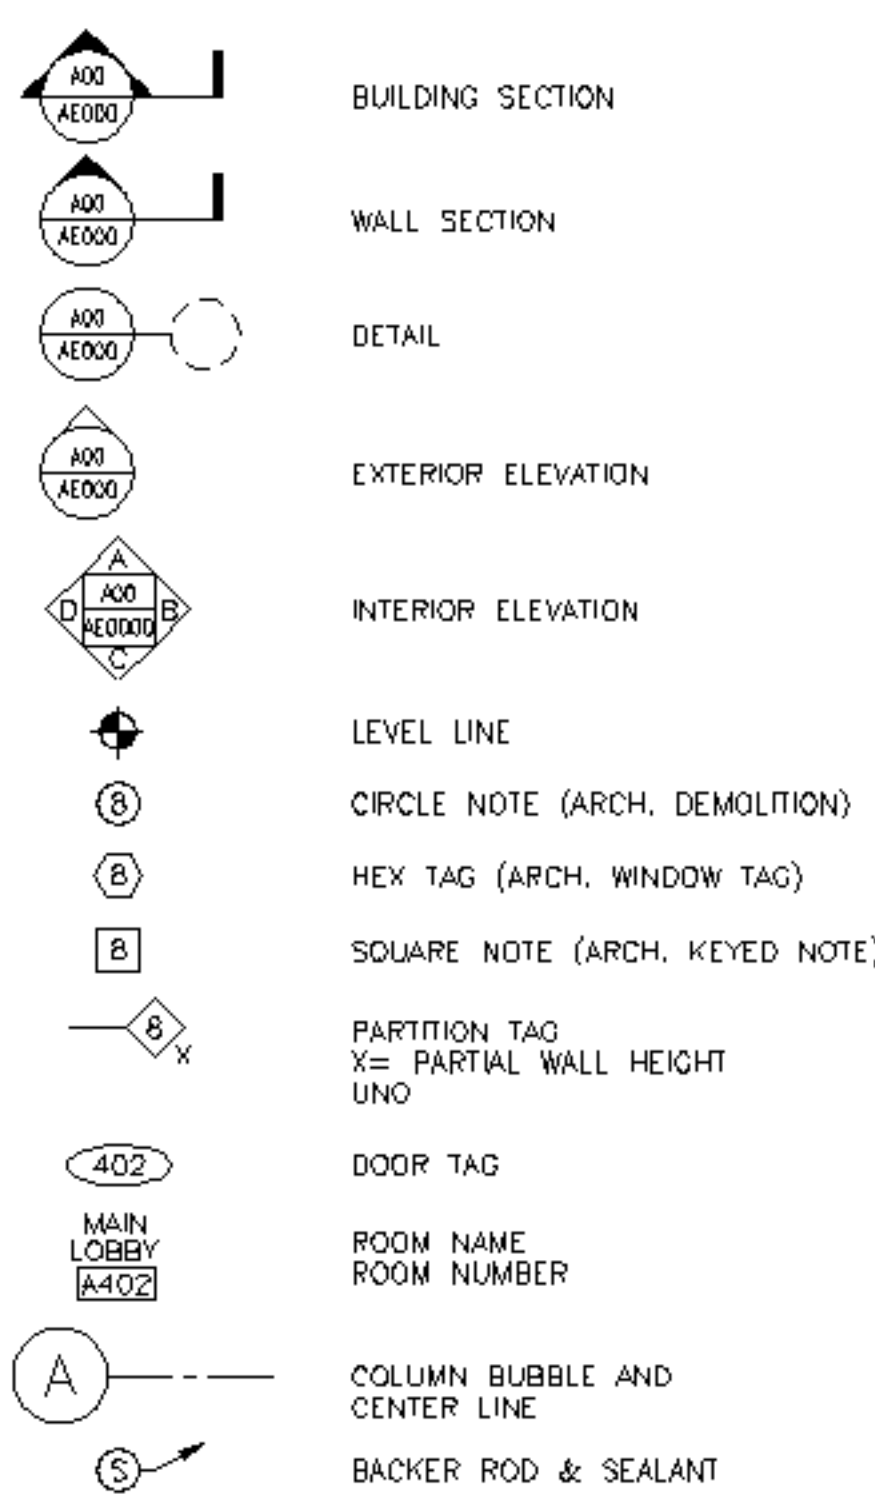

GRID NO.	TITLE
SCALE	REFERENCE SHEET

ABBREVIATIONS

AC, A/C AIR CONDITIONING
ACCU AIR CONDITIONING CONDENSER UNIT
ACPLAS ACoustical PLASTER
ACT ACoustIC CEILING TILE
AFF ABOVE FINISHED FLOOR
AP ACCESS PANEL
BCE BOTTOM CHORD EXTENSION
BD BOARD
BLP BORROWED LIGHT PANEL
BO BOTTOM OF
BOF BOTTOM OF FOOTING
BOS BOTTOM OF STEEL
BS BOTH SIDES
BSE BRICK SHELF ELEVATION
C CHANNEL
CB CATCH BASIN; CHALKBOARD
CBM CEMENTITIOUS BACKER BOARD
CFM CUBIC FEET PER MINUTE
CIP CAST IN PLACE
CJ CONTROL JOINT; CONSTRUCTION JOINT
CMU CONCRETE MASONRY UNIT
CT CERAMIC TILE
CUH CABINET UNIT HEATER
CONT CONTINUOUS
DF DRINKING FOUNTAIN
DIP DISPLAY PAL
DW DOWNSHOWER
EWF EACH WAY
EWC ELECTRIC WATER COOLER
FB FLAT BAR
FBO FURNISHED BY OTHERS
FCO FLOOR CLEAN-OUT
FCU FAN COIL UNIT
FD FLOOR DRAIN
FE FIRE EXTINGUISHER
FF FINISHED FLOOR; FAR FACE
FO FRAMED OPENING
FRP FIBERGLASS REINFORCED PLASTIC
FS FAR SIDE


GB GRAB BAR
GC GENERAL CONTRACTOR
GDT GYPSUM DROP-IN TILE
GV GRAVITY VENT
GWB GYPSUM WALL BOARD
H HORIZONTAL
HC HANDICAPPED, HOLLOW CORE
HM HOLLOW METAL
HRU HEAT RECOVERY UNIT
H&V HEATING AND VENTILATING
HVAC HEATING, VENTILATING AND AIR CONDITIONING
IF INSIDE FACE
I INSULATION JOINT
IMP IMPACT RESISTANT
INSUL INSULATION
INV INVERT
JS JOIST SUBSTITUTE
L ANGLE
LINO SHEET LINOLEUM
LLH LONG LEG HORIZONTAL
LLV LONG LEG VERTICAL
LP LIGHTING PANEL; LIQUEFIED PROPANE
MB MARKER BOARD
MDO MEDIUM DENSITY OVERLAY
MO MASONRY OPENING
MR MOISTURE-RESISTANT
MUA MAKE-UP AIR
N NOSING
NIC NOT IN CONTRACT
NS NEAR SIDE
NTS NOT TO SCALE
OC ON CENTER
OF OUTSIDE FACE
OH OVERHEAD
PA PUBLIC ADDRESS
PAF POWDER-ACTUATED FASTENER
PDU POOL DEHUMIDIFICATION UNIT
PL PLATE
PLAM PLASTIC LAMINATE
PLF POUNDS PER LINEAR FOOT
PP POWER PANEL
PSF POUNDS PER SQUARE FOOT

PSI POUNDS PER SQUARE INCH
PT PRESSURE-TREATED
PVC POLYVINYL CHLORIDE
R RISER; RADIUS
RB RESILIENT BASE
RD ROOF DRAIN
RO ROUGH OPENING
RR RUB-RAIL
RTU ROOFTOP UNIT (HVAC)
SACT SUSPENDED ACOUSTIC TILE CEILING
SC SOLID CORE
SF SQUARE FOOT; SUPPLY FAN
SK SHEAR KEY
SN SANITARY NAPKIN (DISPENSER)
SP SPECIAL
SS STAINLESS STEEL
T TREAD
TACKBOARD TACKBOARD
TB TOP AND BOTTOM
T&B TEMPORARY BENCHMARK
TCE TOP CHORD EXTENSION
TJ TE JOIST
TO TOP OF
TOC TOP OF CONCRETE
TOF TOP OF FOOTING
TOM TOP OF MASONRY
TOP TOP OF PIER
TOS TOP OF STEEL; TOP OF SLAB
TOW TOP OF WALL
TP TOILET PAPER (DISPENSER)
TS
UH UNIT HEATER
UNO UNLESS NOTED OTHERWISE
V VENT PIPE; VERTICAL
VB VAPOR BARRIER
VCT VINYL COMPOSITION TILE
VP VISION PANEL
VTR VENT THROUGH THE ROOF
VWC VINYL WALL COVERING
W/ WITH
WC WATER CLOSER
WF WIDE FLANGE
WH WATER HEATER
W/O WITHOUT
WP WORKING POINT
WS WEB STIFFENER
WWF WELDED WIRE FABRIC

DRAWING LIST


GENERAL
G001 TITLE SHEET
ARCHITECTURAL
AD101 PHASE I - REFLECTED CEILING DEMOLITION PLAN
AD102 PHASE II - REFLECTED CEILING DEMOLITION PLAN
AD103 PHASE III - PARTIAL REFLECTED CEILING DEMOLITION PLAN - EAST
AD104 PHASE III - PARTIAL REFLECTED CEILING DEMOLITION PLAN - NORTH
AD105 PARTIAL THIRD FLOOR DEMOLITION PLAN
AE101 PHASE I - REFLECTED CEILING PLAN
AE102 PHASE II - REFLECTED CEILING PLAN
AE103 PHASE III - PARTIAL REFLECTED CEILING PLAN - EAST
AE104 PHASE III - PARTIAL REFLECTED CEILING PLAN - NORTH
AE105 PARTIAL THIRD FLOOR PLAN
AE601 ROOM FINISH AND DOOR SCHEDULES
MECHANICAL
M-001 LEGEND & ABBREVIATIONS
M-002 SPECIFICATIONS AND NOTES
MD101 PHASE I HVAC DEMOLITION PLAN
MD102 PHASE II HVAC DEMOLITION PLAN
MD103 PHASE III PARTIAL HVAC DEMOLITION PLAN
MD104 PHASE III PARTIAL HVAC DEMOLITION PLAN
M-101 PHASE I - HVAC PLAN
M-102 PHASE II - HVAC PLAN
M-103 PHASE III - PARTIAL HVAC PLAN
M-104 PHASE III - PARTIAL HVAC PLAN
M-501 DETAILS
M-601 SCHEDULES

ELECTRICAL
E-001 LEGEND & GENERAL NOTES
ED101 PHASE I DEMOLITION PLAN
ED102 PHASE II DEMOLITION PLAN
ED103 PHASE III PARTIAL DEMOLITION PLAN
ED104 PHASE III PARTIAL DEMOLITION PLAN
EP101 PHASE I POWER PLAN
EP102 PHASE II POWER PLAN
EP103 PHASE III PARTIAL POWER PLAN
EP104 PHASE III PARTIAL POWER PLAN
EL101 PHASE I LIGHTING PLAN
EL102 PHASE II LIGHTING PLAN
EL103 PHASE III PARTIAL LIGHTING PLAN
EL104 PHASE III PARTIAL LIGHTING PLAN
EY101 PHASE I SYSTEMS PLAN
EY102 PHASE II SYSTEMS PLAN
EY103 PHASE III PARTIAL SYSTEMS PLAN
EY104 PHASE III PARTIAL SYSTEMS PLAN

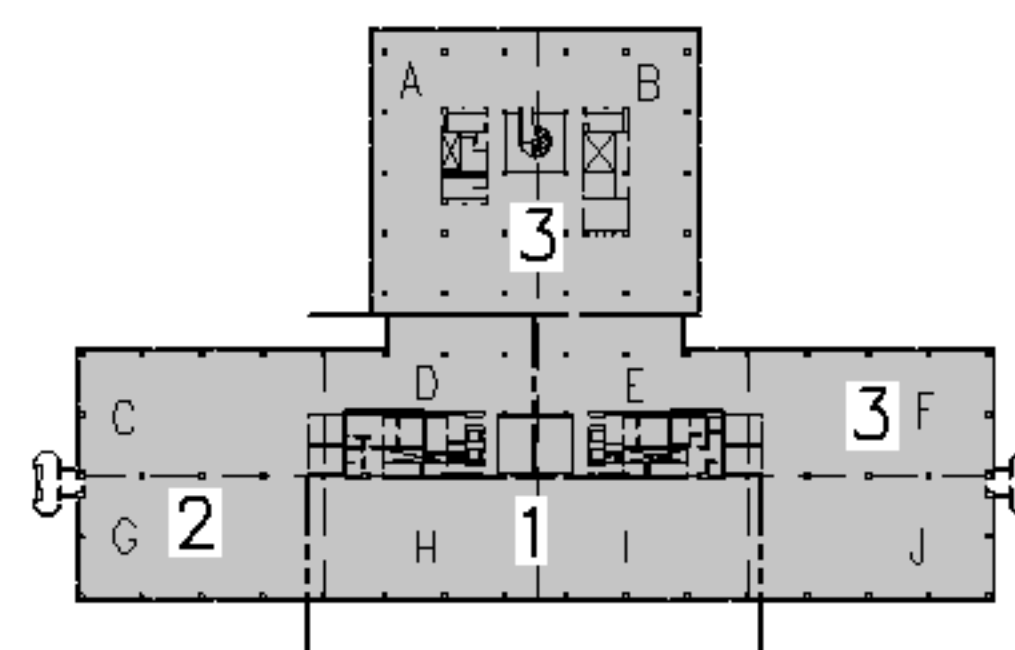

REV.	DESCRIPTION	DATE
0	ISSUED FOR CONSTRUCTION	3-10-05

ISSUED FOR CONSTRUCTION
3-10-05

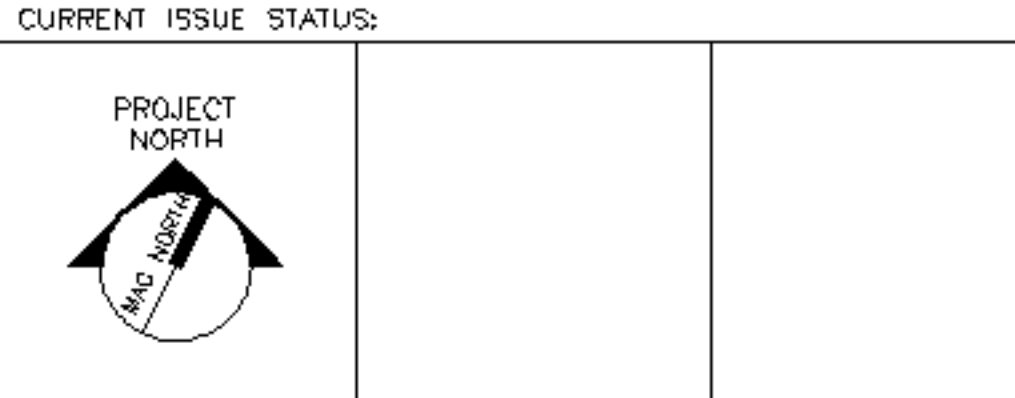


ARCHITECTURE ENGINEERING PLANNING
SMRT
144 Fore Street/P.O. Box 618
Portland, Maine 04104
Tel. (207) 772-3846
Fax. (207) 772-1070

UnumProvident HO-1
3rd FLOOR OFFICE RENOVATIONS
PORTLAND, ME

TITLE SHEET

SHEET TITLE:	NOT TO SCALE	DATE:
PROJECT MANAGER:	JLH	GRAPHIC SCALE:
JOB CAP/DRAWN:	CEB	1" = 1'
A/E OF RECORD:	JLH	SHEET No.
SMRT CAD FILE:	G001-05004	G1001
PROJECT No.	05004	

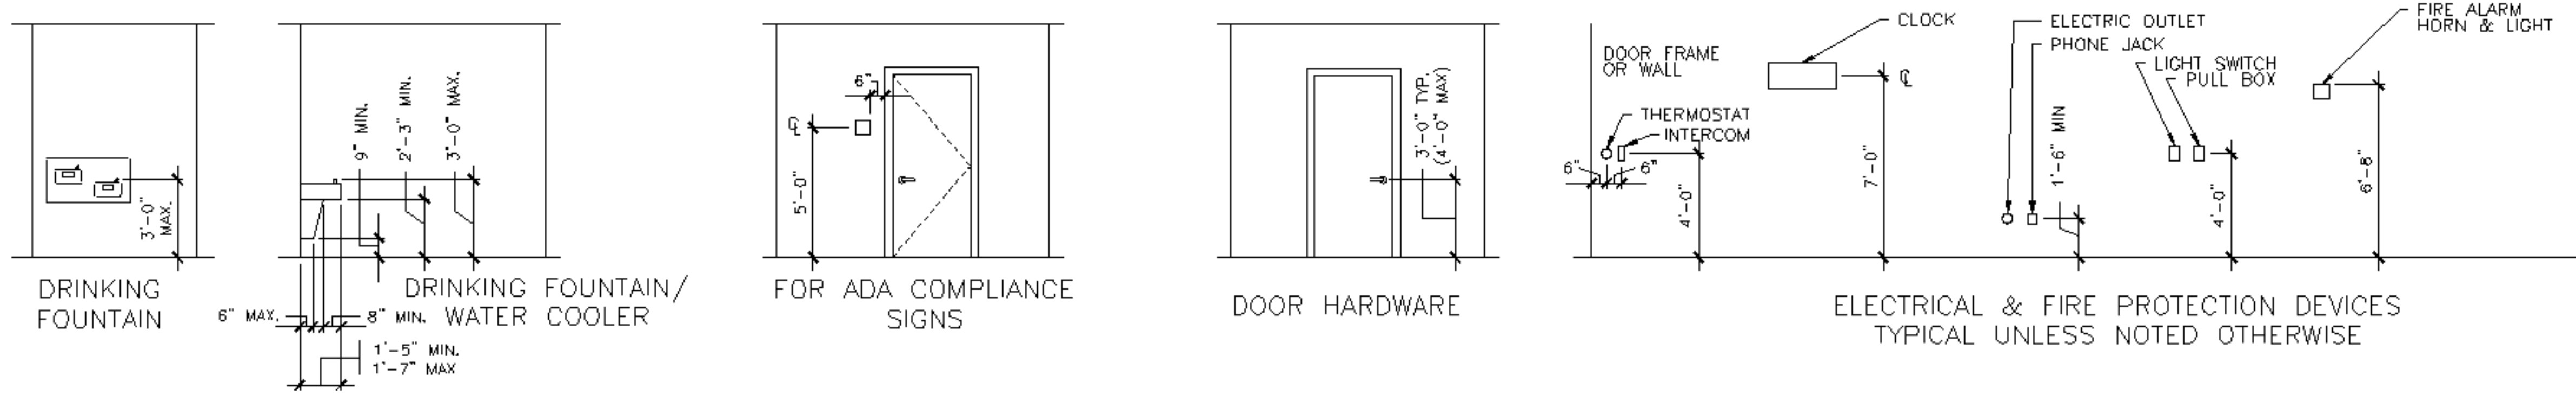

A1 TYPICAL MOUNTING HEIGHTS

NOT TO SCALE