
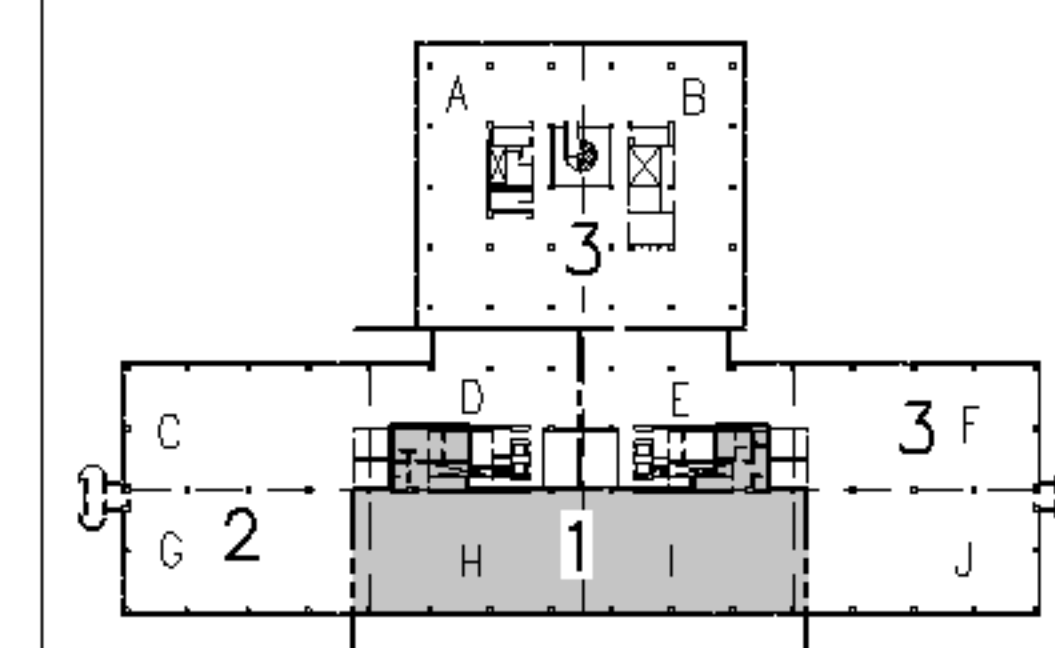


**NOTES:**

1. SEE SHEET M-001 FOR LEGEND AND ABBREVIATIONS.
2. LIGHT DUCT LINES REPRESENT EXISTING DUCTWORK. DARKER LINES REPRESENT NEW DUCTWORK.

**KEYED NOTE:**

- ① NOT USED.
- ② SPRAY PAINT NEW DUCTWORK BLACK ON SIDE FACING SOUTH WALL.

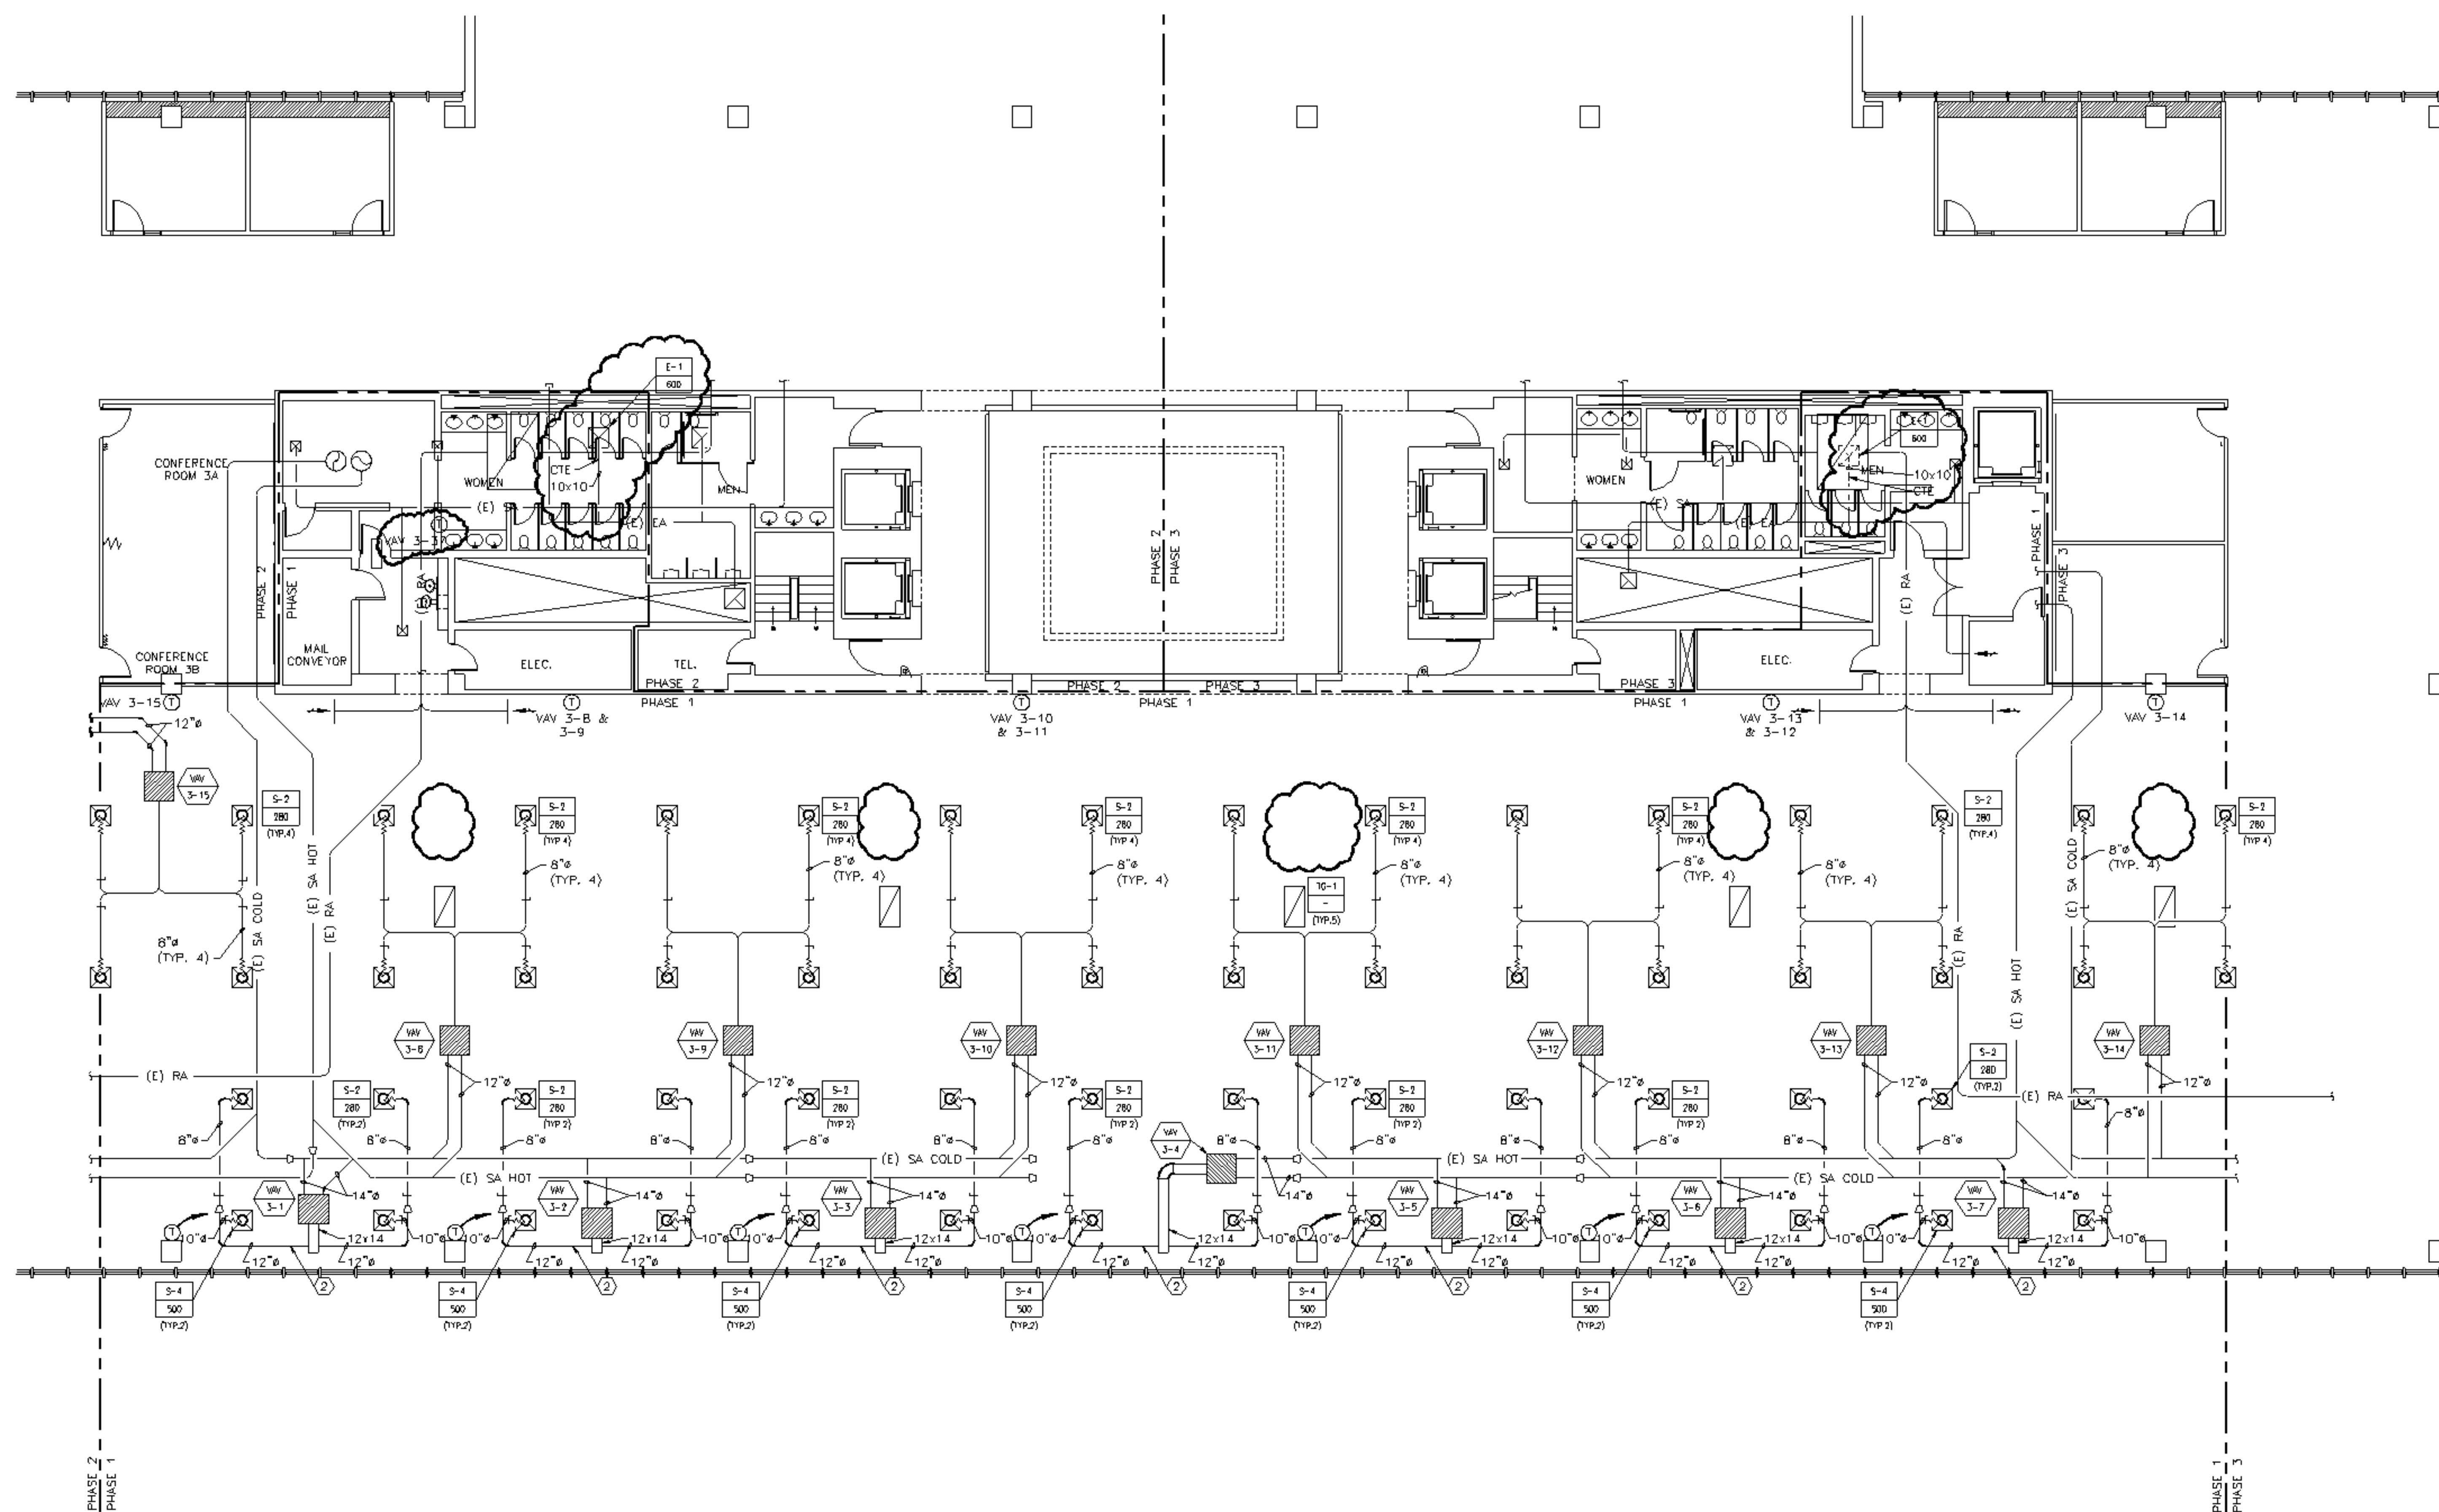

**F18 KEY PLAN**

NOT TO SCALE

0 ISSUED FOR CONSTRUCTION 3-10-05

REV. DESCRIPTION DATE

**ISSUED FOR CONSTRUCTION 3-10-05**

CURRENT ISSUE STATUS:



**ARCHITECTURE ENGINEERING PLANNING**  
 SMRT  
 144 Fore Street, P.O. Box 618  
 Portland, Maine 04104  
 Tel. (207) 772-3846  
 Fax. (207) 772-1070

UnumProvident HO-1  
 3rd FLOOR OFFICE RENOVATIONS  
 PORTLAND, ME.

**PHASE I HVAC PLAN**

SHEET TITLE:  
 SCALE: 1/8"=1'-0" DATE: 3-10-05  
 PROJECT MANAGER: JLH GRAPHIC SCALE: 0" 1"  
 JOB CAP/DRAWN: CEB/BOG  
 A/E OF RECORD: FWJ SHEET No.  
 SMRT CAD FILE: M-101-05004 M-101  
 PROJECT No. 05004

A1 FLOOR PLAN  
 1/8"=1'-0"