
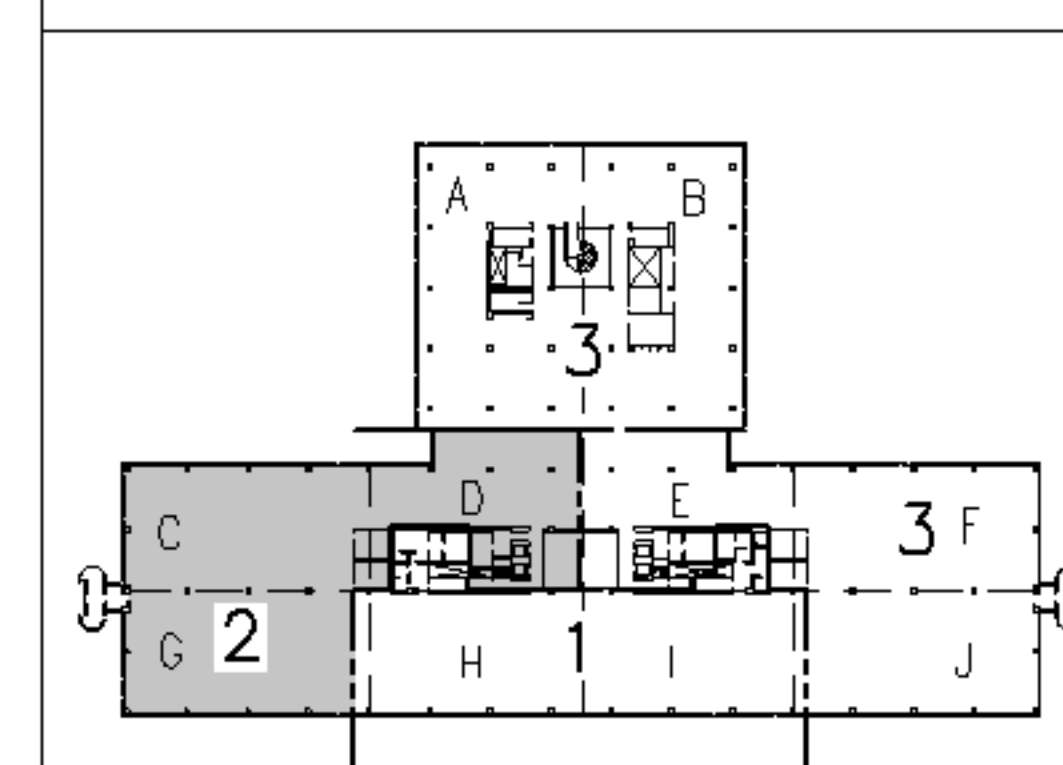


NOTE:

1. SEE SHEET M-001 FOR LEGEND AND ABBREVIATIONS.
2. LIGHT DUCT LINES REPRESENT EXISTING DUCTWORK. DARKER LINES REPRESENT NEW DUCTWORK.

KEYED NOTES:

- ① RELOCATED DIFFUSERS
- ② SPRAY PAINT NEW DUCTWORK BLACK ON SIDE FACING SOUTH WALL.

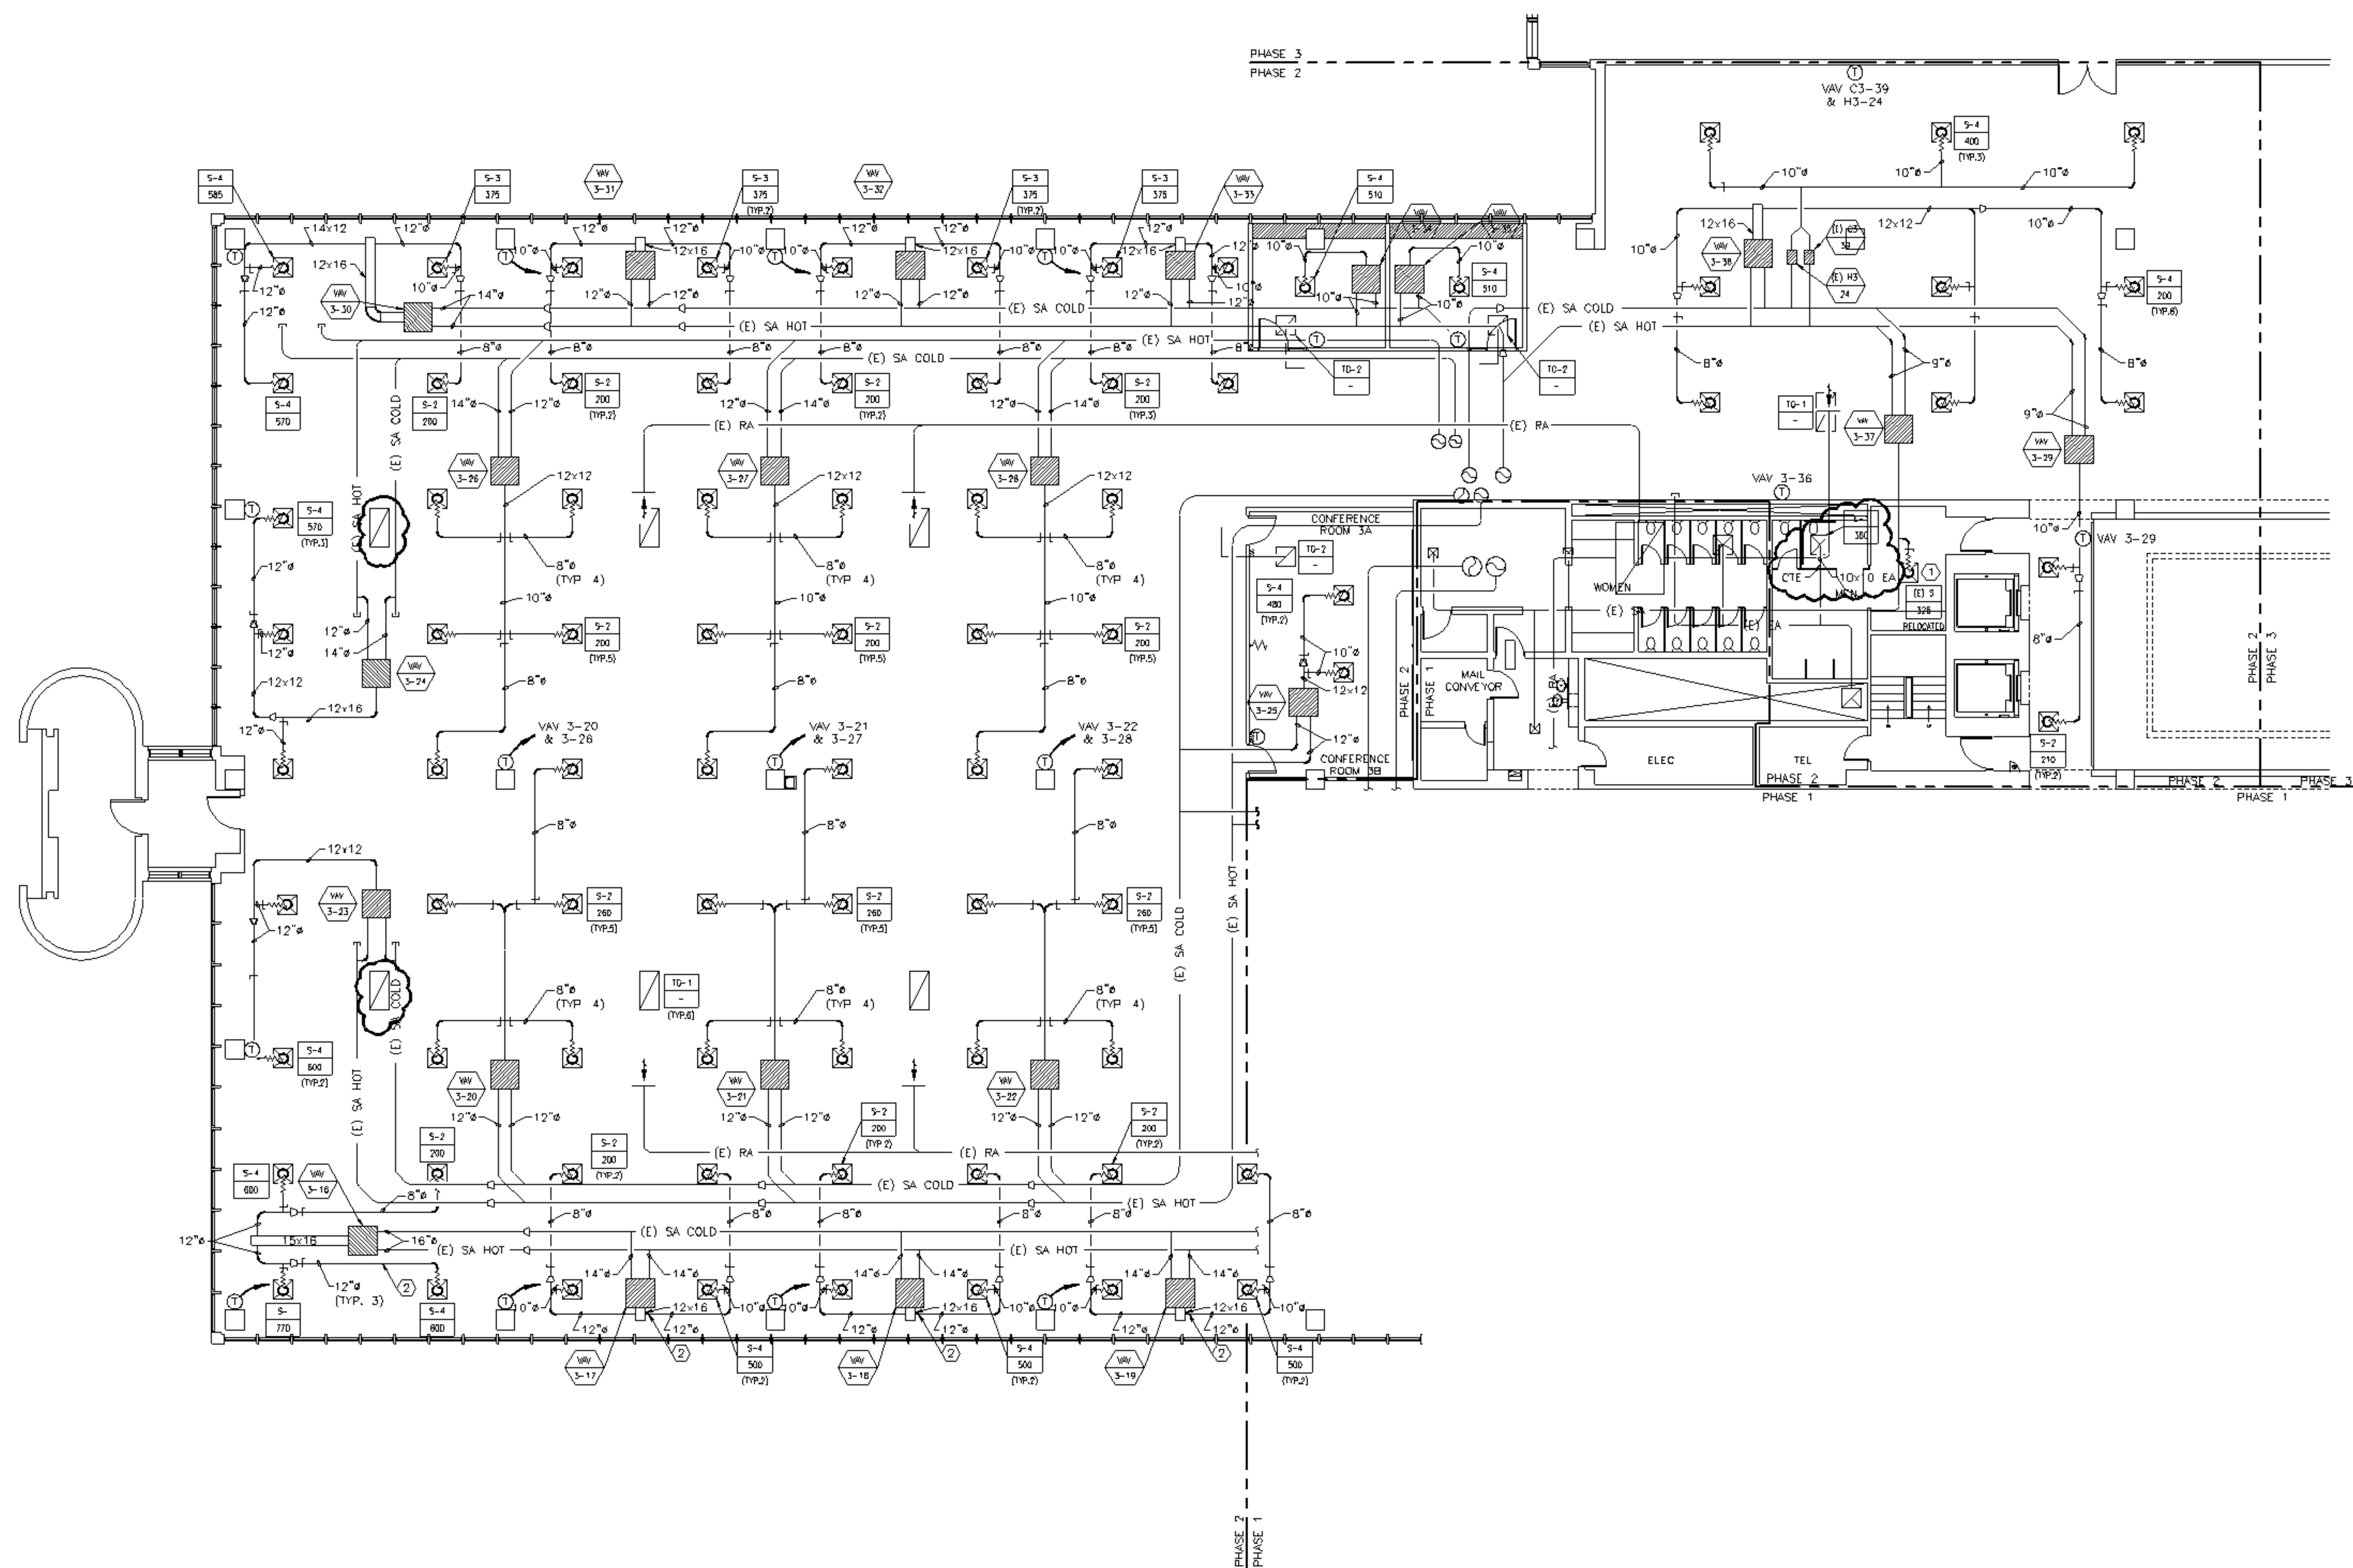

| | | |
|--------------|-------------------------|---------|
| F18 | KEY PLAN | |
| NOT TO SCALE | | |
| 0 | ISSUED FOR CONSTRUCTION | 3-10-05 |
| REV. | DESCRIPTION | DATE |

ISSUED FOR CONSTRUCTION
3-10-05



ARCHITECTURE ENGINEERING PLANNING
 SMRT
 144 Fore Street, P.O. Box 618
 Portland, Maine 04104
 Tel. (207) 772-3846
 Fax. (207) 772-1070

UnumProvident HO-1
 3rd FLOOR OFFICE RENOVATIONS
 PORTLAND, ME.

| | | | |
|------------------|-------------|-----------------------|---------|
| PROJECT: | | PHASE II HVAC PLAN | |
| SHEET TITLE: | | | |
| SCALE: | 1/8"=1'-0" | DATE: | 3-10-05 |
| PROJECT MANAGER: | JLH | GRAPHIC SCALE: | 0" 1" |
| JOB CAP/DRAWN: | CEB/BOG | A/E OF RECORD: | FWJ |
| SMRT CAD FILE: | M-102-05004 | SHEET No.: | M-102 |
| PROJECT No.: | 05004 | | |

A1 FLOOR PLAN
 1/8"=1'-0"