


NOTE:

1. SEE SHEET M-001 FOR LEGEND AND ABBREVIATIONS.
2. LIGHT DUCT LINES REPRESENT EXISTING DUCTWORK. DARKER LINES REPRESENT NEW DUCTWORK.

KEYED NOTES:

- ① RELOCATED DIFFUSERS
- ② SPRAY PAINT NEW DUCTWORK BLACK ON SIDE FACING SOUTH WALL.

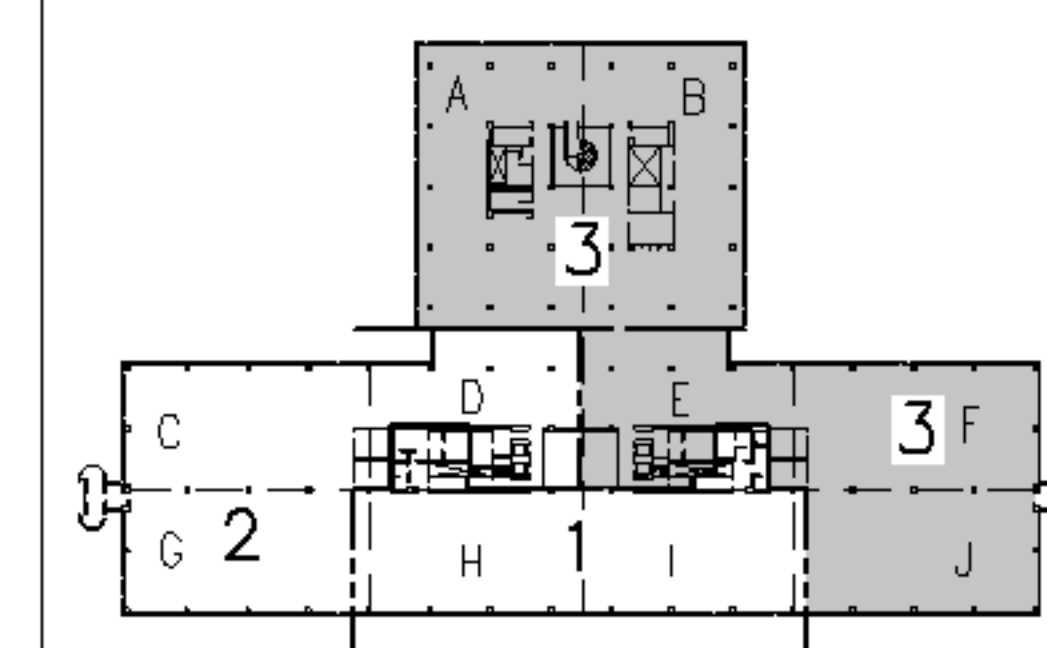

F18 KEY PLAN

NOT TO SCALE

REV.	ISSUED FOR CONSTRUCTION	3-10-05
0	DESCRIPTION	DATE

ISSUED FOR CONSTRUCTION 3-10-05

CURRENT ISSUE STATUS:



ARCHITECTURE ENGINEERING PLANNING
 SMRT
 144 Fore Street, P.O. Box 618
 Portland, Maine 04104
 Tel. (207) 772-3846
 Fax. (207) 772-1070

UnumProvident HO-1
 3rd FLOOR OFFICE RENOVATIONS
 PORTLAND, ME.

PROJECT: **PHASE III - PARTIAL HVAC PLAN**

SHEET TITLE:	
SCALE: 1/8"=1'-0"	DATE: 3-10-05
PROJECT MANAGER: JLH	GRAPHIC SCALE: 0" 1"
JOB CAP/DRAWN: CEB/BOG	
A/E OF RECORD: FWJ	SHEET No. M-103
SMRT CAD FILE: M-103-05004	PROJECT No. 05004

A1 FLOOR PLAN

1/8"=1'-0"