


**NOTE:**


1. SEE SHEET M-001 FOR LEGEND AND ABBREVIATIONS.
2. LIGHT DUCT LINES REPRESENT EXISTING DUCTWORK. DARKER LINES REPRESENT NEW DUCTWORK.

**KEYED NOTES:**

- ① RELOCATED DIFFUSERS.
- ② NOT USED
- ③ TEMPERATURE SENSOR TO C3-27 AND H2-13.
- ④ TEMPERATURE SENSOR TO C3-29 AND H2-14

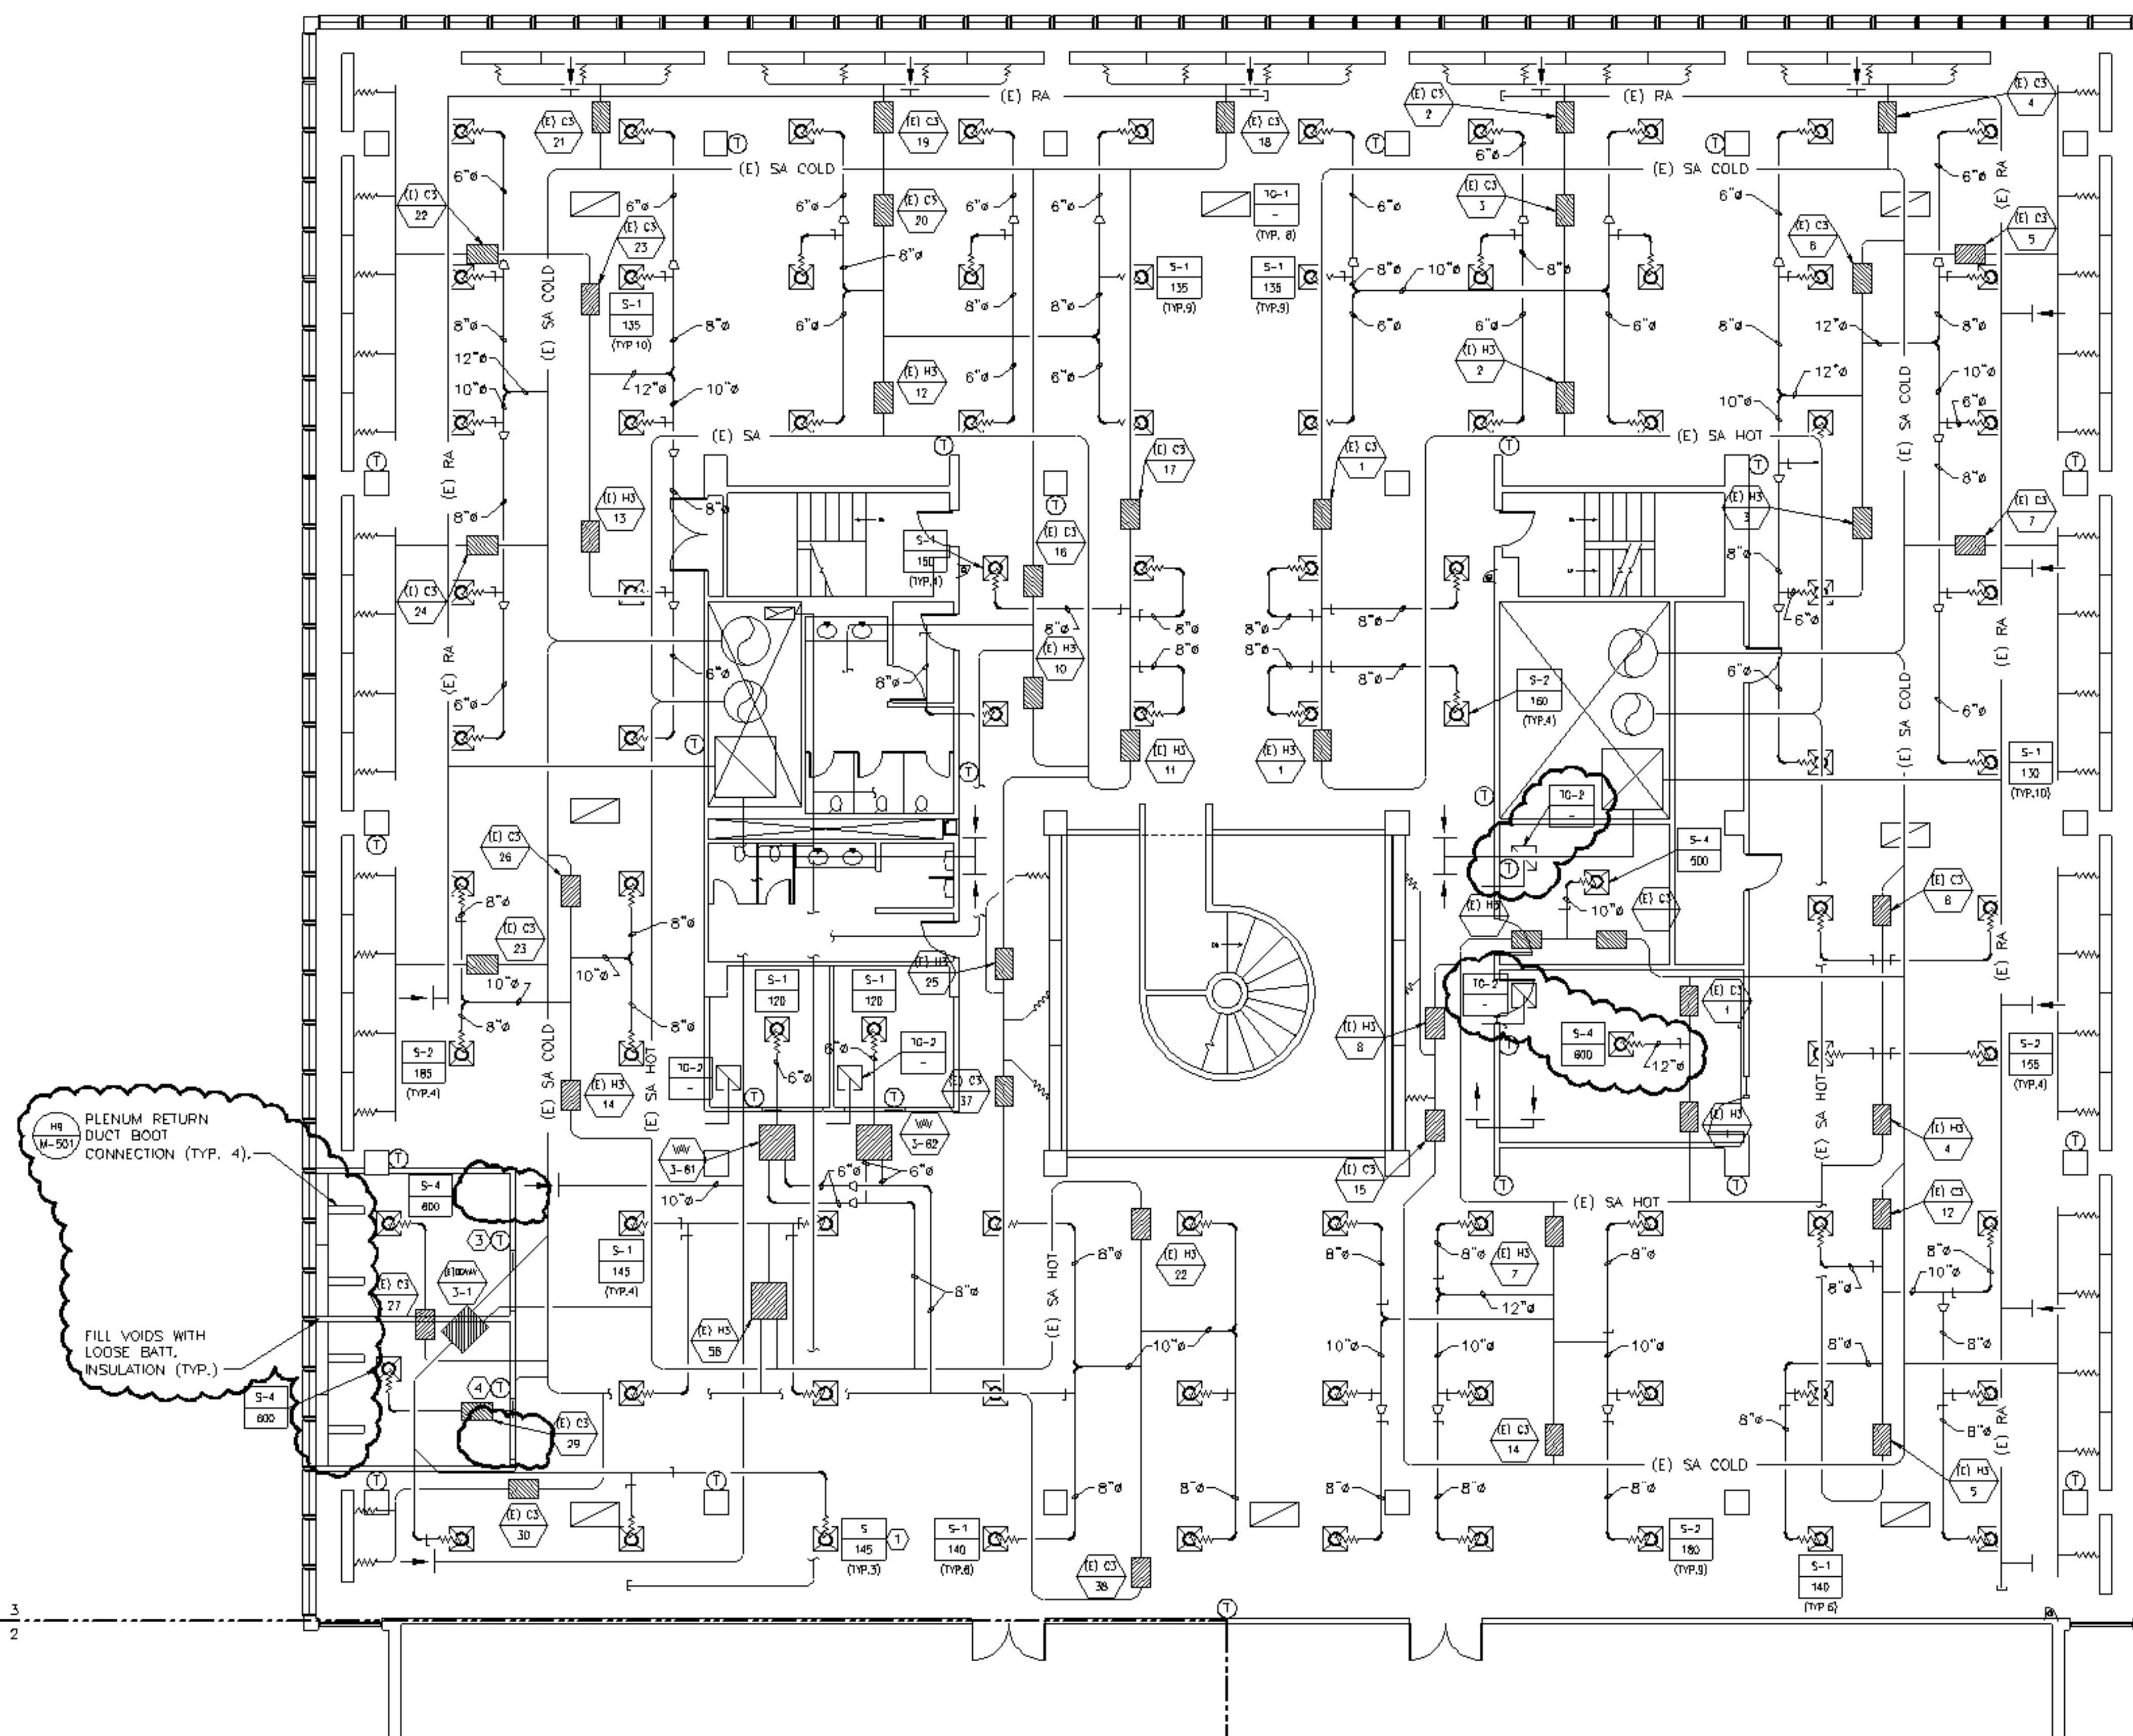

PHASE 3  
PHASE 2

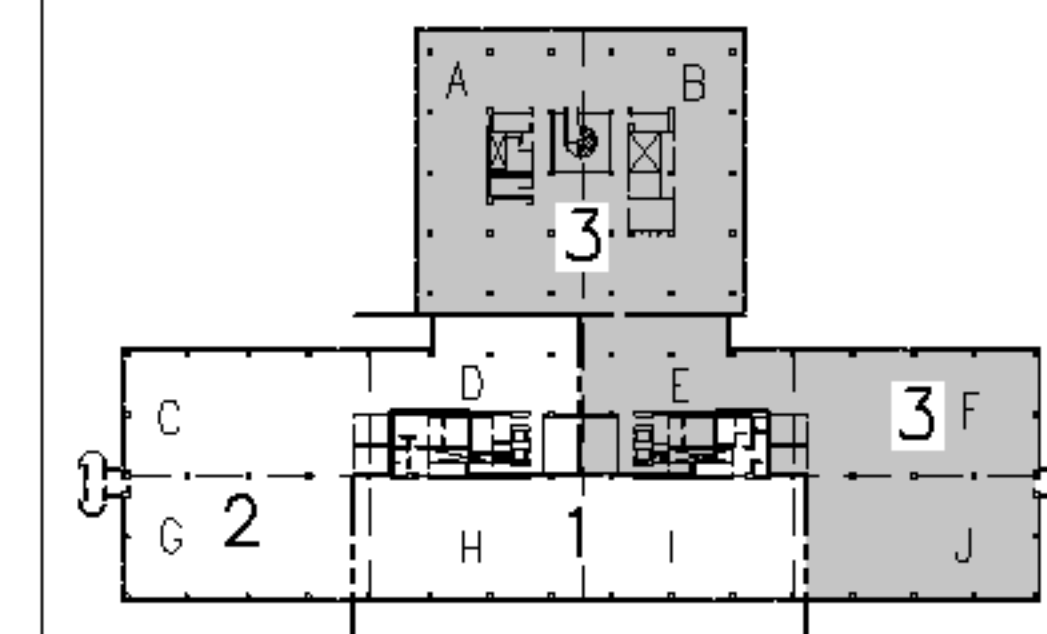


**F18 KEY PLAN**

NOT TO SCALE

REV.	ISSUED FOR CONSTRUCTION	3-10-05
0	DESCRIPTION	DATE
<b>ISSUED FOR CONSTRUCTION</b>		
<b>3-10-05</b>		

CURRENT ISSUE STATUS:

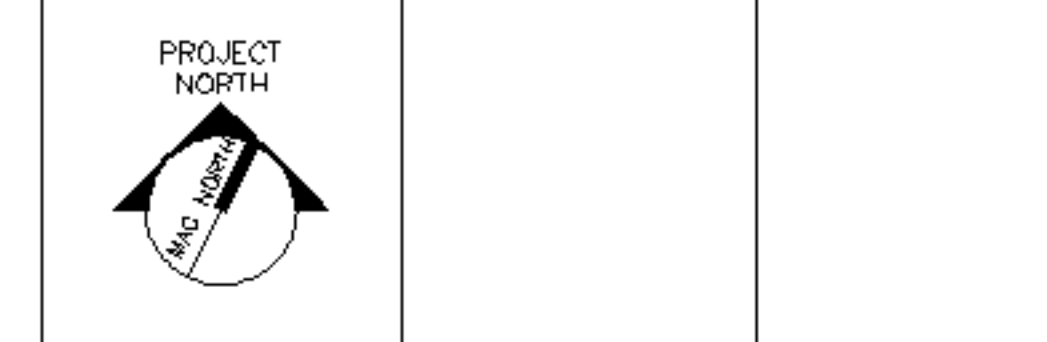

**ARCHITECTURE ENGINEERING PLANNING**  
SMRT  
144 Fore Street, P.O. Box 618  
Portland, Maine 04104  
Tel. (207) 772-3846  
Fax. (207) 772-1070

UnumProvident HO-1  
3rd FLOOR OFFICE RENOVATIONS  
PORTLAND, ME.

PROJECT: **PHASE III - PARTIAL HVAC PLAN**

SHEET TITLE:	
SCALE: 1/8"=1'-0"	DATE: 3-10-05
PROJECT MANAGER: JLH	GRAPHIC SCALE: 0" 1"
JOB CAP/DRAWN: CEB/BOG	
A/E OF RECORD: FWJ	SHEET No.
SMRT CAD FILE: M-104-05004	M-104
PROJECT No. 05004	

A1 FLOOR PLAN  
1/8"=1'-0"