
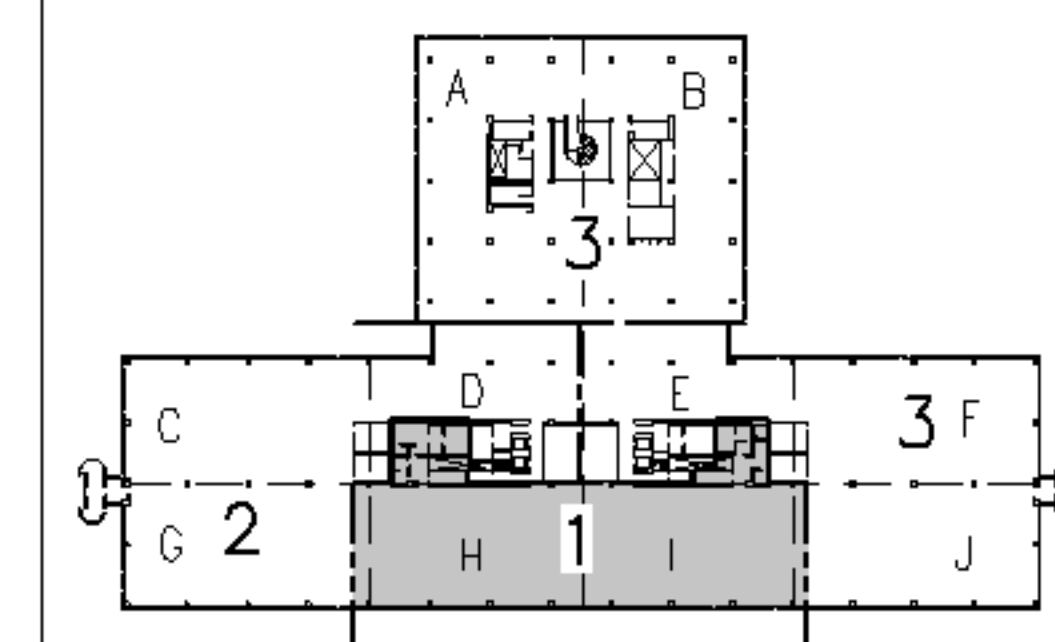


NOTE:

1. SEE SHEET M-001 FOR LEGEND AND ABBREVIATIONS.

KEYED NOTES:

- ① MITCO VALVE REMOVE AND STORE AT UNUMPROVIDENT'S DIRECTION.
- ② NOT USED.
- ③ NOT USED.

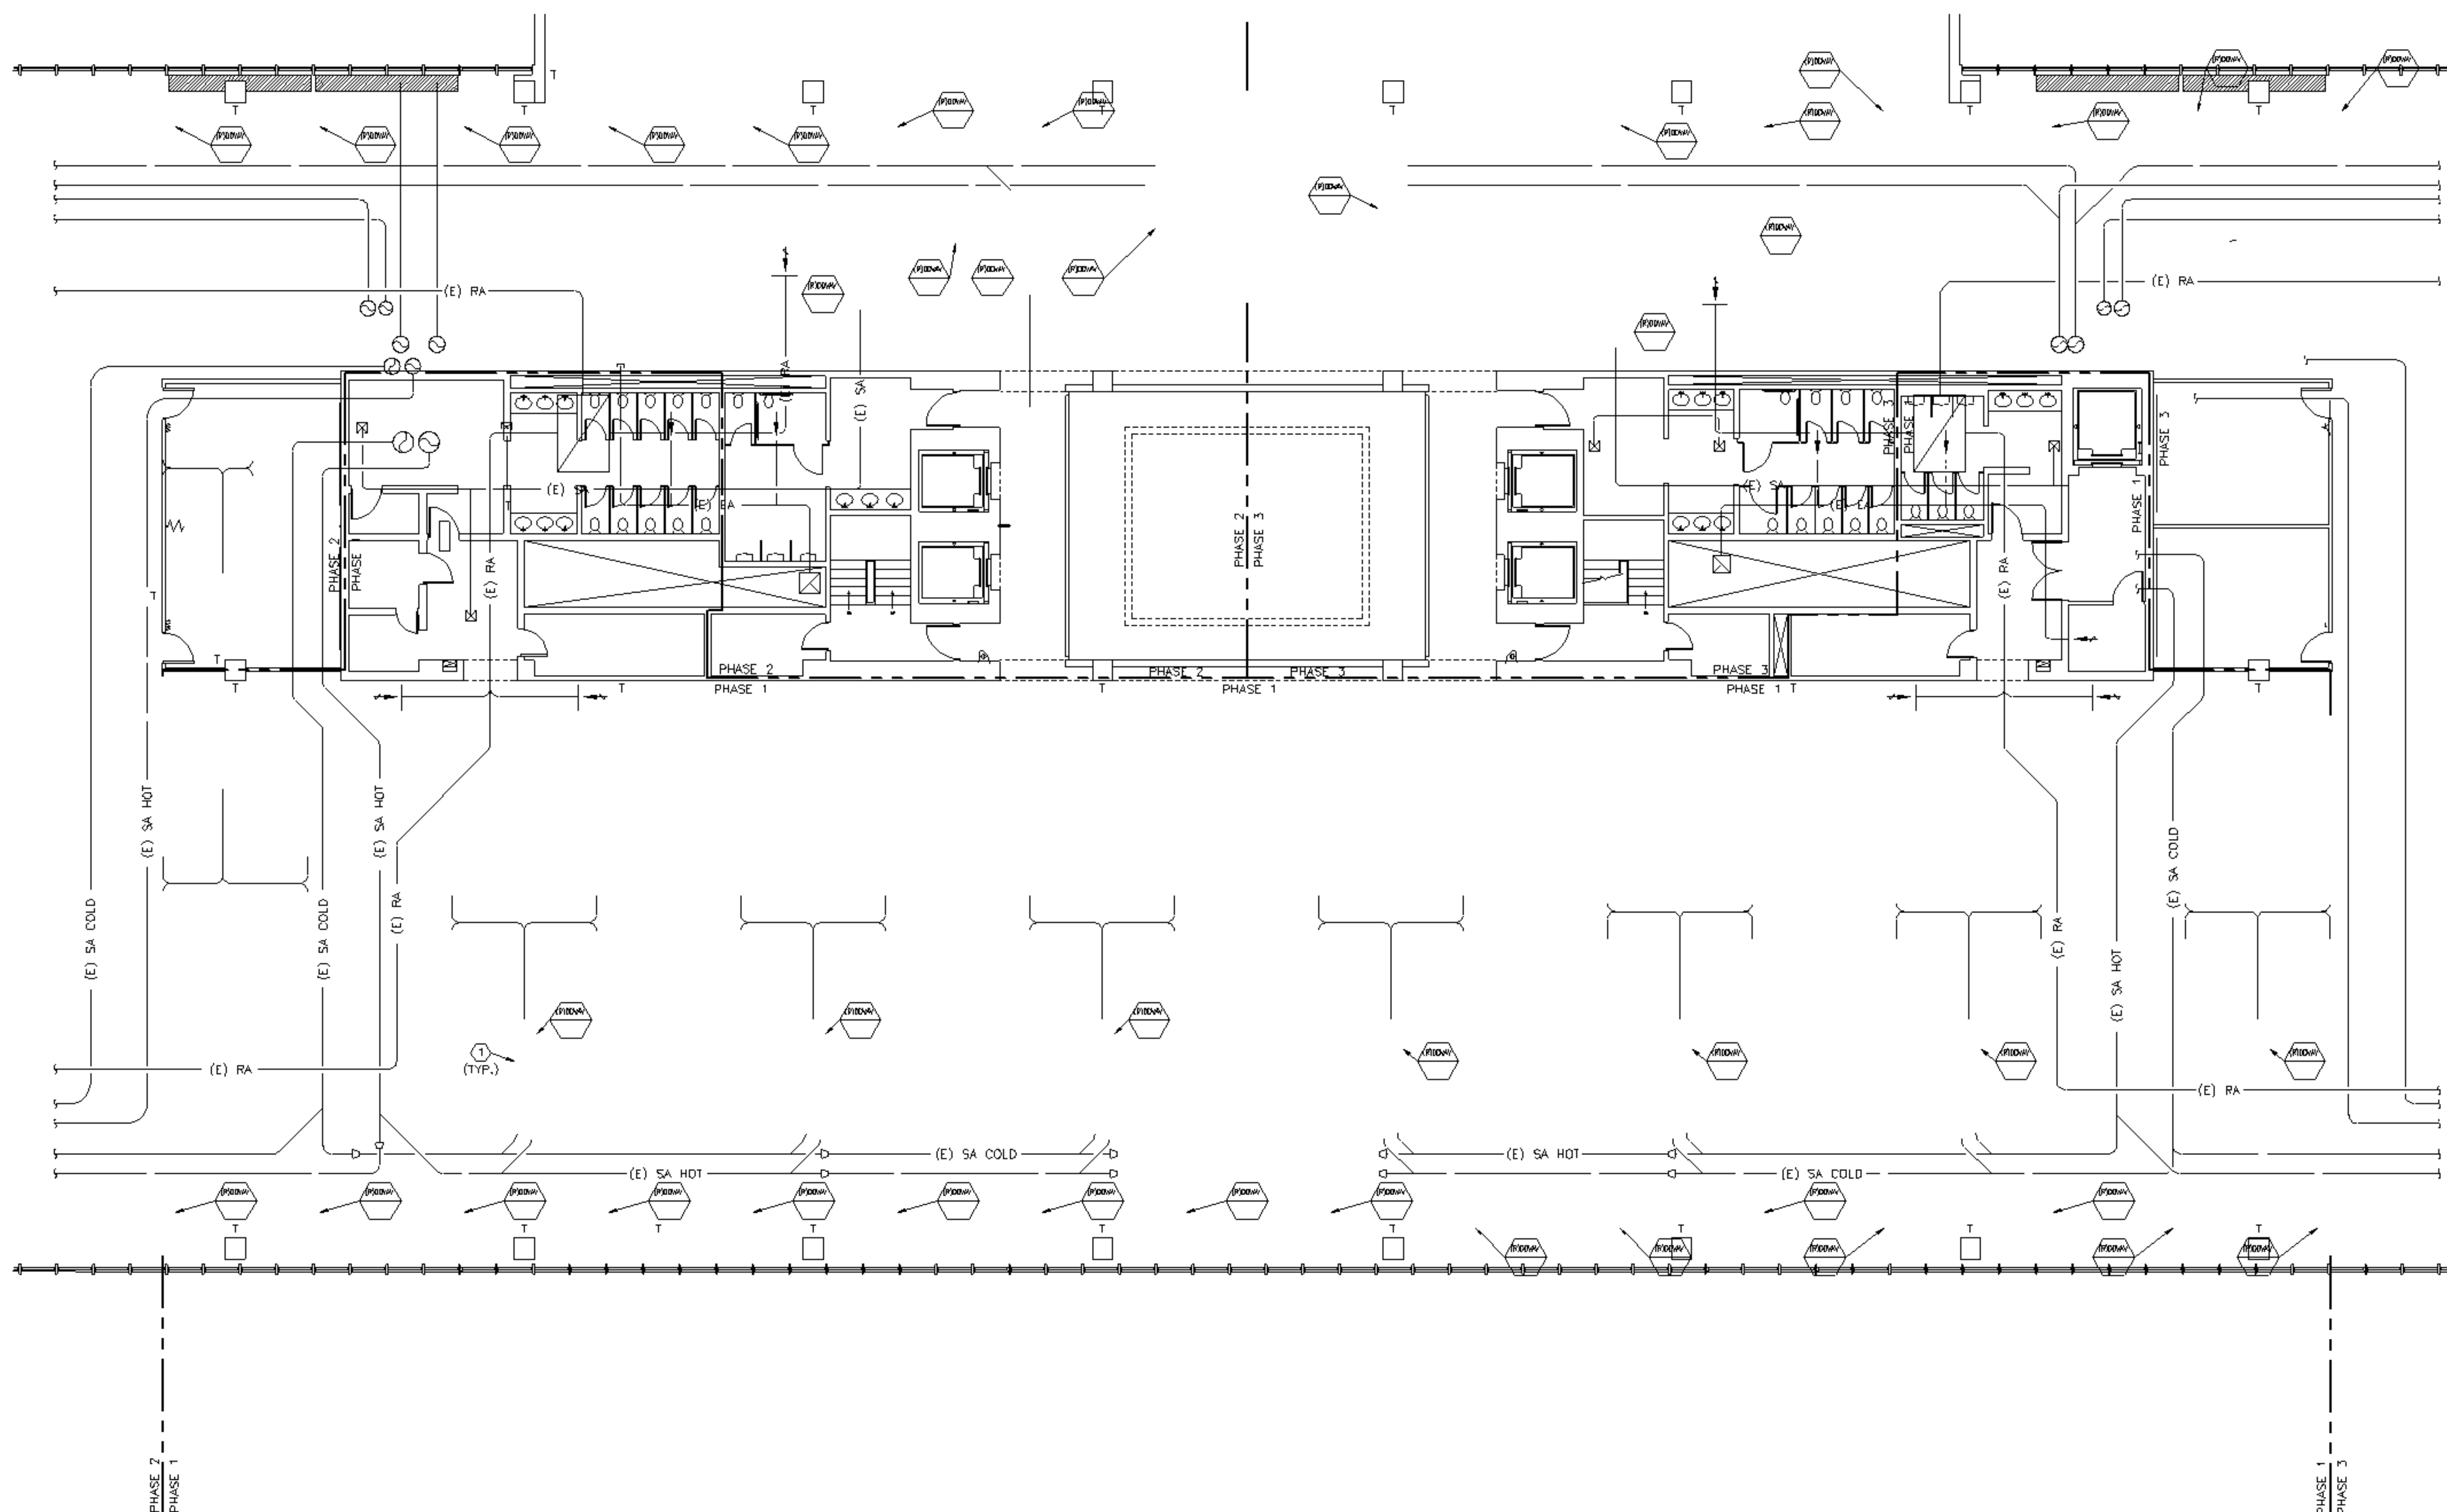

F18 KEY PLAN

NOT TO SCALE

REV.	DESCRIPTION	DATE
0	ISSUED FOR CONSTRUCTION	3-10-05

ISSUED FOR CONSTRUCTION
3-10-05

CURRENT ISSUE STATUS:



ARCHITECTURE ENGINEERING PLANNING
SMRT
144 Fore Street, P.O. Box 618
Portland, Maine 04104
Tel. (207) 772-3846
Fax. (207) 772-1070

UnumProvident HO-1
3rd FLOOR OFFICE RENOVATIONS
PORTLAND, ME.

PHASE I
HVAC DEMOLITION PLAN

SHEET TITLE:	1/8"=1'-0"	DATE:	3-10-05
SCALE:	JLH	GRAPHIC SCALE:	0" 1"
PROJECT MANAGER:	CEB/BOG		
JOB CAP/DRAWN:	FWJ		
A/E OF RECORD:	MD101-05004	SHEET No.	MD101
SMRT CAD FILE:	05004		
PROJECT No.			

A1 FLOOR PLAN
1/8"=1'-0"