


NOTE:
 1. SEE SHEET M-001 FOR LEGEND AND ABBREVIATIONS.

KEYED NOTES:
 ① MITCO VALVE REMOVE AND STORE AT UNUMPROVIDENT'S DIRECTION.
 ② SALVAGE DIFFUSER FOR RE-USE.
 ③ NOT USED.

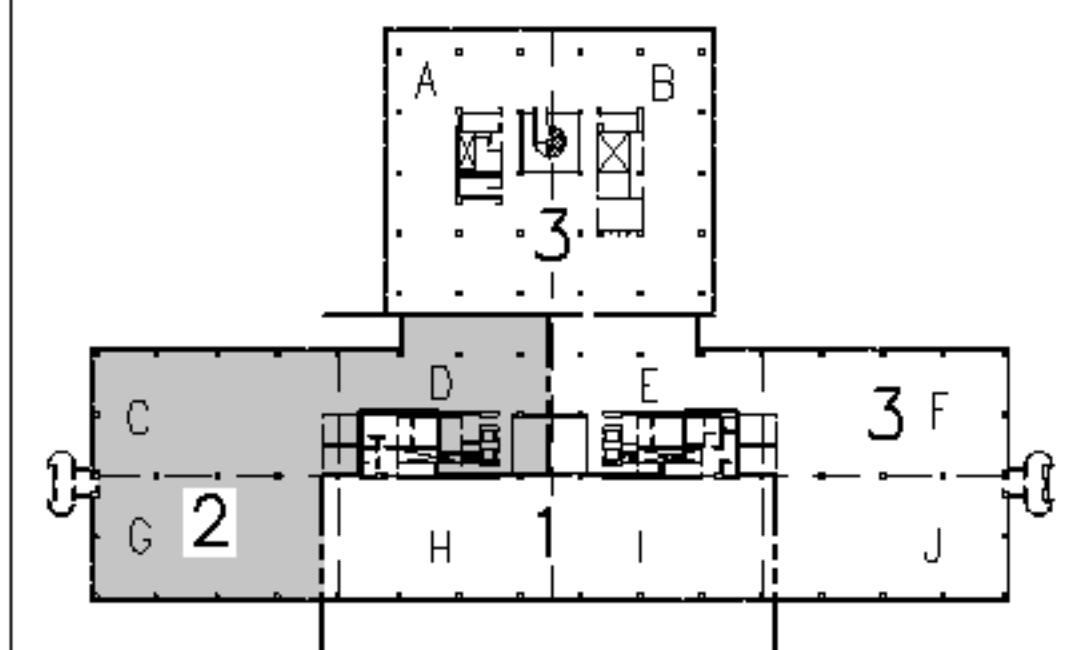

F18	KEY PLAN	
NOT TO SCALE		
0	ISSUED FOR CONSTRUCTION	3-10-05
REV.	DESCRIPTION	DATE

ISSUED FOR CONSTRUCTION
3-10-05



ARCHITECTURE ENGINEERING PLANNING
 SMRT
 144 Fore Street, P.O. Box 618
 Portland, Maine 04104
 Tel. (207) 772-3846
 Fax. (207) 772-1070

UnumProvident HO-1
 3rd FLOOR OFFICE RENOVATIONS
 PORTLAND, ME.

PHASE II
HVAC DEMOLITION PLAN

SHEET TITLE:	
SCALE: 1/8"=1'-0"	DATE: 3-10-05
PROJECT MANAGER: JLH	GRAPHIC SCALE: 0" 1"
JOB CAP/DRAWN: CEB/BOG	
A/E OF RECORD: FWJ	SHEET No.
SMRT CAD FILE: MD102-05004	MD102
PROJECT No. 05004	

A1 FLOOR PLAN
 1/8"=1'-0"