


**NOTE:**  
 1. SEE SHEET M-001 FOR LEGEND AND ABBREVIATIONS.


**KEYED NOTES:**  
 ① MITCO VALVE REMOVE AND STORE AT UNUMPROVIDENT'S DIRECTION.  
 ② SALVAGE DIFFUSER FOR RE-USE.  
 ③ NOT USED.

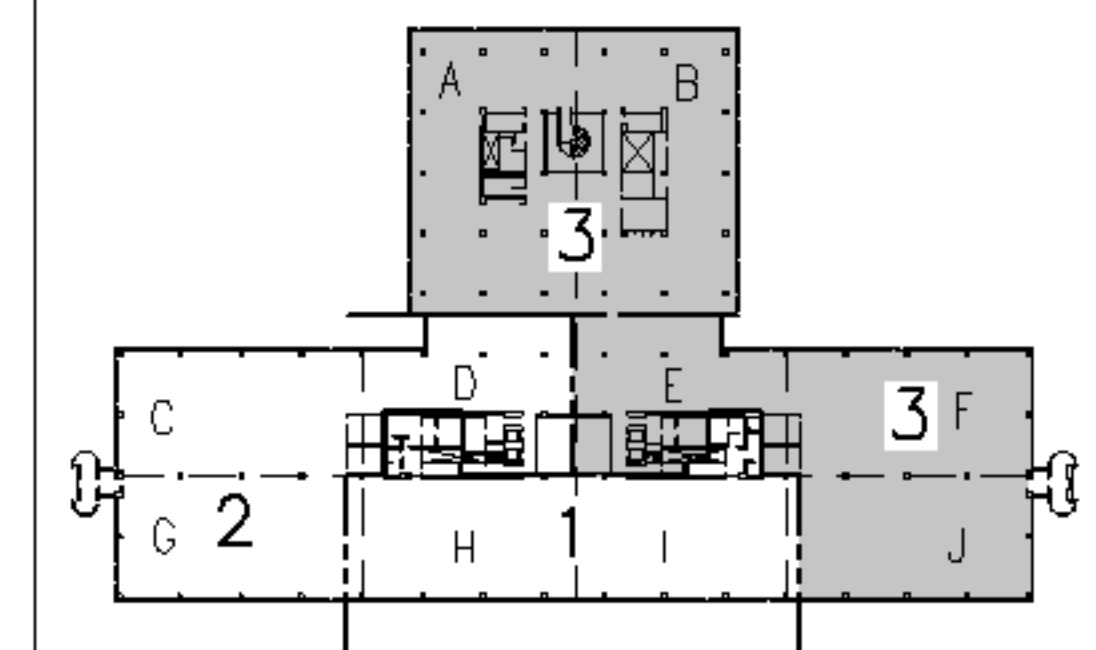

F18	KEY PLAN	
NOT TO SCALE		
0	ISSUED FOR CONSTRUCTION	3-10-05
REV.	DESCRIPTION	DATE

**ISSUED FOR CONSTRUCTION**  
**3-10-05**

CURRENT ISSUE STATUS:

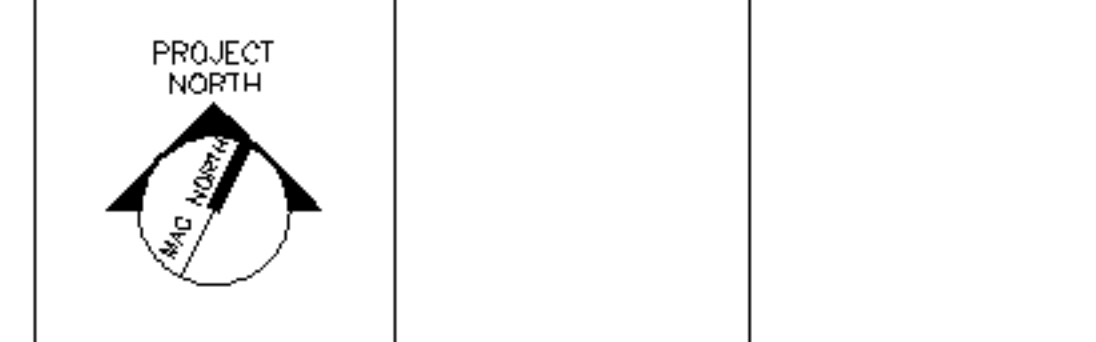

**ARCHITECTURE ENGINEERING PLANNING**  
 SMRT  
 144 Fore Street, P.O. Box 618  
 Portland, Maine 04104  
 Tel. (207) 772-3846  
 Fax. (207) 772-1070

UnumProvident HO-1  
 3rd FLOOR OFFICE RENOVATIONS  
 PORTLAND, ME.

PROJECT:  
**PHASE III - PARTIAL  
 HVAC DEMOLITION PLAN**

SHEET TITLE:	
SCALE: 1/8"=1'-0"	DATE: 3-10-05
PROJECT MANAGER: JLH	GRAPHIC SCALE: 0" 1"
JOB CAP/DRAWN: CEB/BOG	
A/E OF RECORD: FJW	SHEET No.
SMRT CAD FILE: MD103-05004	MD103
PROJECT No. 05004	

A1 FLOOR PLAN  
 1/8"=1'-0"