
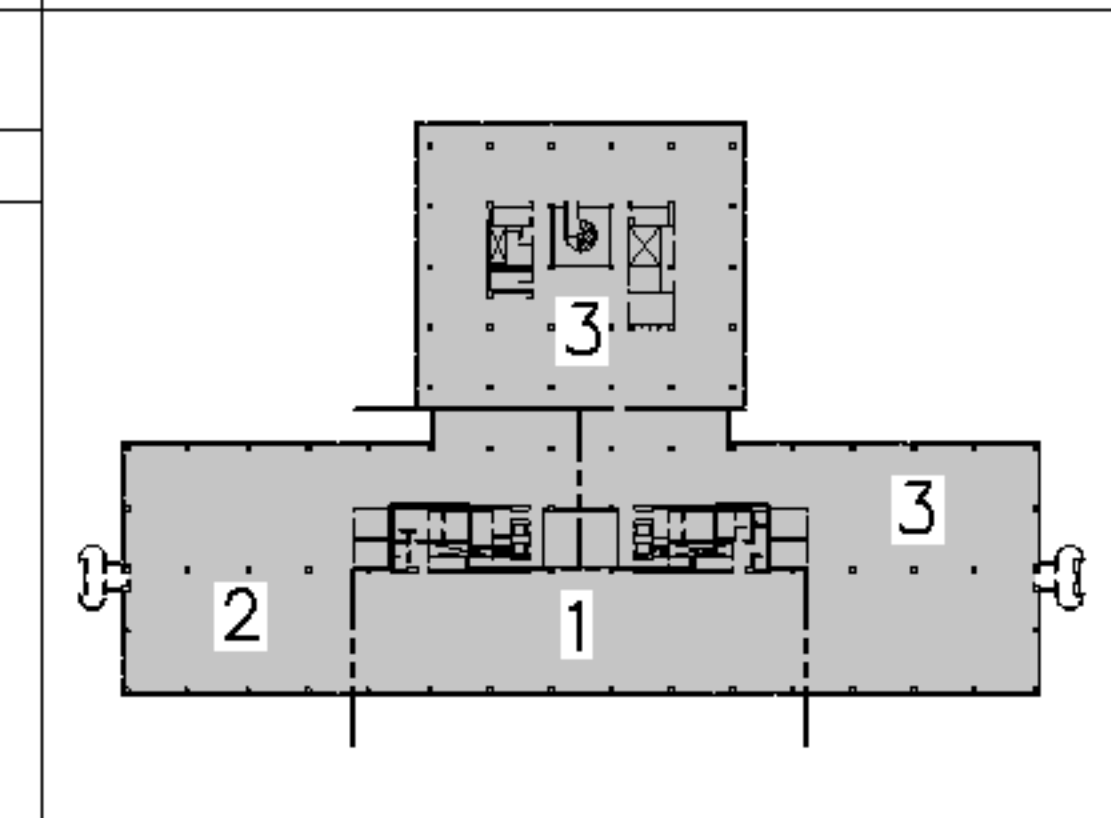


**NOTE:**  
 1. SEE SHEET M-001 FOR LEGEND AND ABBREVIATIONS.

**KEYED NOTES:**

- ① REMOVE DOMESTIC CW SUPPLY & SANITARY BRANCHES SERVING DRINKING FOUNTAIN TO WITHIN 12" OF MAINS. CAP AND SEAL PIPING.
- ② HALSEY TAYLOR OVL-11 SER-0 BI-LEVEL ADA BARRIER FREE WATER COOLER STAINLESS STEEL FINISH
- ③ OMIT WATER COOLER FROM PROJECT.

A1 DEMOLITION PLAN  
 1/16"=1'-0"

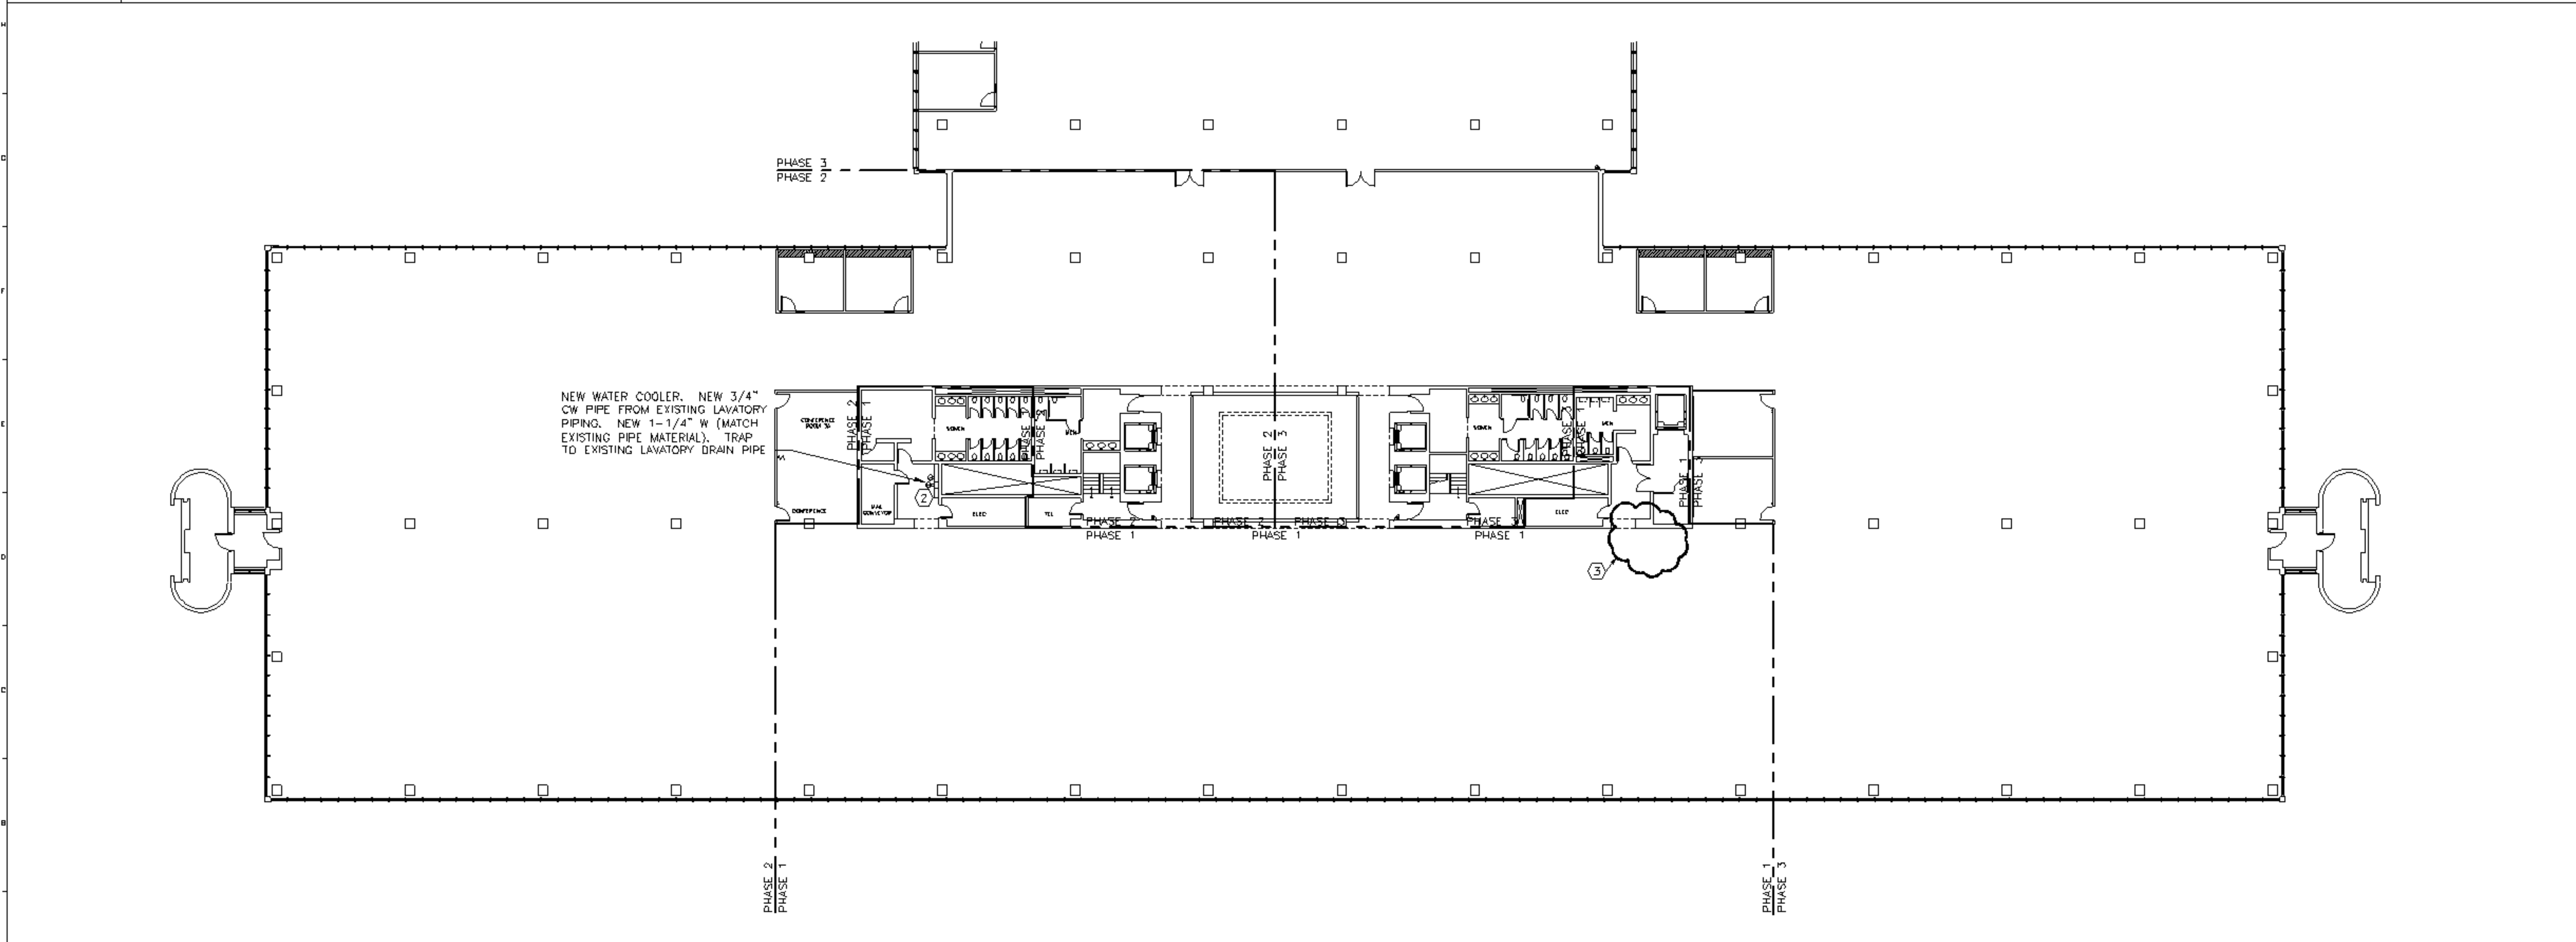

F18	KEY PLAN	
NOT TO SCALE		
0	ISSUED FOR CONSTRUCTION	3-10-05
REV.	DESCRIPTION	DATE

**ISSUED FOR CONSTRUCTION**  
**3-10-05**



**ARCHITECTURE ENGINEERING PLANNING**  
 SMRT  
 144 Fore Street, P.O. Box 618  
 Portland, Maine 04104  
 Tel. (207) 772-3846  
 Fax. (207) 772-1070

UnumProvident HO-1  
 3rd FLOOR OFFICE RENOVATIONS  
 PORTLAND, ME.

**THIRD FLOOR**  
**PLUMBING PLANS**

A1 FLOOR PLAN  
 1/16"=1'-0"

SCALE:	AS NOTED	DATE:	3-10-05
PROJECT MANAGER:	JLH	GRAPHIC SCALE:	0" = 1"
JOB CAP/DRAWN:	CEB/BOG	SHEET No.	P-101
A/E OF RECORD:	FWJ	SMRT CAD FILE:	P-101-05004
SMRT CAD FILE:	P-101-05004	PROJECT No.	05004