


NOTE:

- SEE SHEET E-001 FOR LEGEND AND GENERAL NOTES.
- NEW EXIT SIGNS TO BE FED FROM UNSWITCHED EMERGENCY LIGHTING CIRCUIT WITHIN AREA.

KEYED NOTE:

- CONNECT NEW AND RELOCATED FIXTURES TO SAME BRANCH CIRCUIT AS EXISTING FIXTURES. CONNECT EXISTING FIXTURES TO EXISTING UNSWITCHED EMERGENCY LIGHTING CIRCUIT.
- INSTALL NEW COMBINATION SWITCH/OCCUPANCY SENSOR IN PLACE OF EXISTING TOGGLE SWITCH.
- USE FOUR EXISTING SPARE CIRCUIT BREAKERS (CIRCUITS 480/277V 125A) TO FEED NEW LIGHTS SHOWN ON DRAWINGS.

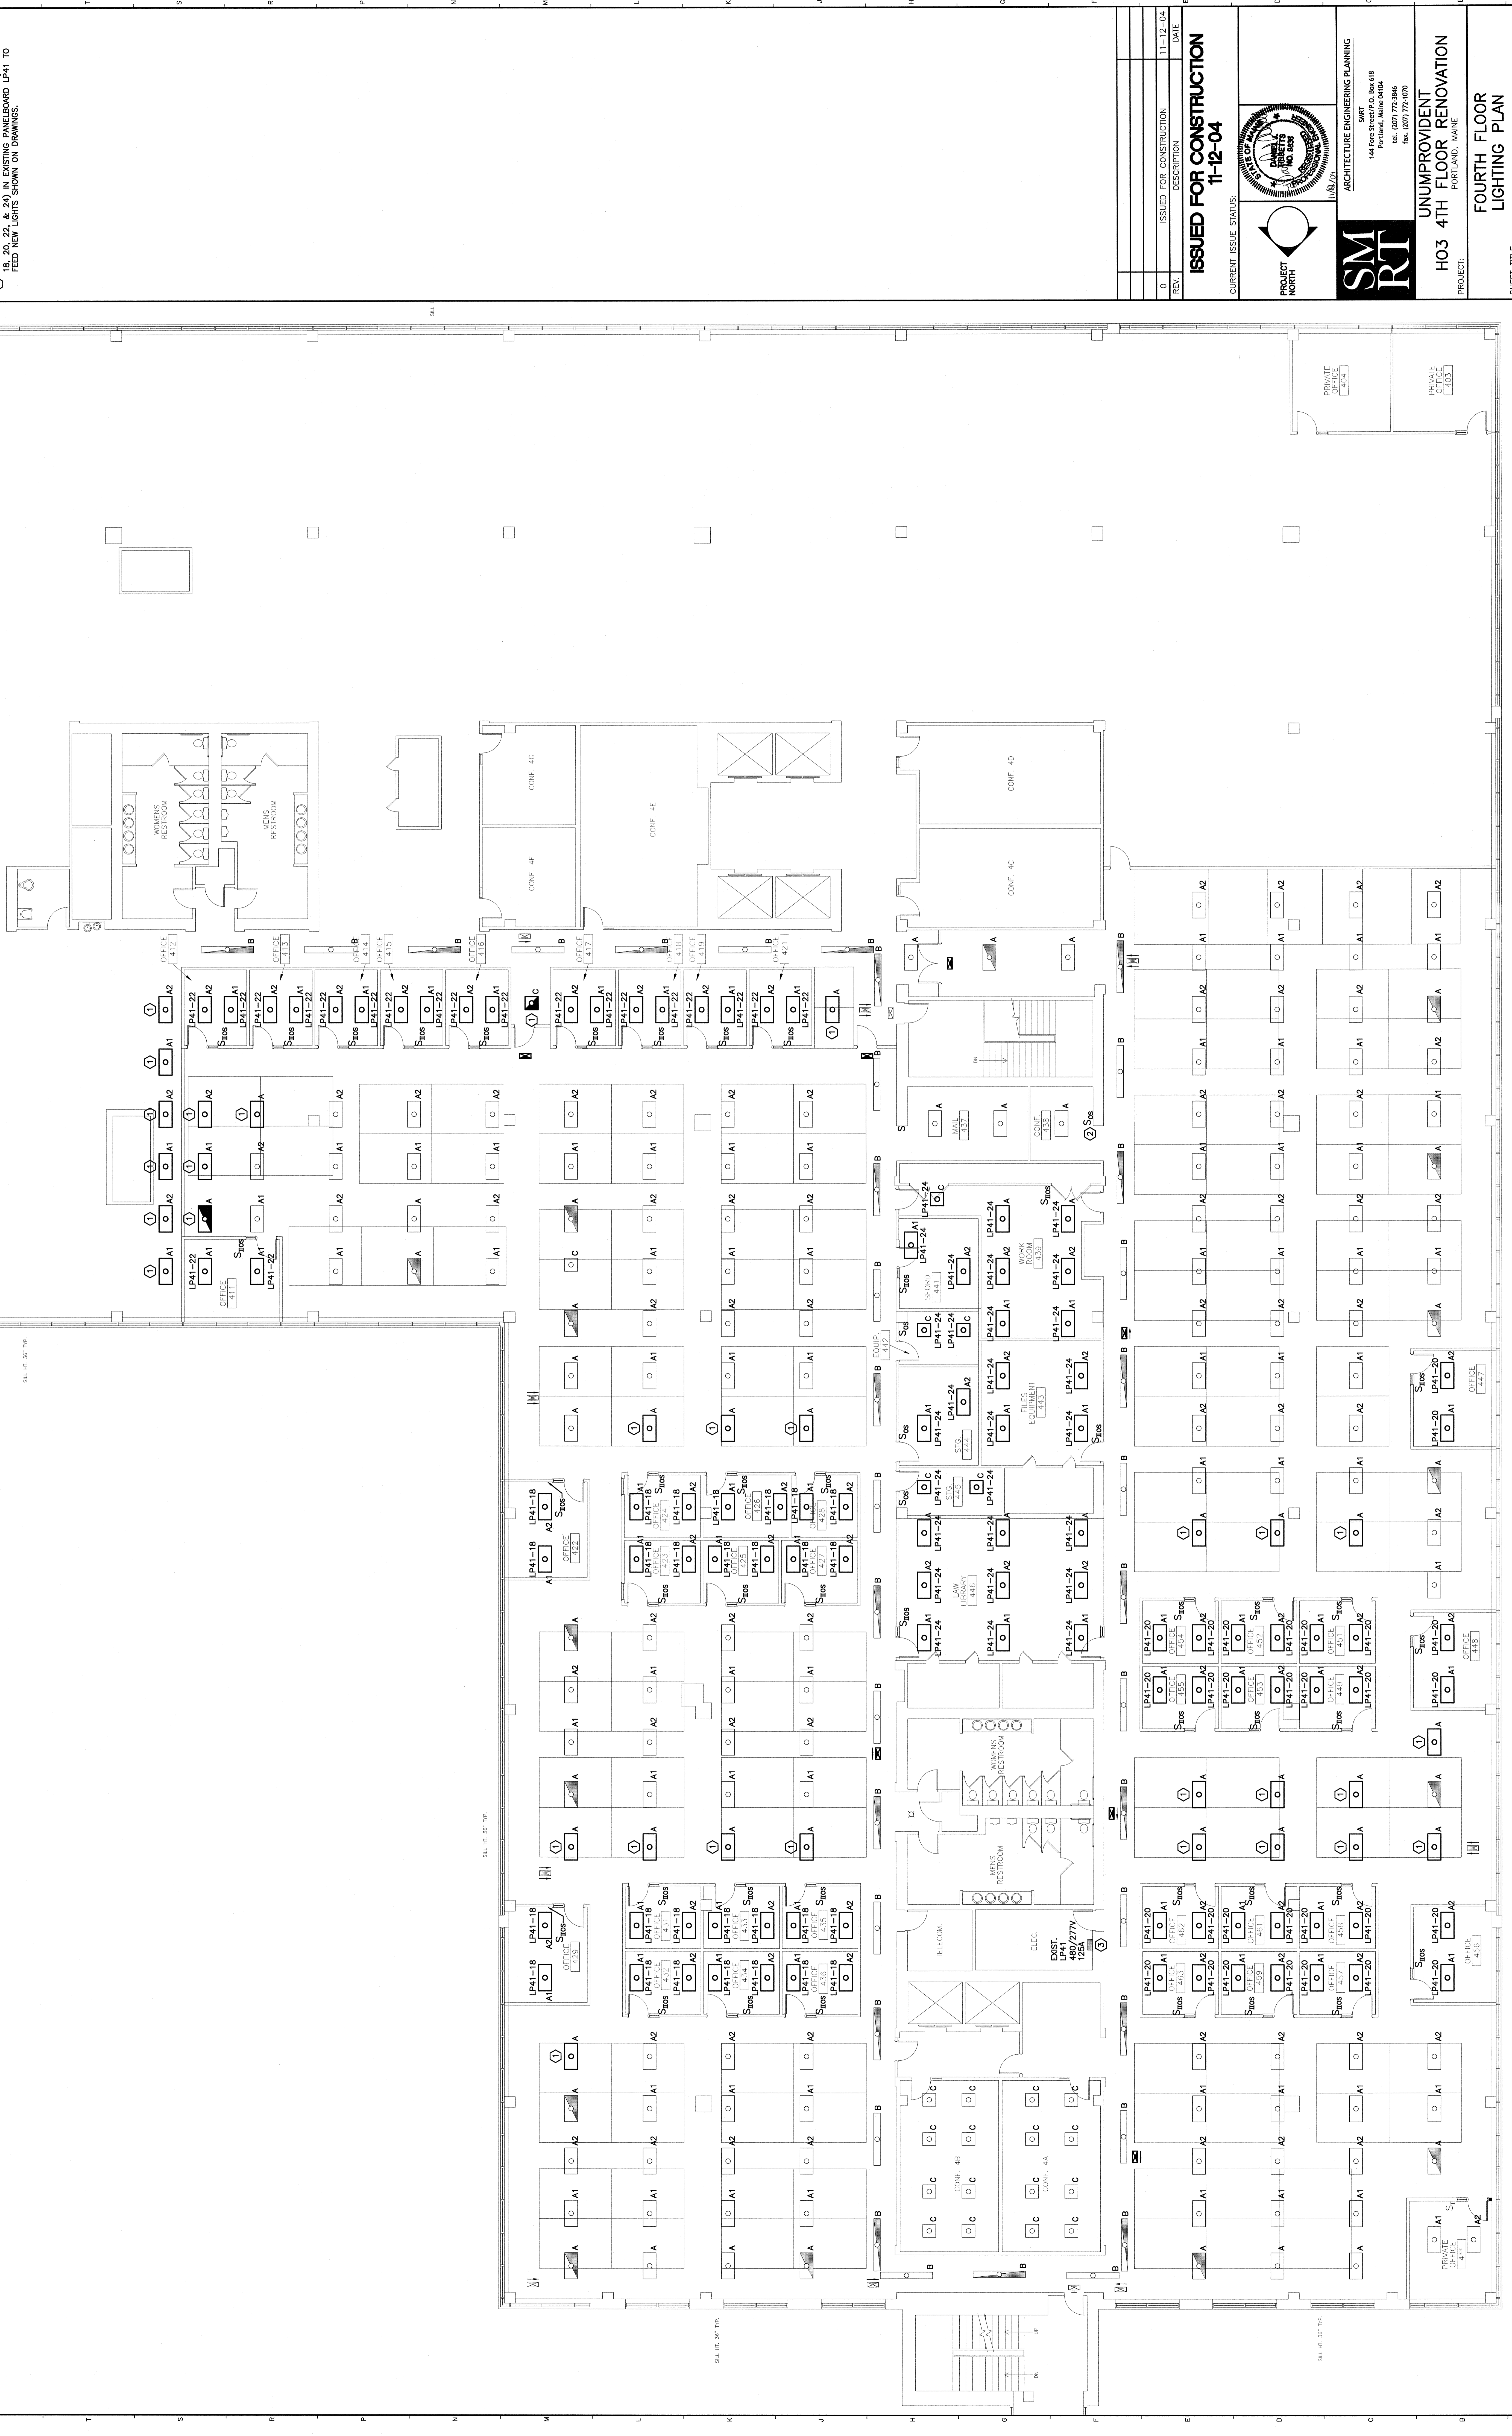

ISSUED FOR CONSTRUCTION	11-12-04
REV.	DATE

ISSUED FOR CONSTRUCTION
11-12-04

CURRENT ISSUE STATUS:

PROJECT NORTH

SM RT
ARCHITECTURE ENGINEERING PLANNING
144 State St., Box 418
Portland, Maine 04104
Tel. (207) 772-3346
Fax. (207) 772-0070

UNUMPROVIDENT
H03 4TH FLOOR RENOVATION
PORTLAND, MAINE

PROJECT:

FOURTH FLOOR
LIGHTING PLAN

SHEET TITLE: H03 4TH FLOOR RENOVATION
SCALE: 1/8"=1'-0"
DATE: 11-12-04
PROJECT MANAGER: JLM
JOB CAP/DRAWN: LAM
DATE OF RECORD: DIT
SHEET NO.: EL101
PROJECT NO.: 04168

A1

FLOOR PLAN

1/8"=1'-0"