

UNUMPROVIDENT CORPORATION

HO III

FOURTH FLOOR RENOVATION


2211 Congress Street
Portland, Maine

ISSUED FOR CONSTRUCTION
11-12-2004

SYMBOL LEGEND

- DETAIL
- CIRCLE NOTE
- PARTITION TAG
- DOOR TAG
- ROOM NAME
ROOM NUMBER
- SEALANT AND
BACKER ROD

KEY PLAN

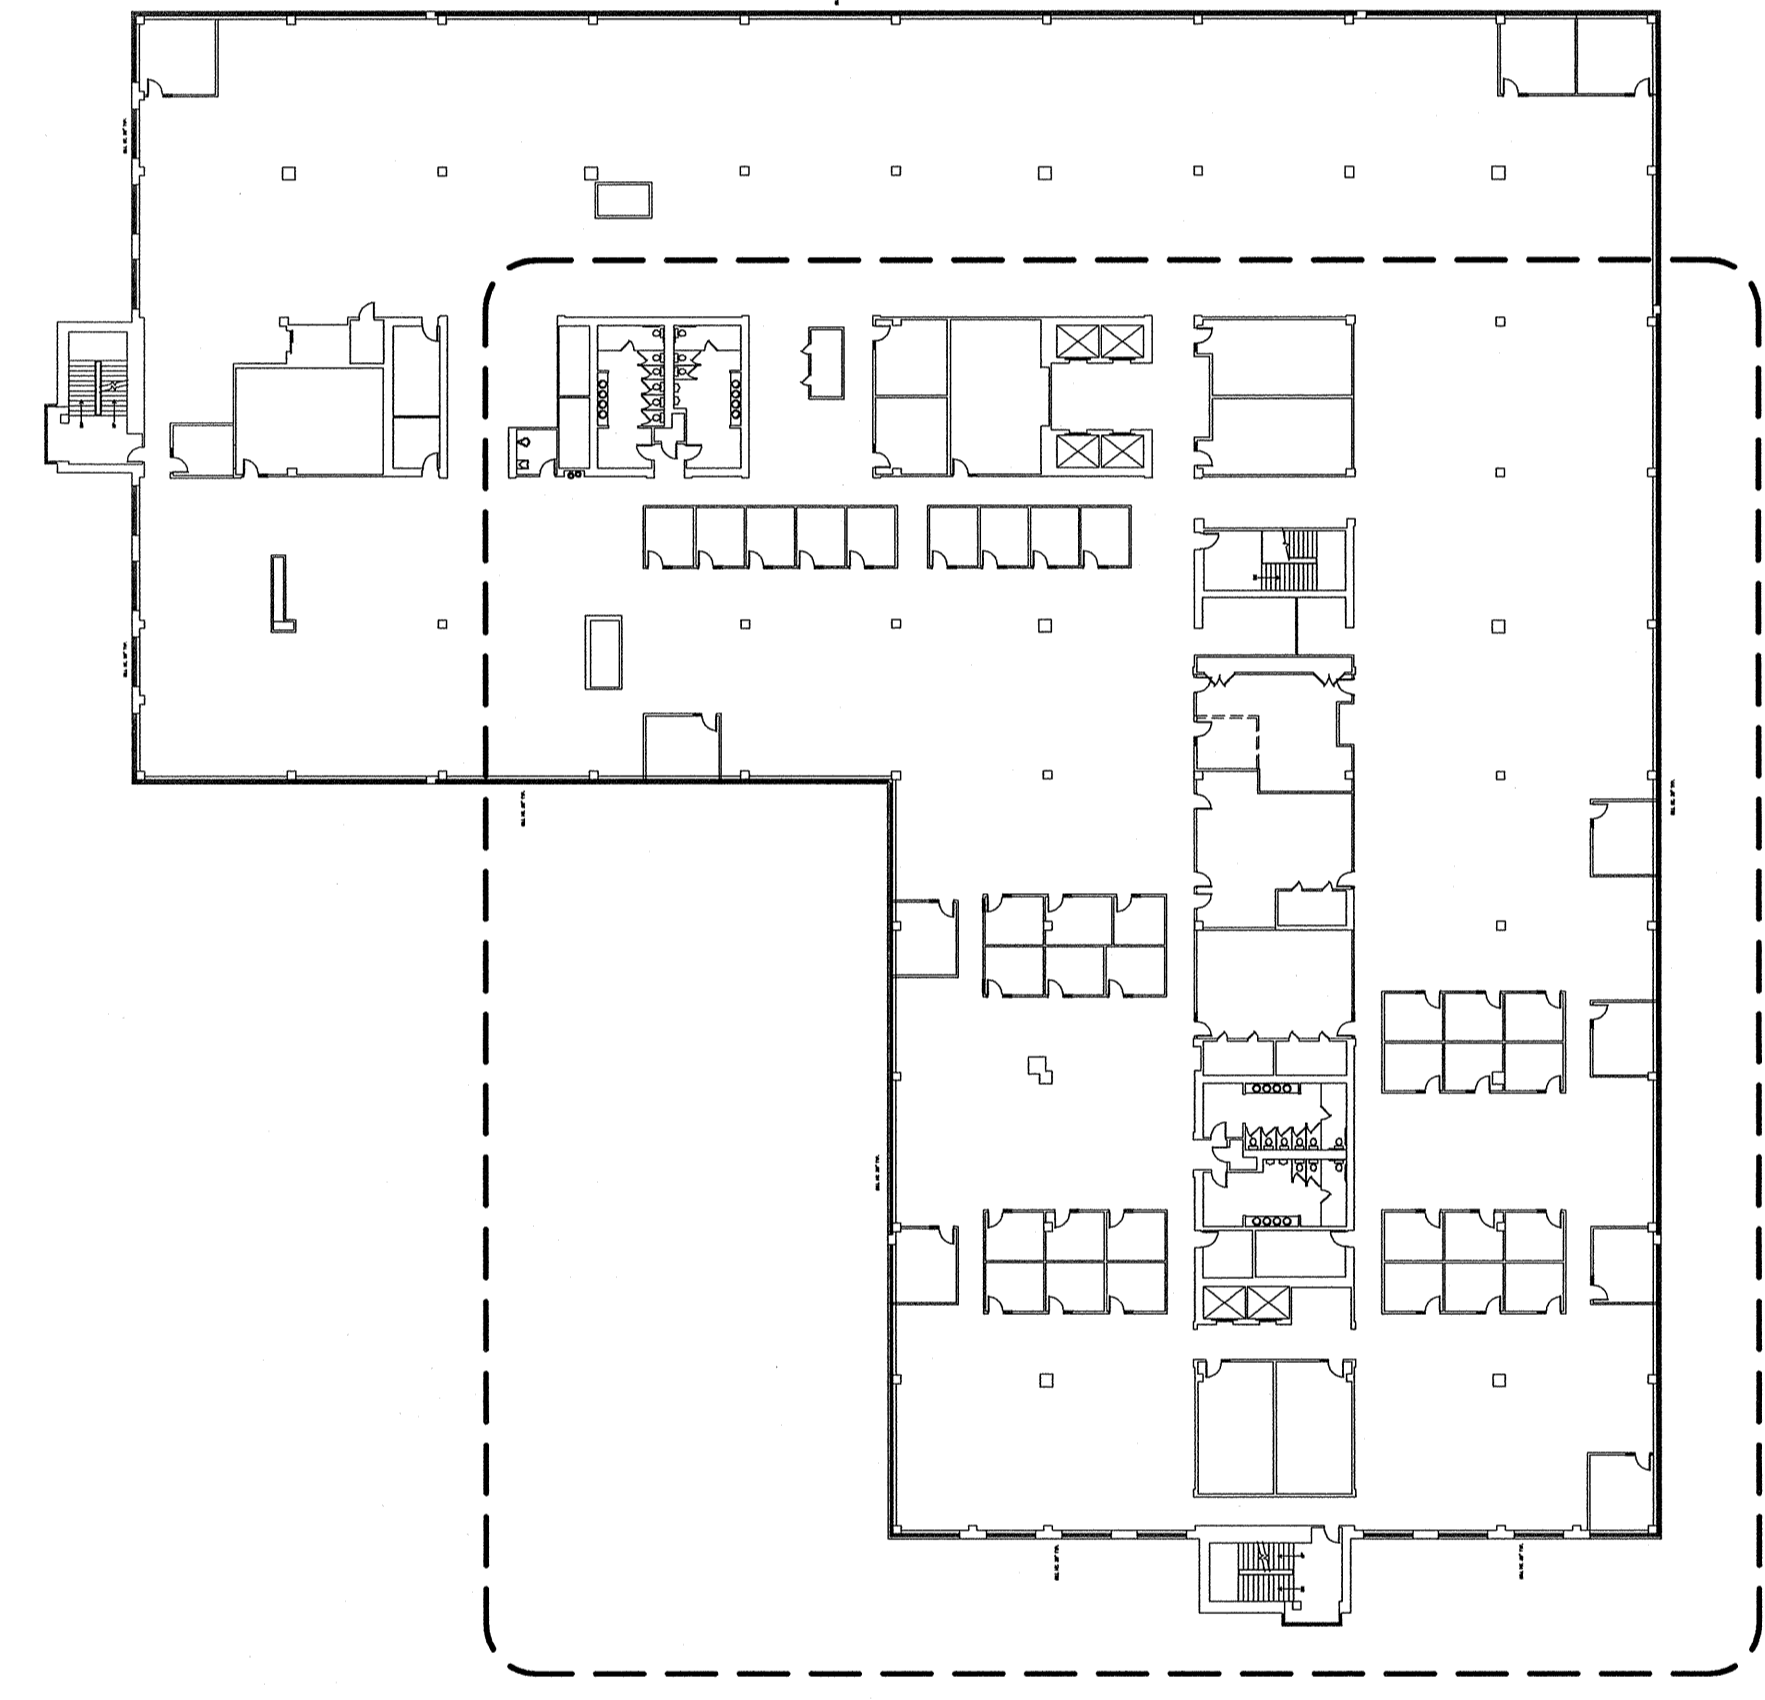


DRAWING LIST

- GENERAL
- G001 TITLE SHEET
- ARCHITECTURAL
- AC101 FOURTH FLOOR PLAN
- AC102 FOURTH FLOOR REFLECTED CEILING PLAN
- MECHANICAL
- M-001 LEGEND AND ABBREVIATIONS
- MD101 FOURTH FLOOR HVAC DEMOLITION PLAN
- MH101 FOURTH FLOOR HVAC DUCTWORK PLAN
- MP101 FOURTH FLOOR HVAC PIPING PLAN
- M-501 SPECIFICATIONS AND DETAILS
- M-601 SCHEDULES
- ELECTRICAL
- E-001 LEGEND & GENERAL NOTES
- ED101 FOURTH FLOOR DEMOLITION PLAN
- EP101 FOURTH FLOOR POWER PLAN
- EL101 FOURTH FLOOR LIGHTING PLAN
- EY101 FOURTH FLOOR SYSTEMS PLAN
- E-601 PANEL SCHEDULES & LIGHT FIXTURE SCHEDULE

REV.	ISSUED FOR CONSTRUCTION	DESCRIPTION	DATE
0			11-12-04

ISSUED FOR CONSTRUCTION
11-12-04

CURRENT ISSUE STATUS:

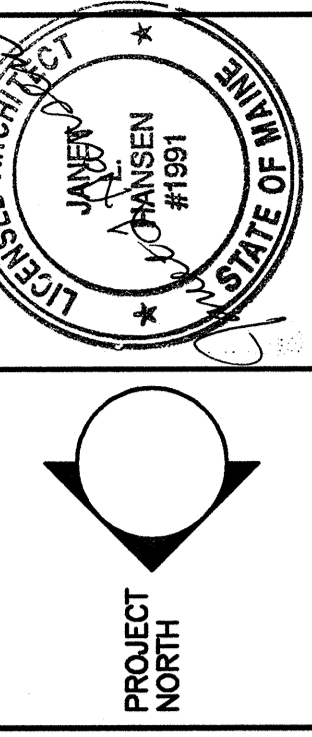

SM RT
ARCHITECTURE ENGINEERING PLANNING
144 Fox Street
Portland, Maine 04104
Tel. (207) 772-3846
Fax. (207) 772-0770

UNUMPROVIDENT
H03 4TH FLOOR RENOVATION
PORTLAND, MAINE

TITLE SHEET

SHEET TITLE	NOT TO SCALE	DATE
		11-12-04
PROJECT MANAGER:	JUH	GRAPHIC SCALE: 1" = 12'-0"
JOB CAP/DRAWN:	RAJ	
DATE OF RECORD:	JUH	SHEET No.
SMART CAD FILE:	G001-04168	
PROJECT No.	04168	

G1001