


SECOND FLOOR – PIPING
 SCALE: 1/8"=1'-0"

Design • Build • Install • Service

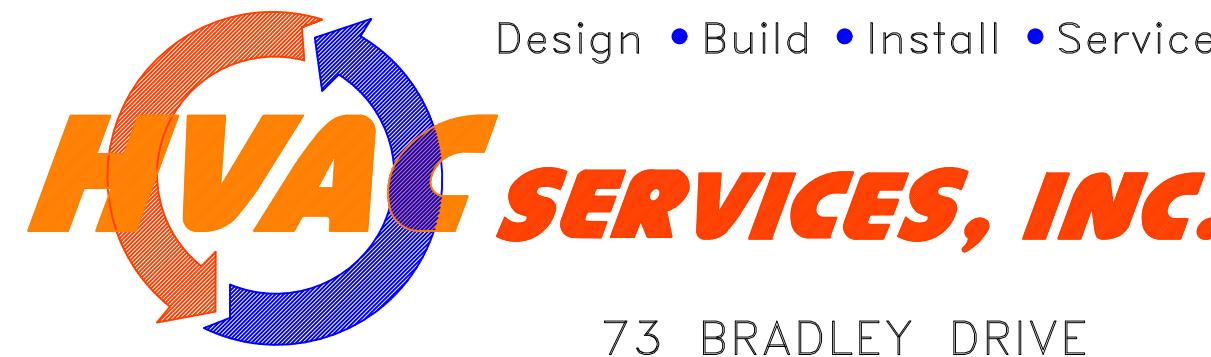

73 BRADLEY DRIVE
 WESTBROOK, MAINE 04092
 (207) 854-HVAC (4822)

REVISIONS	
NO.	NOTES

DR. BEDECS 1945 CONGRESS ST. PORTLAND, MAINE	
PROJECT:	
SECOND FLOOR PIPING PLANS	
SHEET TITLE:	
SCALE: 1/8"=1'-0"	DATE: 4-3-2017
DRAWN BY: TJF	SHEET No.
CHECKED BY:	MP-3
PRINT TO SCALE: 36x24	