


ROOF - DUCTWORK
SCALE: 1/8"=1'-0"

Design • Build • Install • Service

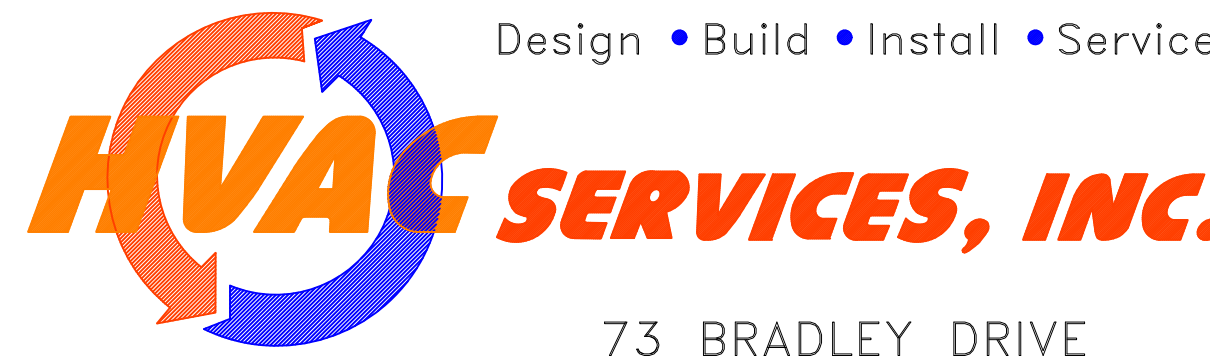

73 BRADLEY DRIVE
WESTBROOK, MAINE 04092
(207) 854-HVAC (4822)

REVISIONS		DR. BEDECS 1945 CONGRESS ST. PORTLAND, MAINE	
NO.	NOTES	PROJECT:	
		ROOF DUCTWORK PLANS	
		SHEET TITLE:	DATE: 4-3-2017
		SCALE: 1/8"=1'-0"	SHEET No.
		DRAWN BY: TJF	M-4
		CHECKED BY:	
		PRINT TO SCALE: 36x24	