


<p>KEY</p> <p>EXISTING WALLS</p> <p>DEMO WALLS</p> <p>NEW WALLS</p> <p>NEW WALL SWITCH</p> <p>NEW WALL OUTLET</p>	<p>NOTES</p> <ol style="list-style-type: none"> PATCH CEILING IN 101,102,103 AS NEEDED REUSE EXISTING DOOR IN 101 - RELOCATE AS SHOWN ADD NEW OUTLETS & SWITCH AS SHOWN 101,102,103 PATCH EXISTING CARPET & WALL BASE WITH STANDARD THROUGHOUT AS NEEDED PATCH/PREP/PAINT WALLS AS NEEDED @ NEW & DEMO LOCATIONS RELOCATE EXISTING CABINETS IN 102 AS NEEDED
--	---

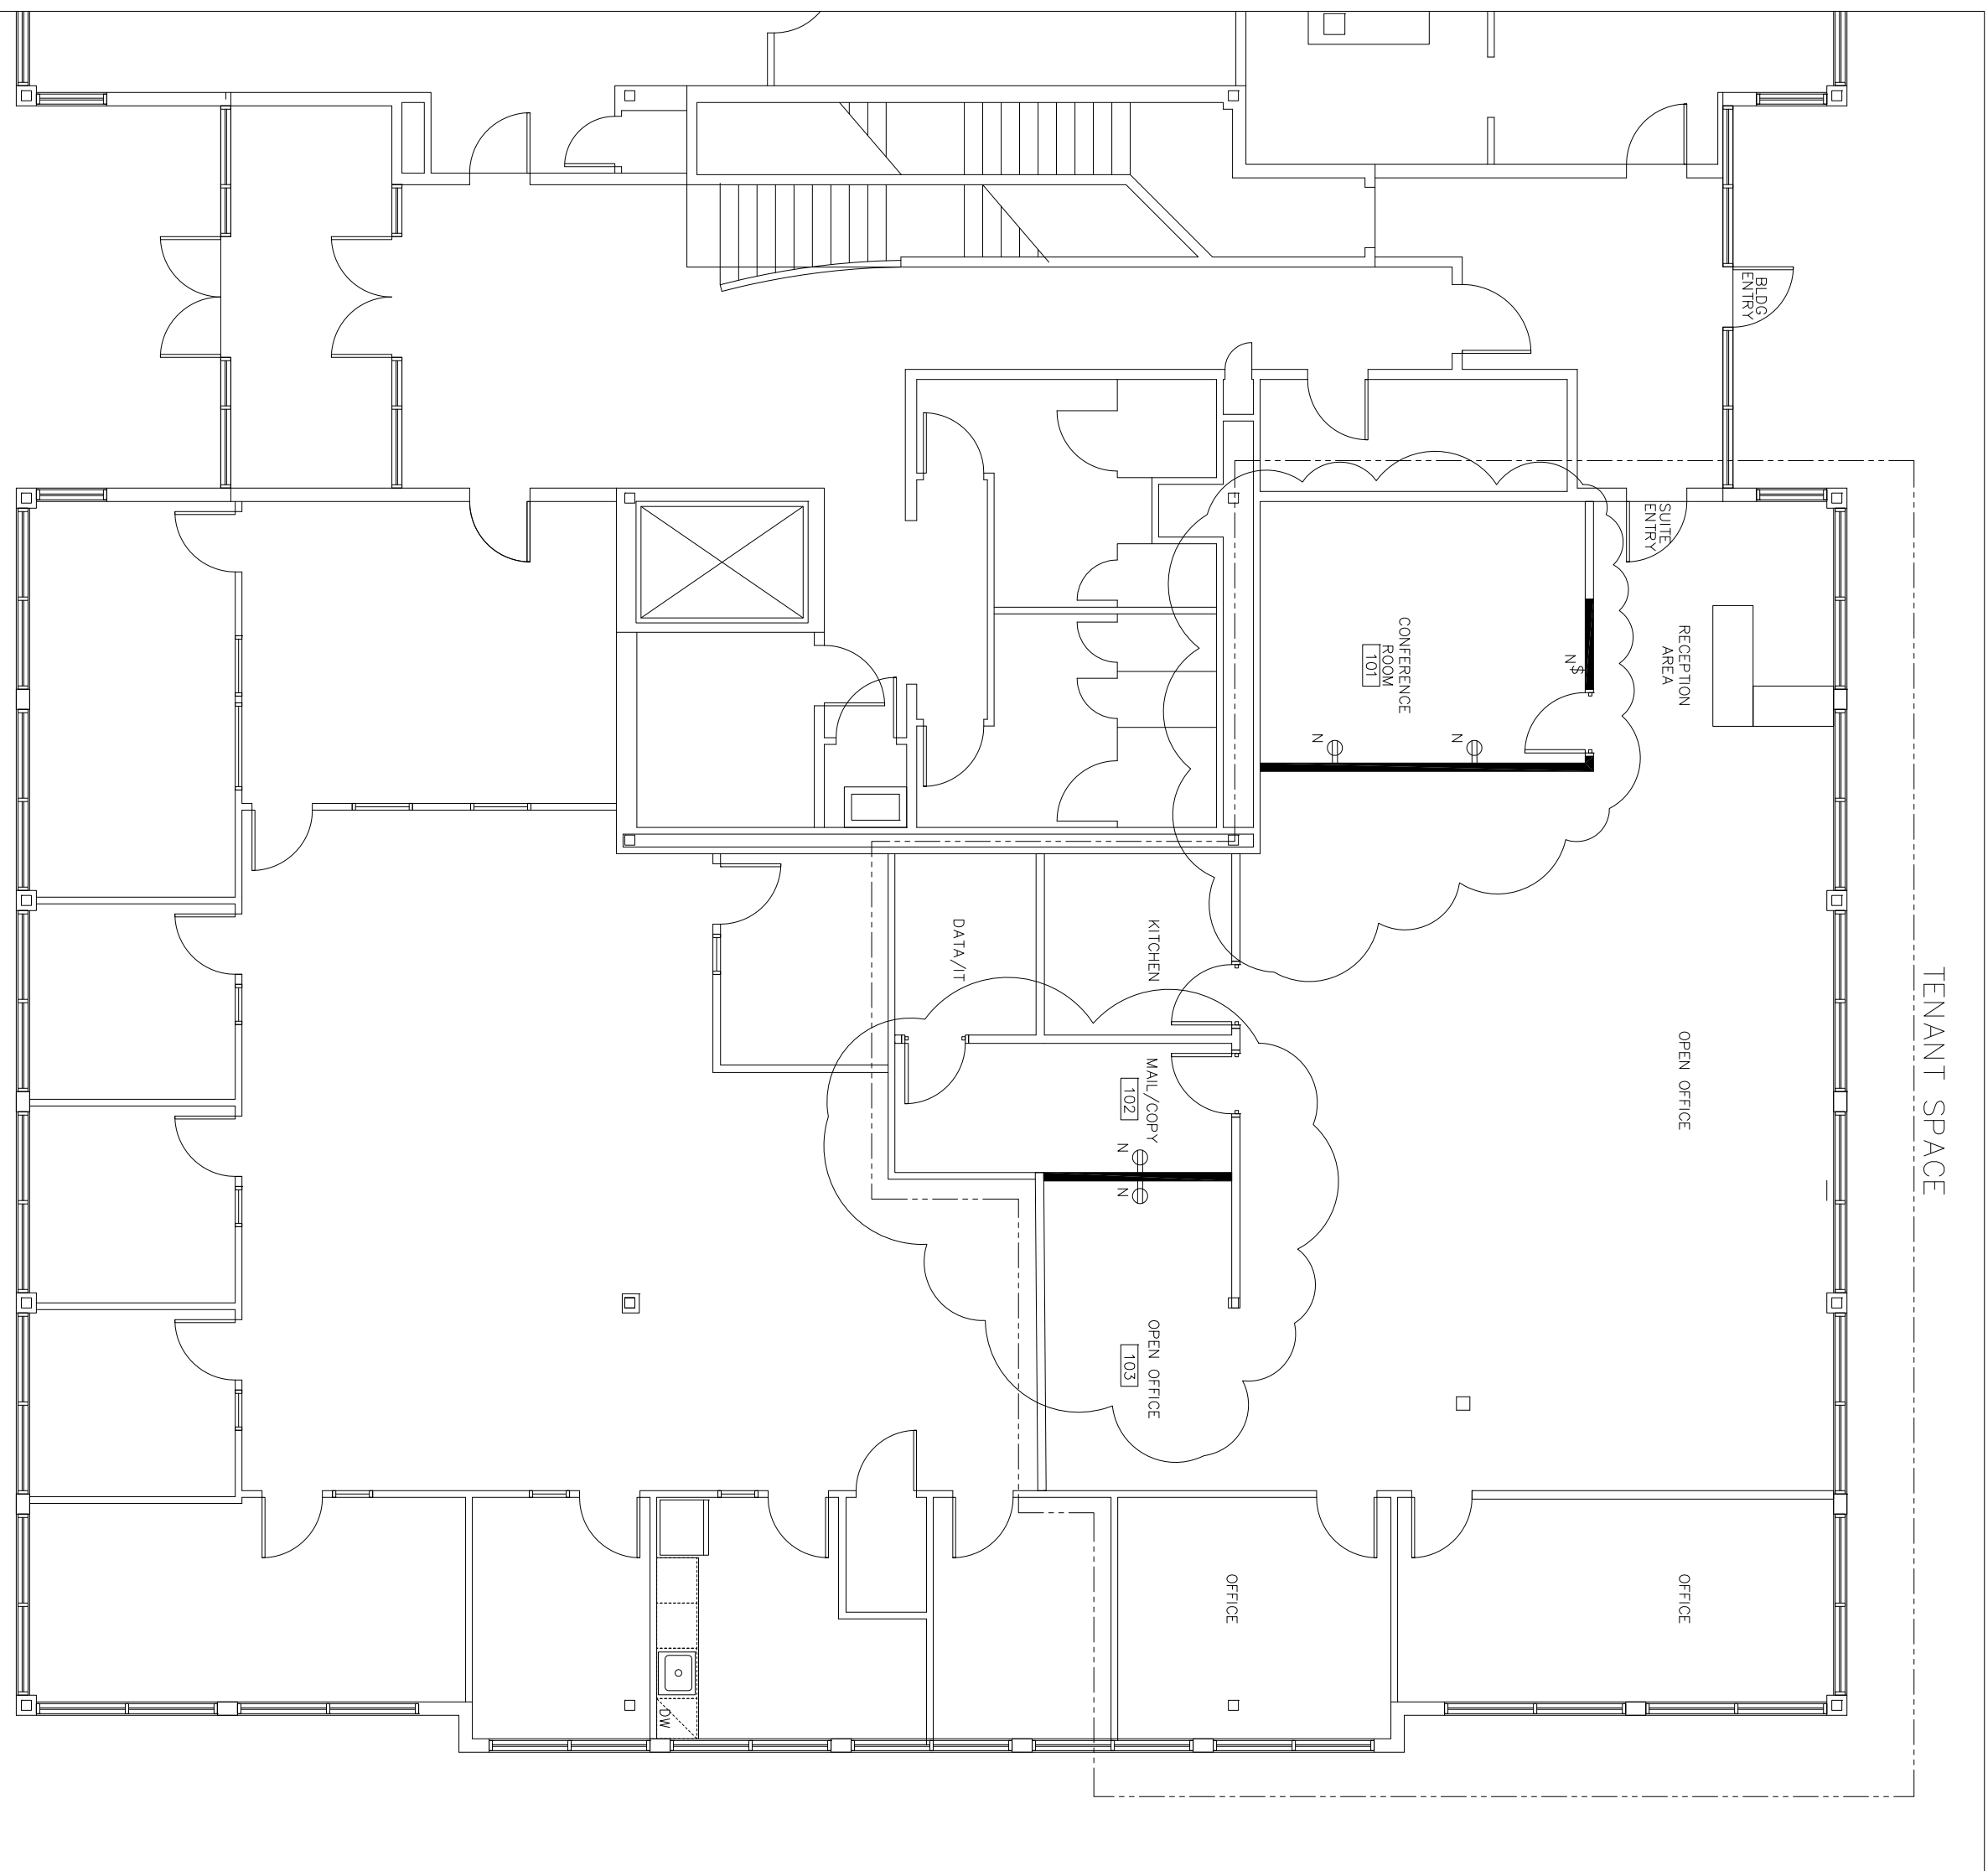


A2 SYMBOL KEY & NOTES

A1 ELECTRICAL PLAN
1/8" = 1'-0"



NO	DATE	REVISIONS

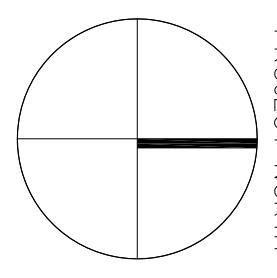

STROUDWATER CROSSING
SUITE 1
CONGRESS STREET - PORTLAND, ME


TITLE
ELECTRICAL PLAN

SCALE
1/8" = 1'-0"

DATE 9/6/16

DRAWN BY JAT

CHECKED BY -

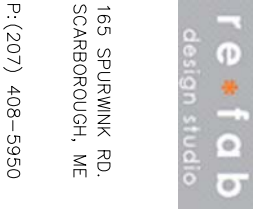

A911

16.901