



LEGEND	
SYMBOL	DESCRIPTION
	WATER HAMMER ARRESTOR
	BALL VALVE (SHUT-OFF)
	VENT THRU ROOF
	CLEANOUT
	ELECTRIC WATER HEATER
	VERIFY IN FIELD

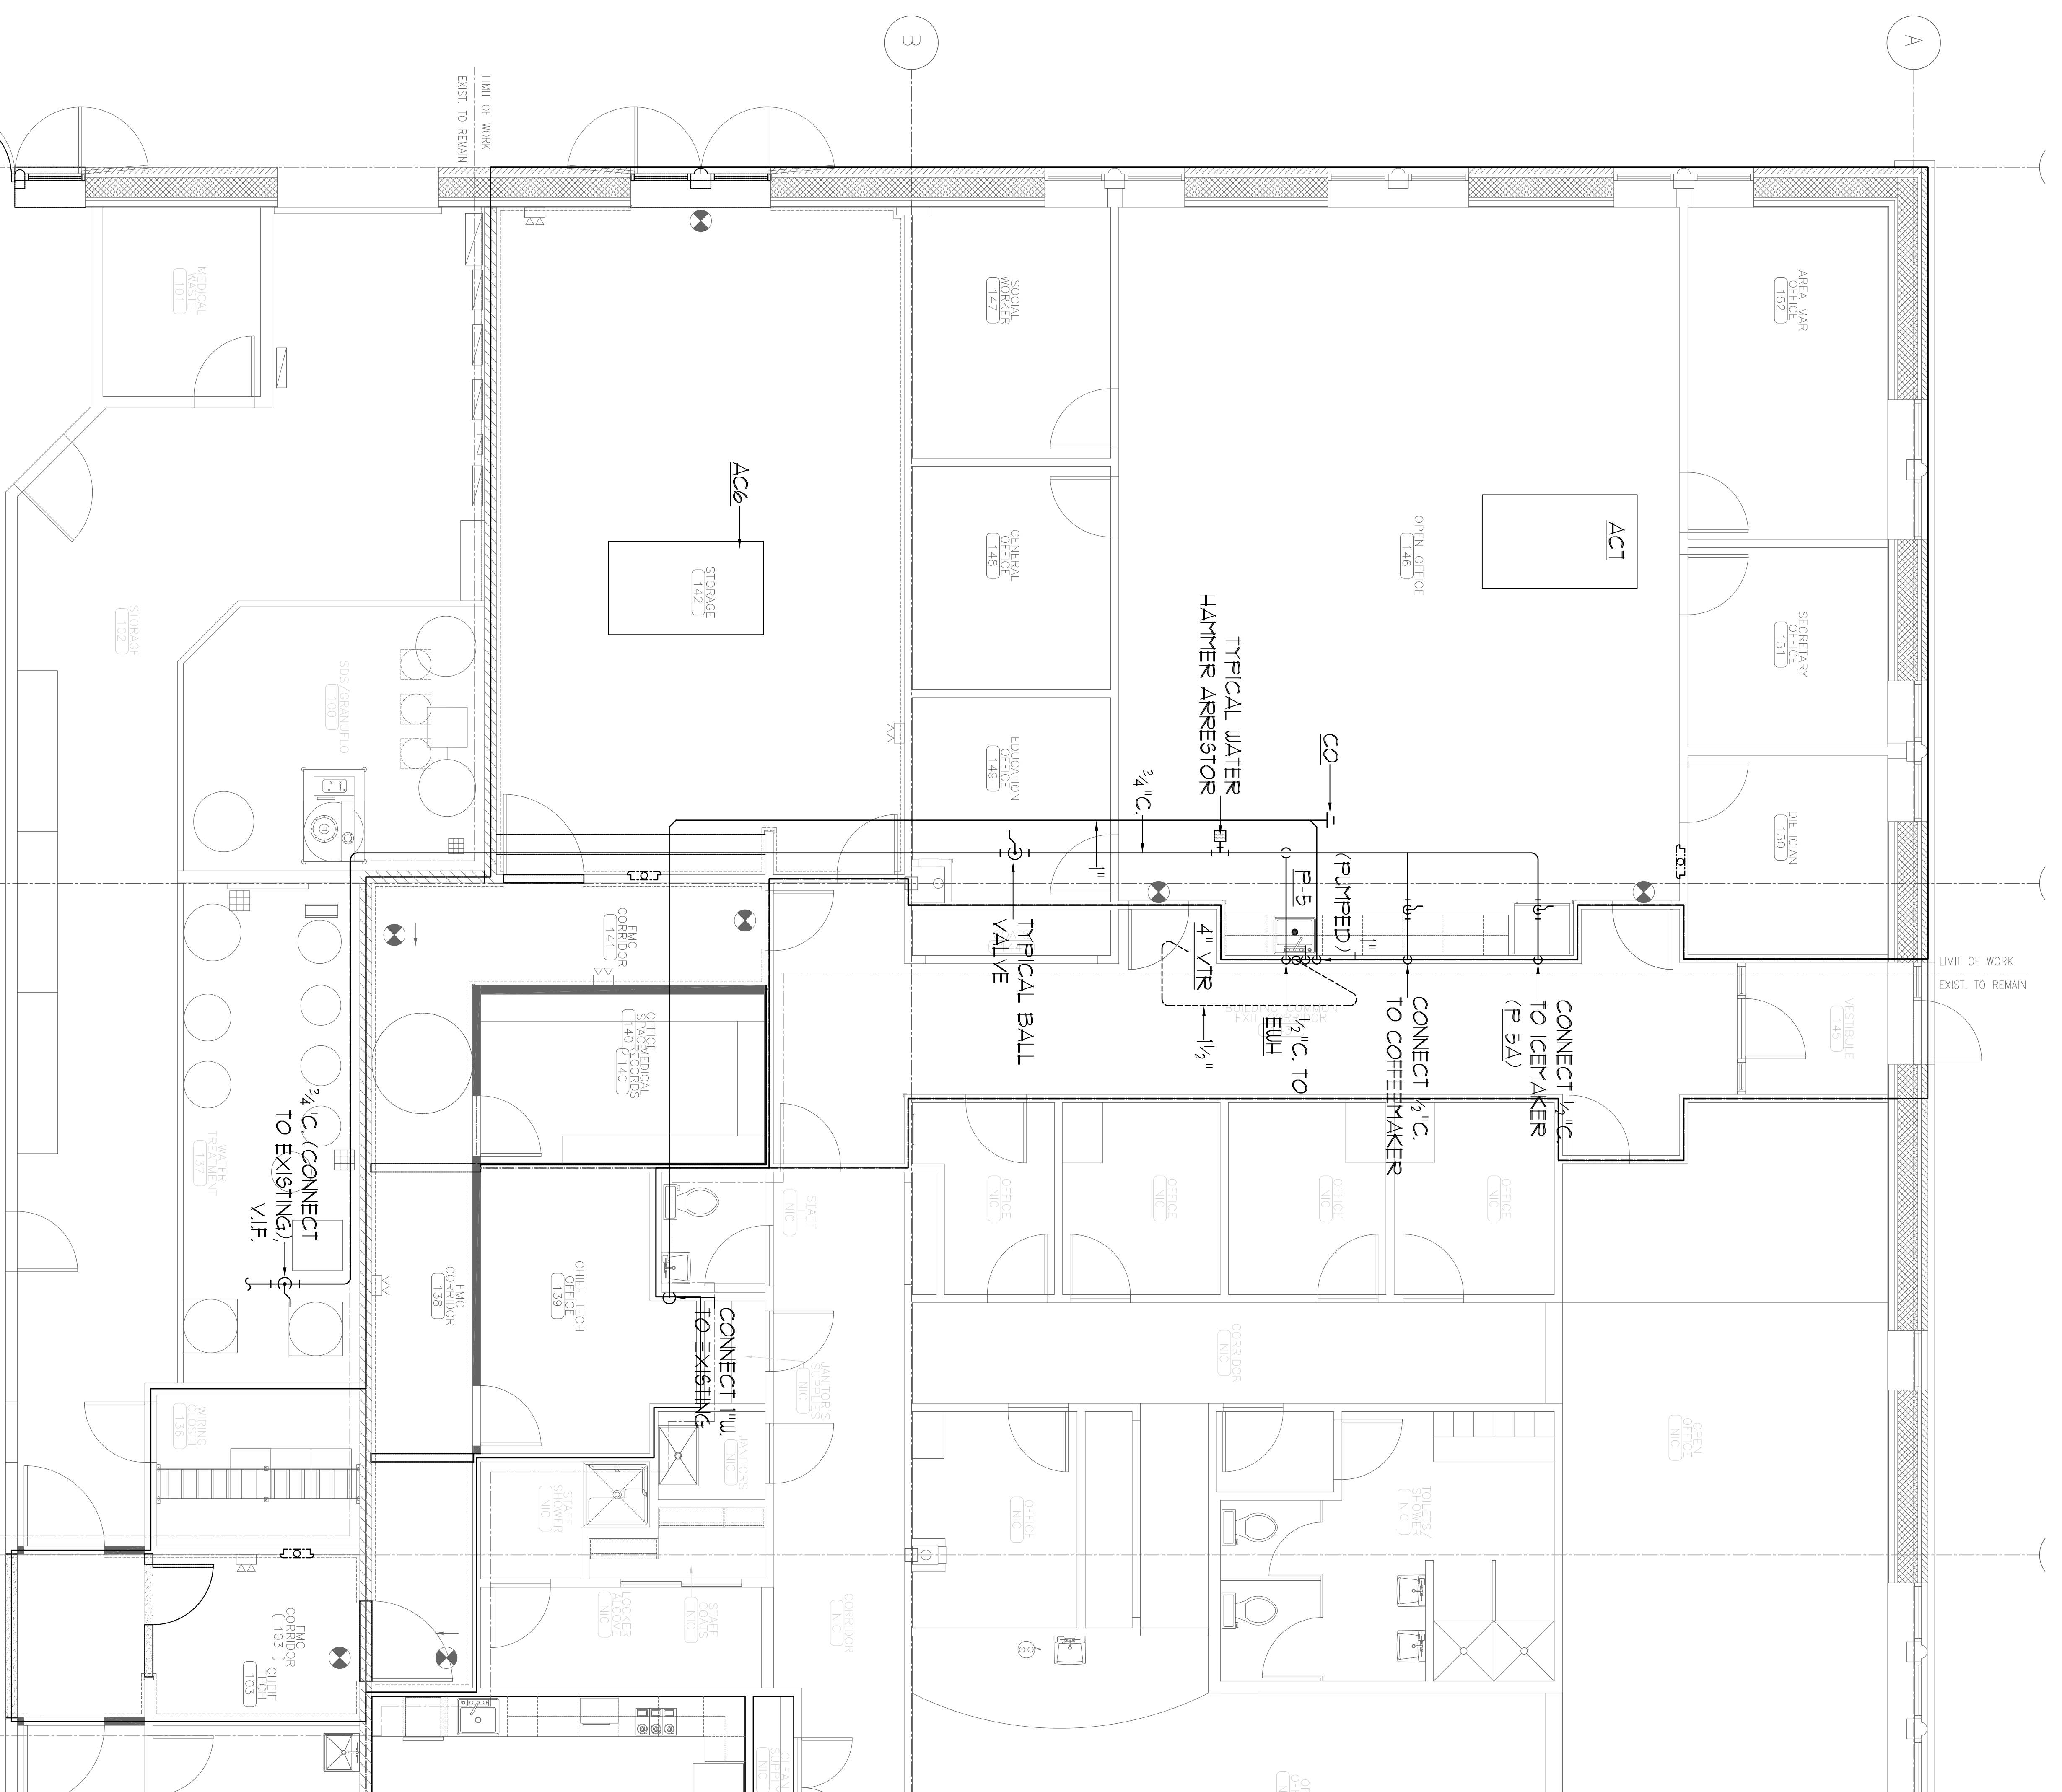


PLUMBING FLOOR PLAN
1/4" = 1'-0"

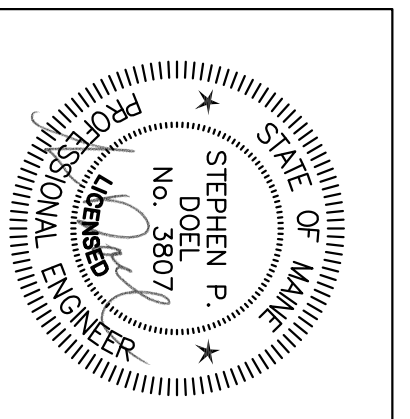

CWS
Architects
Phone: (207)774-4441

BENNETT ENGINEERING
MECHANICAL & ELECTRICAL
(207) 865-9445

Dialysis Clinic Fit-up:
SOUTHERN MAINE DIALYSIS
#1190
1600 CONGRESS STREET
PORTLAND, MAINE 04102

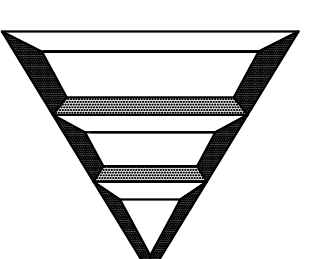

Designed By:	SP Doel	
Checked By:	SP Doel	
Date Drawn:	03/14/12	
Project #:	CWS# 11418	
REV #	DATE	REVISION DESCRIPTION
	03/14/12	Issued for Construction

P2.0
Sheet Number