

REVISION DESCRIPTION	DATE

DRAWING NUMBER

A9.01

SCALE: 3/16"=1'-0"
DATE: 12/22/11

FLOOR FINISH LEGEND:


- = NEW CARPET (CPT1)
- = NEW CARPET (CPT2)
- = NEW ENTRY MAT (MAT1)

VCT COLOR SCHEME:

- = NEW VINYL COMPOSITE TILE
FIELD COLOR VCT1
- = NEW VINYL COMPOSITE TILE
ACCENT COLOR VCT2

GENERAL FLOOR FINISH NOTES:

1. EXTEND FLOOR FINISHES UNDER CASEWORK, COUNTERTOPS AND ALL PLUMBING FIXTURES. TYPICAL ALL SPACES.
2. PREPARE CONCRETE SLAB AS REQUIRED PER FLOORING MANUFACTURER'S REQUIREMENTS PRIOR TO FLOOR FINISH INSTALLATIONS.
3. REFERENCE FLOOR FINISH SCHEDULE, LEGEND & SPECIFICATION FOR MATERIALS.
4. REFERENCE FLOOR FINISH SCHEDULE FOR ADDITIONAL ACCENT PAINT LOCATIONS

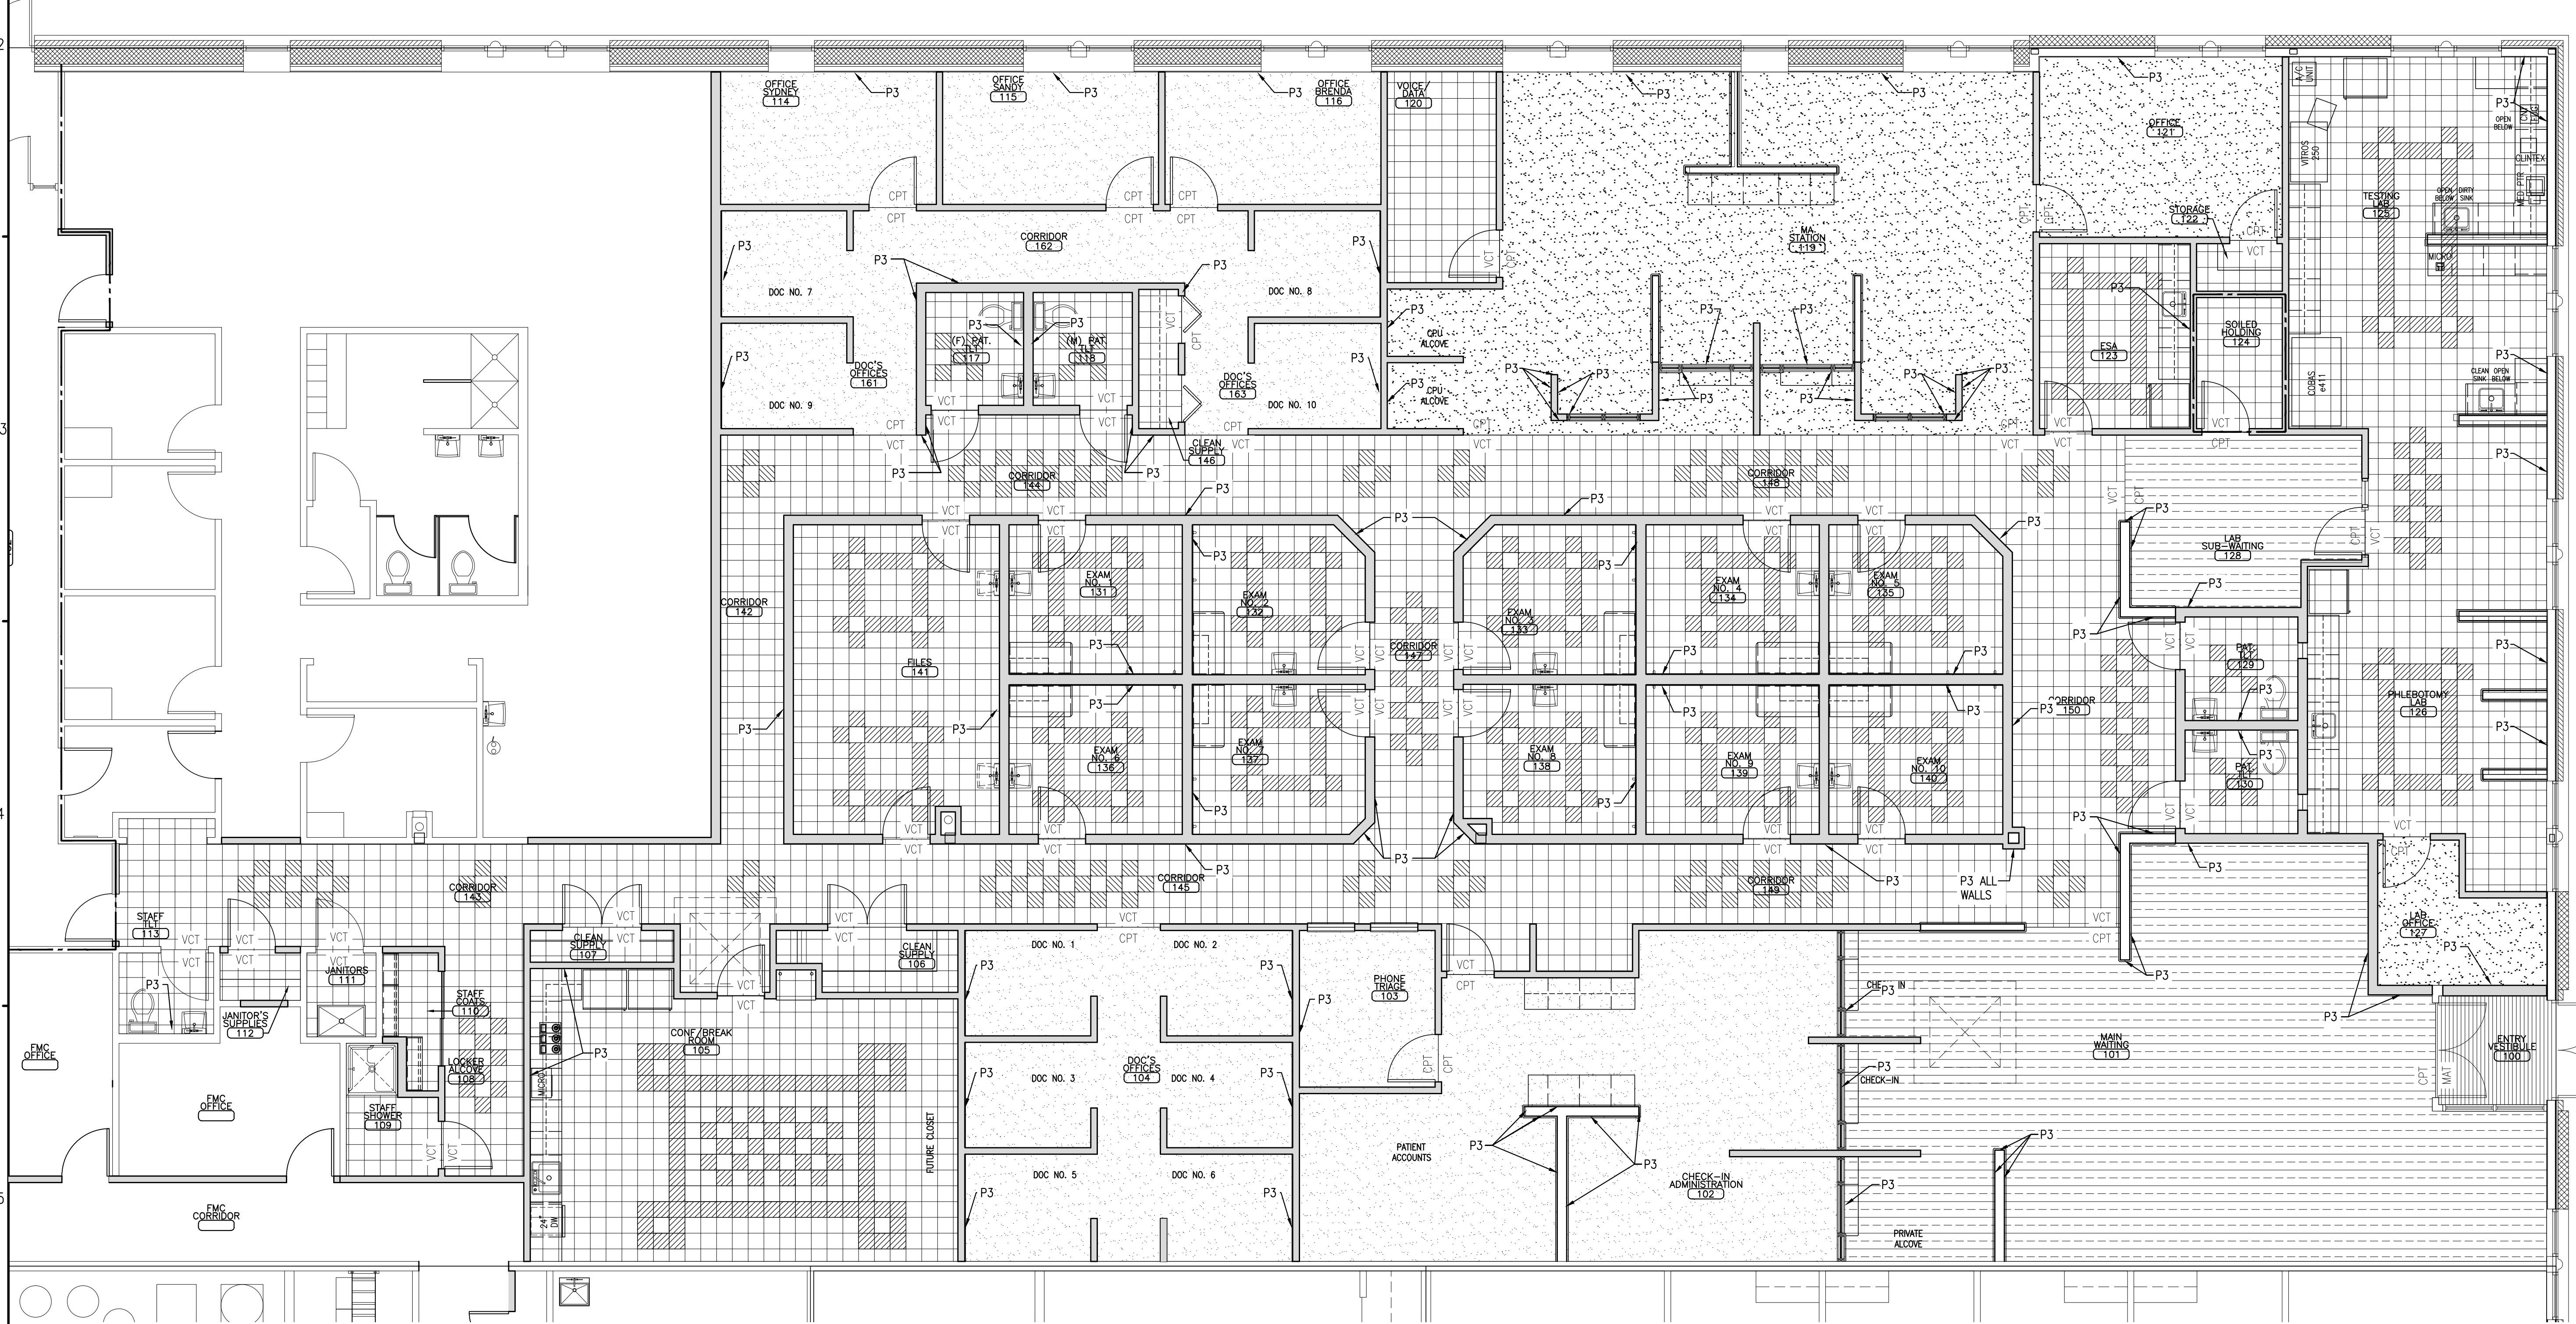

A5 FLOOR FINISHES PLAN

REFERENCED FROM: SCALE: 3/16"=1'-0"