




CWS
Architects

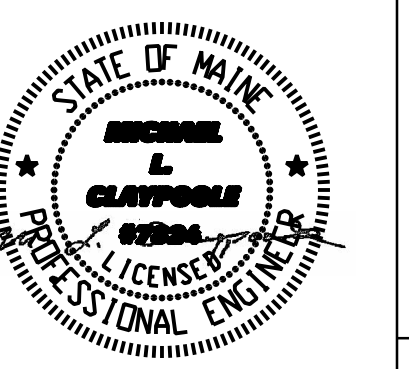

BENNETT ENGINEERING
MECHANICAL • ELECTRICAL
(207) 865-9475

OWNER / DEVELOPER
COMMERCIAL PROPERTIES, INC.
100 SILVER STREET
PORTLAND, ME 04101

PROJECT TITLE
NEPHROLOGY ASSOCIATES - RENOVATIONS
1600 CONGRESS STREET
PORTLAND, MAINE

DRAWING TITLE
**ELECTRICAL PLAN
BID ALTERNATES
No. 3 & 4**
CWS PROJ. NO.: 11422


DATE
12/22/11

REVISION DESCRIPTION
ISSUED FOR CONSTRUCTION

DRAWING NUMBER

EBA

SCALE: AS NOTED
DATE: 12/22/2011

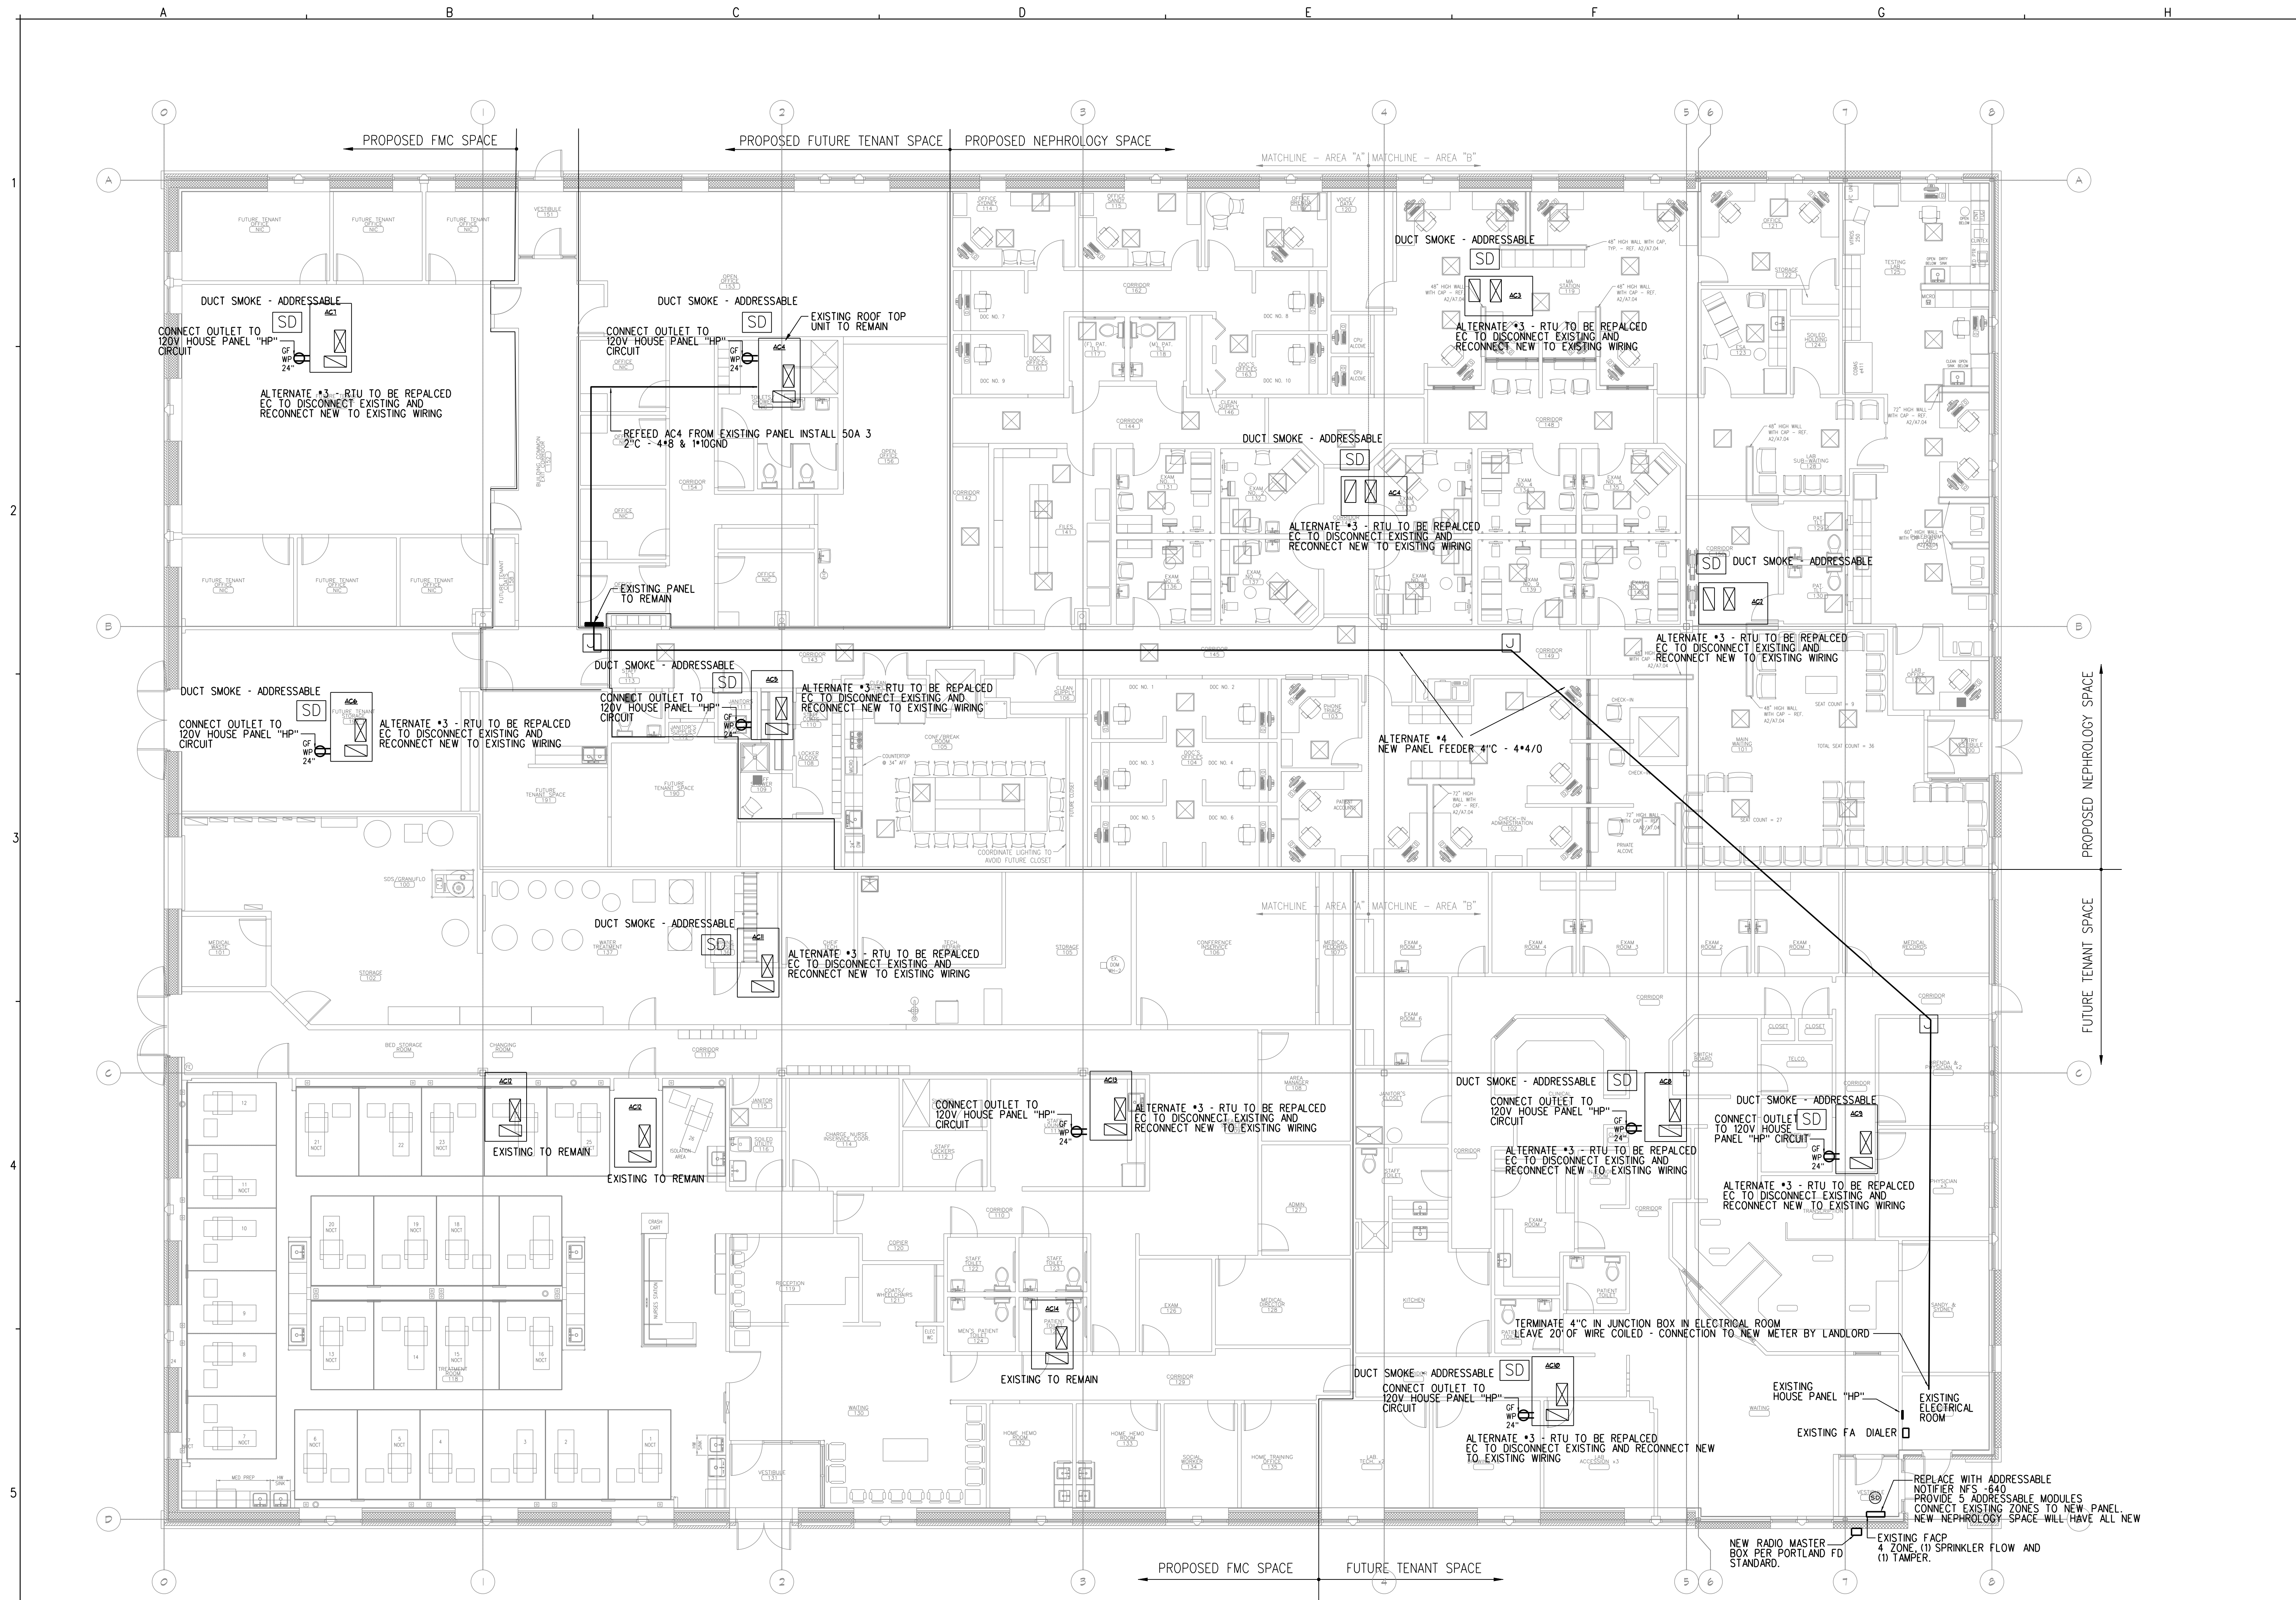

ELECTRICAL PLAN BID ALTERNATES No. 3 & 4

REFERENCED FROM:

SCALE: 1/8" = 1'-0"