



INTERIOR ELEVATOR RISERS

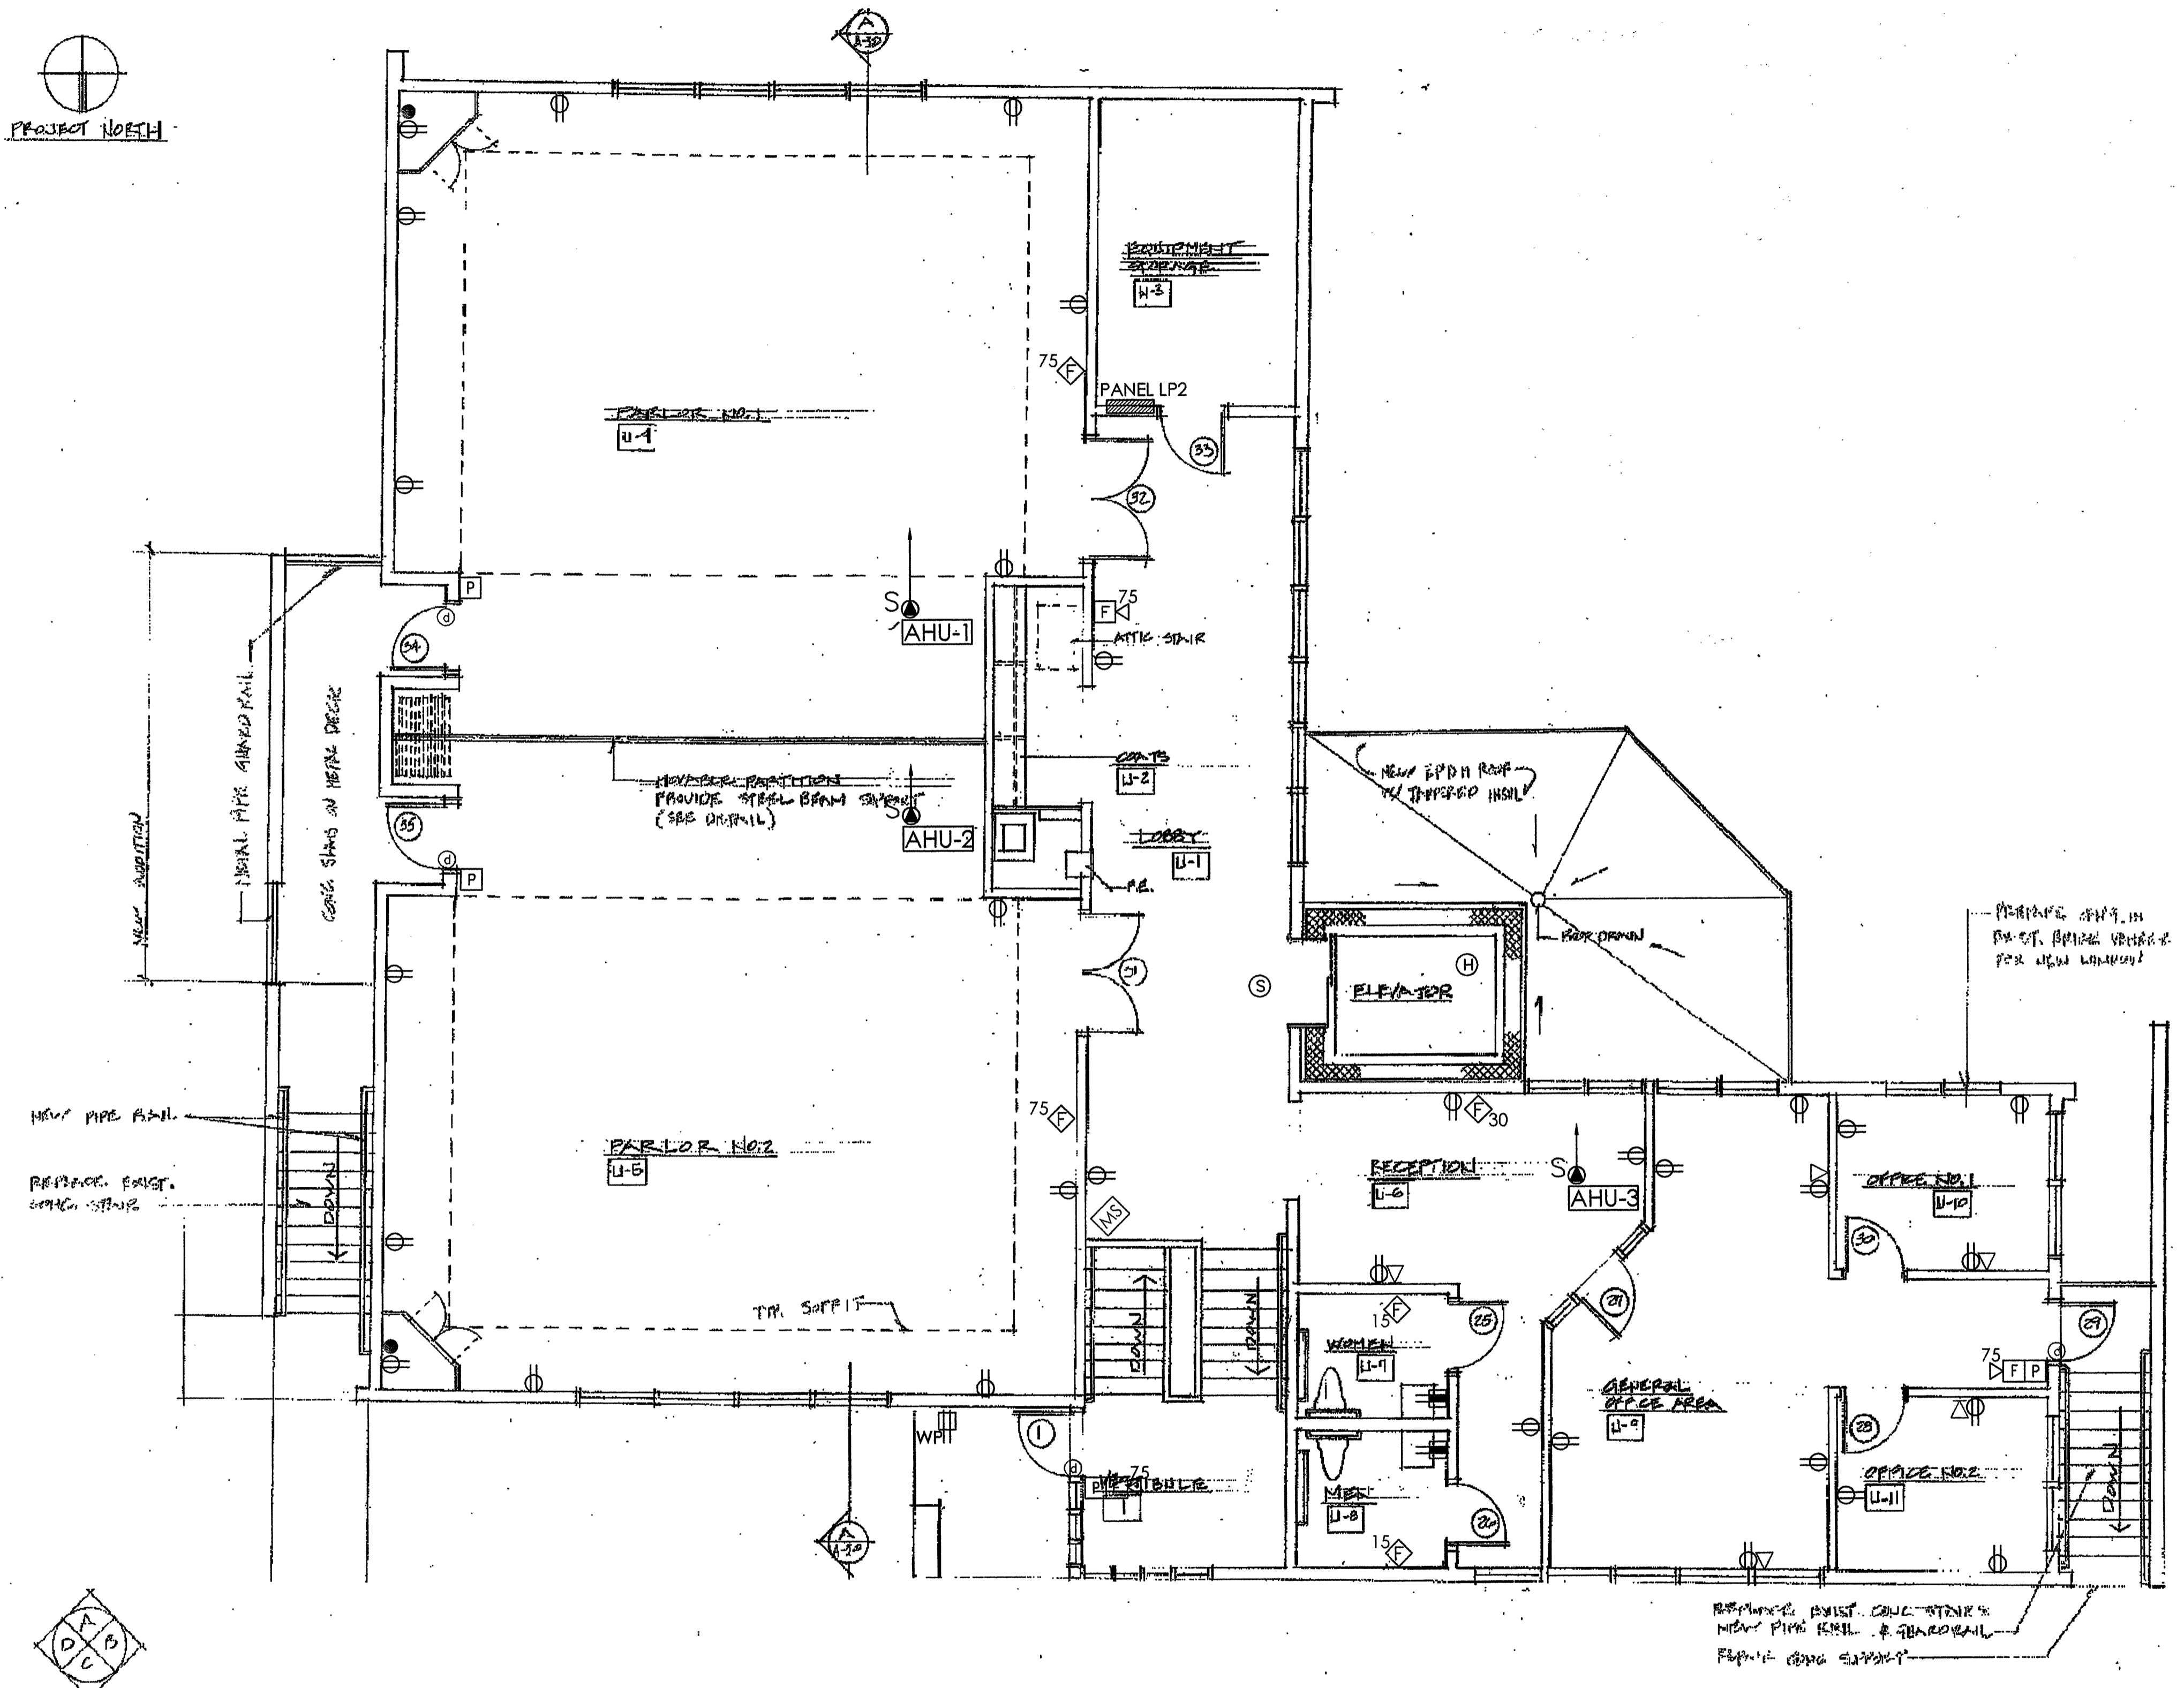

September 18, 2009
Building Permit Submission
Review and Approval
NOT FOR CONSTRUCTION

Anthony Mancini, Inc.
 179 SHERIDAN ST.
 PORTLAND, ME 04101
 P: (207) 774-5829 F: (207) 772-1686
 E: info@mancinielectric.com
 "We appreciate Your Business."

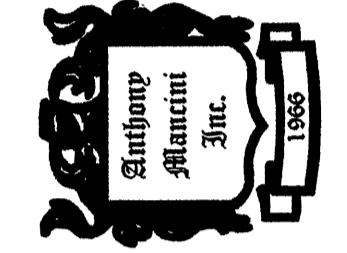

NO.	DATE	DESCRIPTION

PROJECT NAME & ADDRESS:
 Hutchins Funeral Home
 660 Brighton Ave
 Portland, Maine

SHEET NAME:
 Upper Level
 Electrical Layout

Checked By: G. MANCINI Date: 08.18.2009
 Drawn By: A. AMES Scale: 1/4" = 1'-0"

SHEET:
E5