

PROJECT TITLE: THE ALTON E. "CHUCK" CIANCHETTE
 SCOUT SERVICE CENTER
 PINE TREE COUNCIL, BOY SCOUTS OF AMERICA
 PORTLAND, ME.
 CURRENT ISSUE STATUS:
ISSUED FOR CONSTRUCTION
 8-31-04

REV	DESCRIPTION	DATE
0	ISSUED FOR CONSTRUCTION	3-31-04

GRAPHIC SCALE:
 0" = 1"
 SCALE: 1/8"=1'-0"
 PROJECT MANAGER: JLH
 JC/DRAWN BY: RJL
 A/E OF RECORD: JLH
 SMRT CAD FILE: AE101-03152
 PROJECT NO: 03152
 DATE: 3-31-04
 SHEET TITLE:


FIRST FLOOR
 PLAN
DEMO
 SHEET No.
 AE101

GENERAL NOTES:

- DO NOT SCALE THE DRAWINGS.
- ALL SEALANT, FIRE STOPPING, AND SMOKE STOPPING ASSEMBLIES SHALL BE U.L. RATED.
- DIMENSIONS ARE FACE OF MASONRY, AND CENTERLINE OF STUD PARTITIONS, UNLESS INDICATED OTHERWISE.
- REFER TO SHEET G1002 FOR TYPICAL MOUNTING HEIGHTS OF PLUMBING FIXTURES, RESTROOM ACCESSORIES & MISCELLANEOUS ITEMS.
- REFER TO G1002 FOR TOP OF WALL DETAILS.
- REFER TO ALL CONSTRUCTION DOCUMENTS FOR REQUIREMENTS WHICH MAY AFFECT THE WORK IN ANOTHER AND COORDINATE WORK.
- REFERENCE DETAILS FOR ADDITIONAL DIMENSIONAL INFORMATION.
- DOOR JAMBS SHALL BE LOCATED 6" FROM CORNER IN STUD PARTITIONS, UNLESS INDICATED OTHERWISE.
- REFER TO AE401 FOR TOILET ACCESSORIES.

LEGEND

- TEMP WALL / SAFETY / DUST
- - - REMOVE - NON STRUCTURAL
- REMOVE - STRUCTURAL (SEE STRUCT PLAN)
- DR REMOVE FOR NEW DOOR
- FILL INFILL DOOR OPENING
- REMOVE CULTURESTONE VENEER AS REQ'D

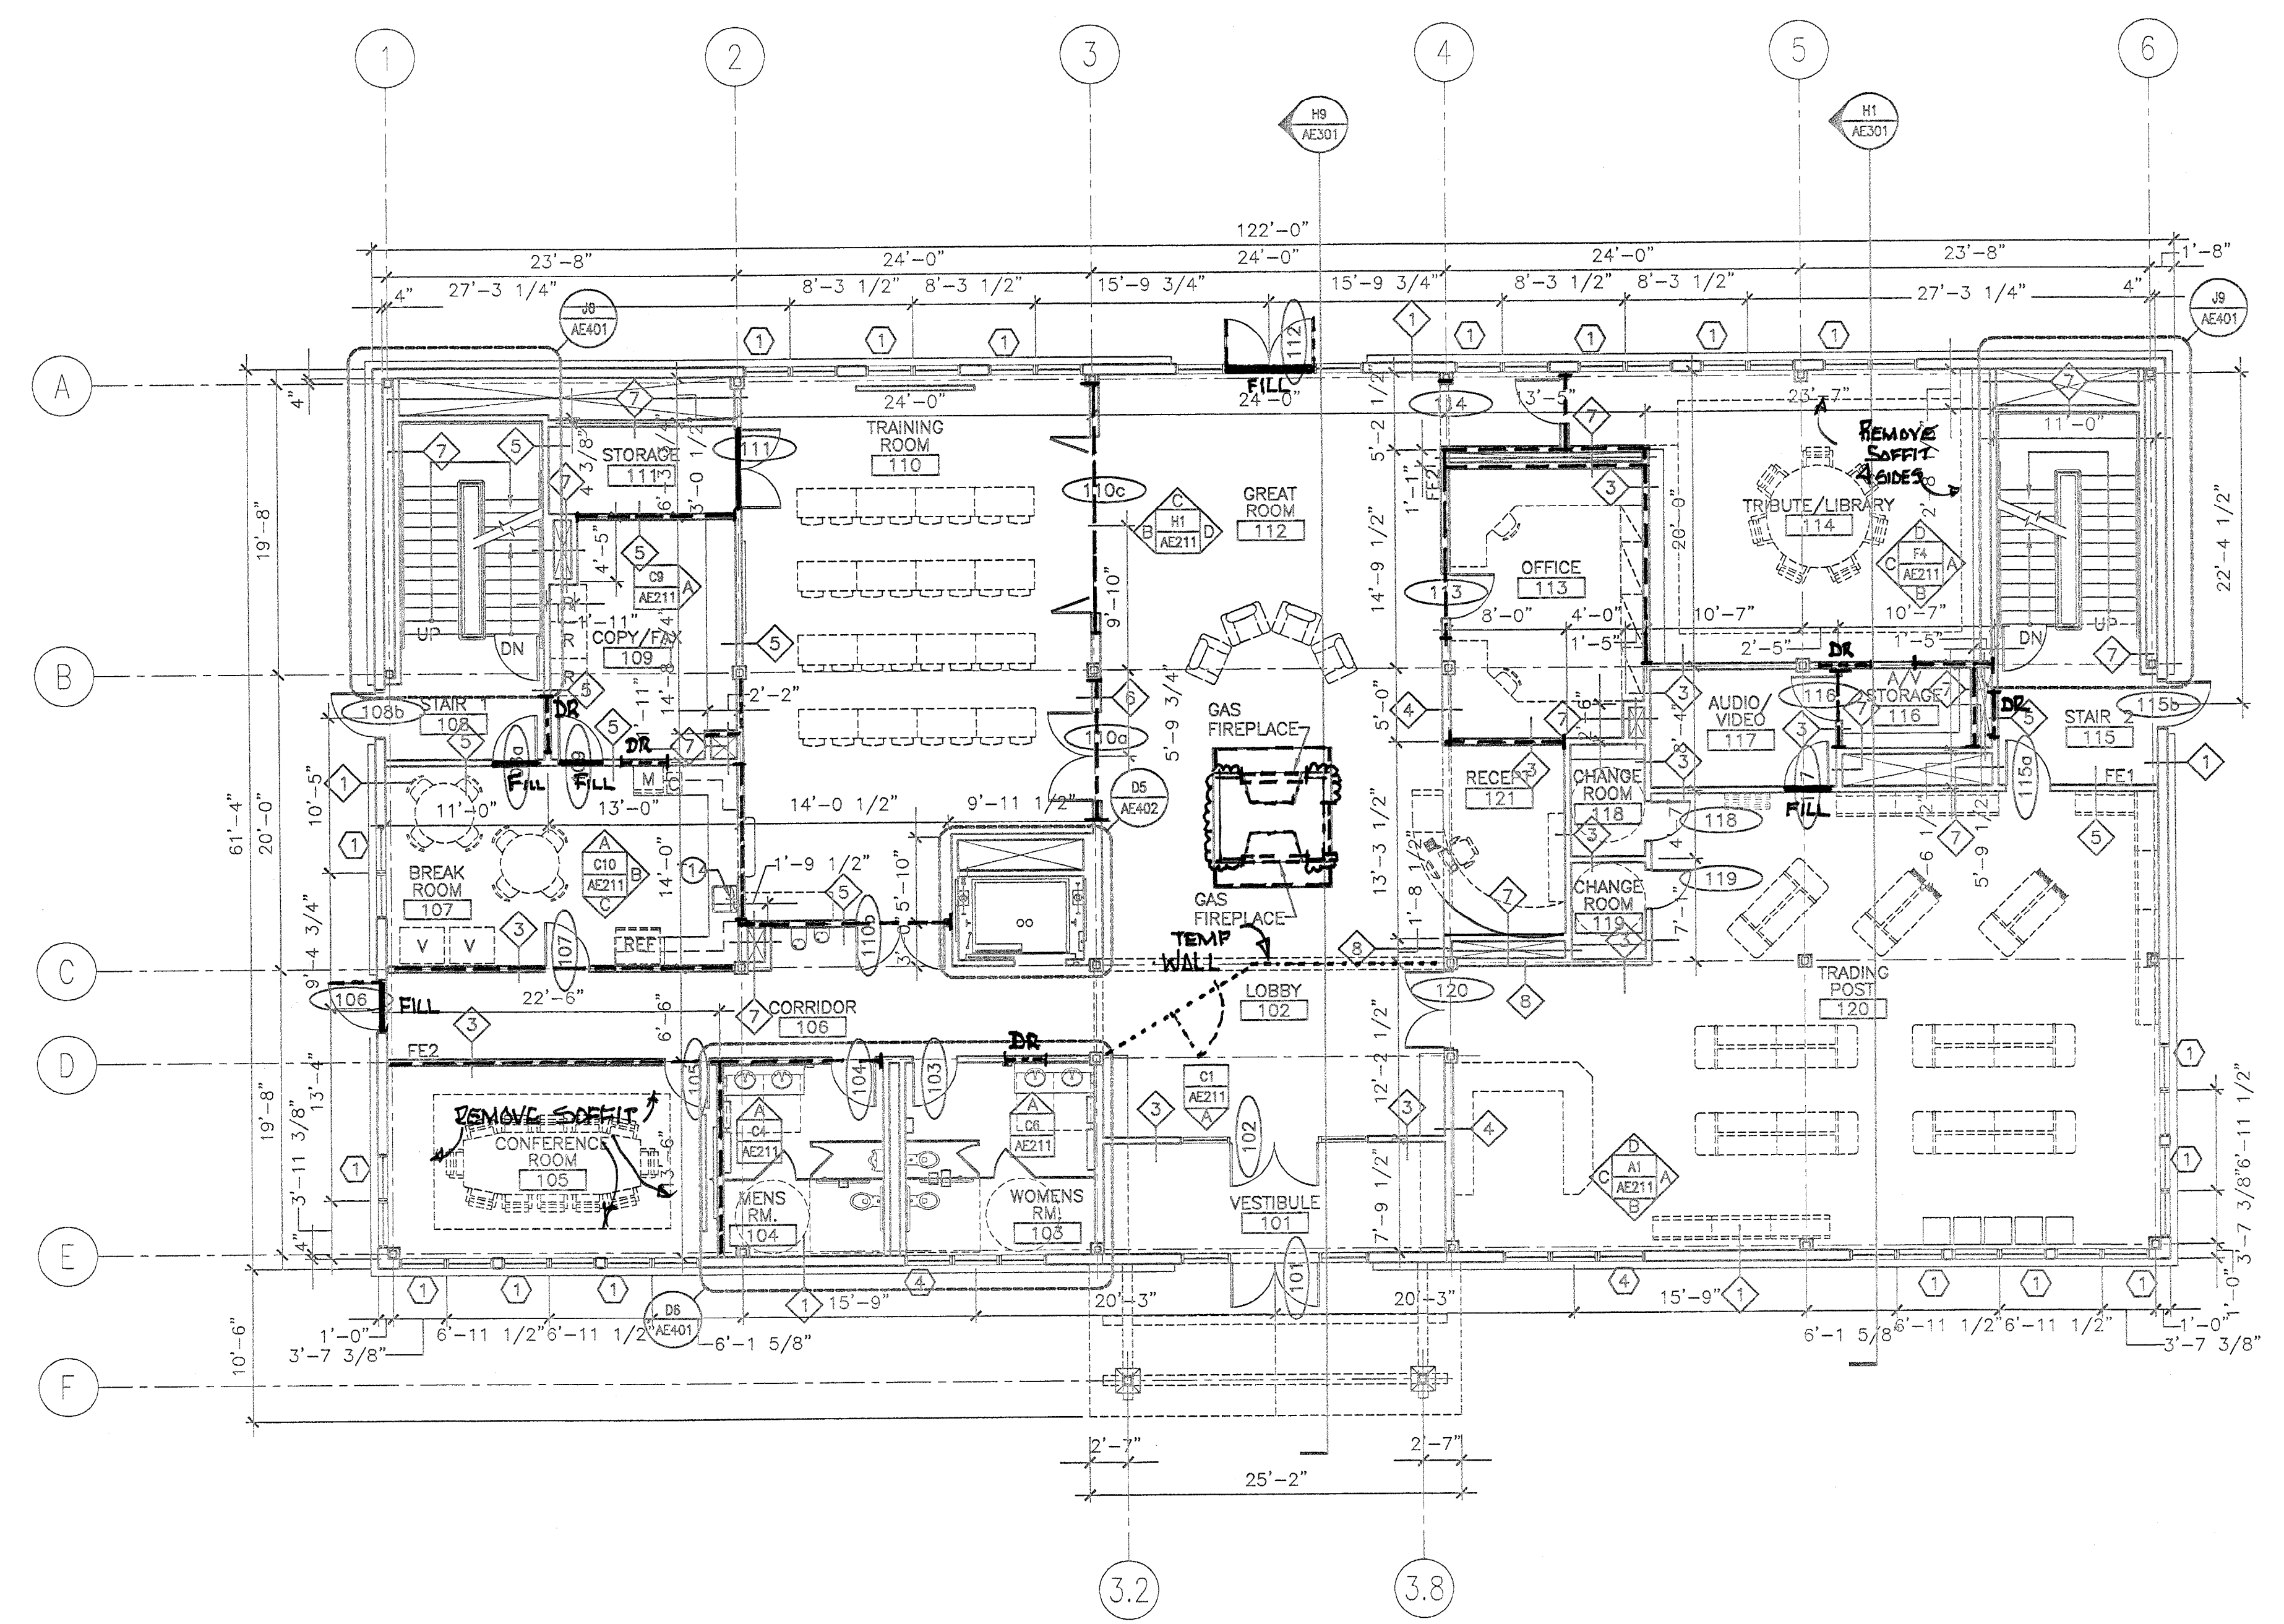

DEMO PLAN
 TCI WORKPLAN