



PROJECT TITLE:
**MAINE TURNPIKE AUTHORITY
ADMINISTRATION BUILDING**
PORTLAND, MAINE

CURRENT ISSUE STATUS:
ISSUED FOR BIDDING/CONSTRUCTION
7-9-07

REV	DESCRIPTION	DATE
0	BIDDING/CONSTRUCTION	7-9-07

GRAPHIC SCALE:
0" = 1"

SCALE: AS NOTED
PROJECT MANAGER: SLB
JC/DRAWN BY: TCM/TCM
A/E OF RECORD: SLB
CAD FILE: AE121-06016
PROJECT NO: 06016
DATE: 7-9-07

SHEET TITLE:
FIRST FLOOR REFLECTED CEILING PLAN

SHEET No. **AE121**
© COPYRIGHT 2007 SMT INC.

GENERAL NOTES:

- SEE G1001 FOR PROJECT GENERAL NOTES.

REFLECTED CEILING PLAN NOTES:


- REFERENCE ROOM FINISH SCHEDULE FOR CEILING HEIGHTS AND TYPES
- FIRE SPRINKLERS SHALL BE LOCATED IN ALIGNMENT WITH OTHER CEILING ITEMS, TYPICALLY
- FIRE SPRINKLERS SHALL BE CENTERED IN CEILING TILE
- FIRE SPRINKLERS SHALL BE PLACED TO COORDINATE WITH LIGHT FIXTURE POSITIONS INDICATED.
- ALIGN CEILING ITEMS AS SHOWN, WITH COMMON CENTERLINES, TYPICALLY. CENTER ITEMS IN CEILINGS, OR IN AREA U.N.O.
- PROVIDE ACCESS PANELS AS REQUIRED IN GWB CEILINGS FOR ACCESS TO MECHANICAL VALVES/ CONTROLS. RE: MECHANICAL DRAWINGS

SOFFIT HEIGHT SCHEDULE

- ▲ 7'-0" A.F.F.
- ▲ 7'-6" A.F.F.
- ▲ 8'-0" A.F.F.
- ▲ 8'-6" A.F.F.
- ▲ 11'-6" A.F.F.
- ▲ 6'-10" A.F.F.

SYMBOL LEGEND

- [Hatched Box] AREA INDICATING LIMITS OF HORIZONTAL SHAFT ASSEMBLY ABOVE CEILING
- [Brick Pattern Box] HANGING BRICK SOFFIT
- [Grid Pattern Box] ALUMINUM SOFFIT/ CEILING SYSTEM
- [2x4 Grid Box] 2x4 SUSPENDED CEILING PANEL AND GRID ASSEMBLY.
- [2x2 Grid Box] 2x2 SUSPENDED CEILING PANEL AND GRID ASSEMBLY.
- [Stippled Box] GWB CEILING.
- [Circle with X] 2x4 LAY-IN LIGHT FIXTURE.
- [Circle with X] 1x4 PENDANT LIGHT FIXTURE.
- [Circle with X] DOWN LIGHT.
- [Square with X] CEILING MOUNTED EXIT LIGHT.
- [Square with X] RETURN AIR GRILLE.
- [Square with X] SUPPLY AIR GRILLE.
- [Square with X] EXHAUST AIR GRILLE.
- [Circle with X] SPRINKLER HEAD.
- [Square with X] CEILING MOUNTED SPEAKER.
- [Circle with X] CEILING MOUNTED SMOKE DETECTOR.
- [Circle with X] SLOT DIFFUSER.
- [Circle with X] CEILING MOUNTED CAMERA (N.I.C.)
- [Circle with X] CEILING MOUNTED HEAT DETECTOR
- [Circle with X] CEILING MOUNTED OCCUPANCY SENSOR

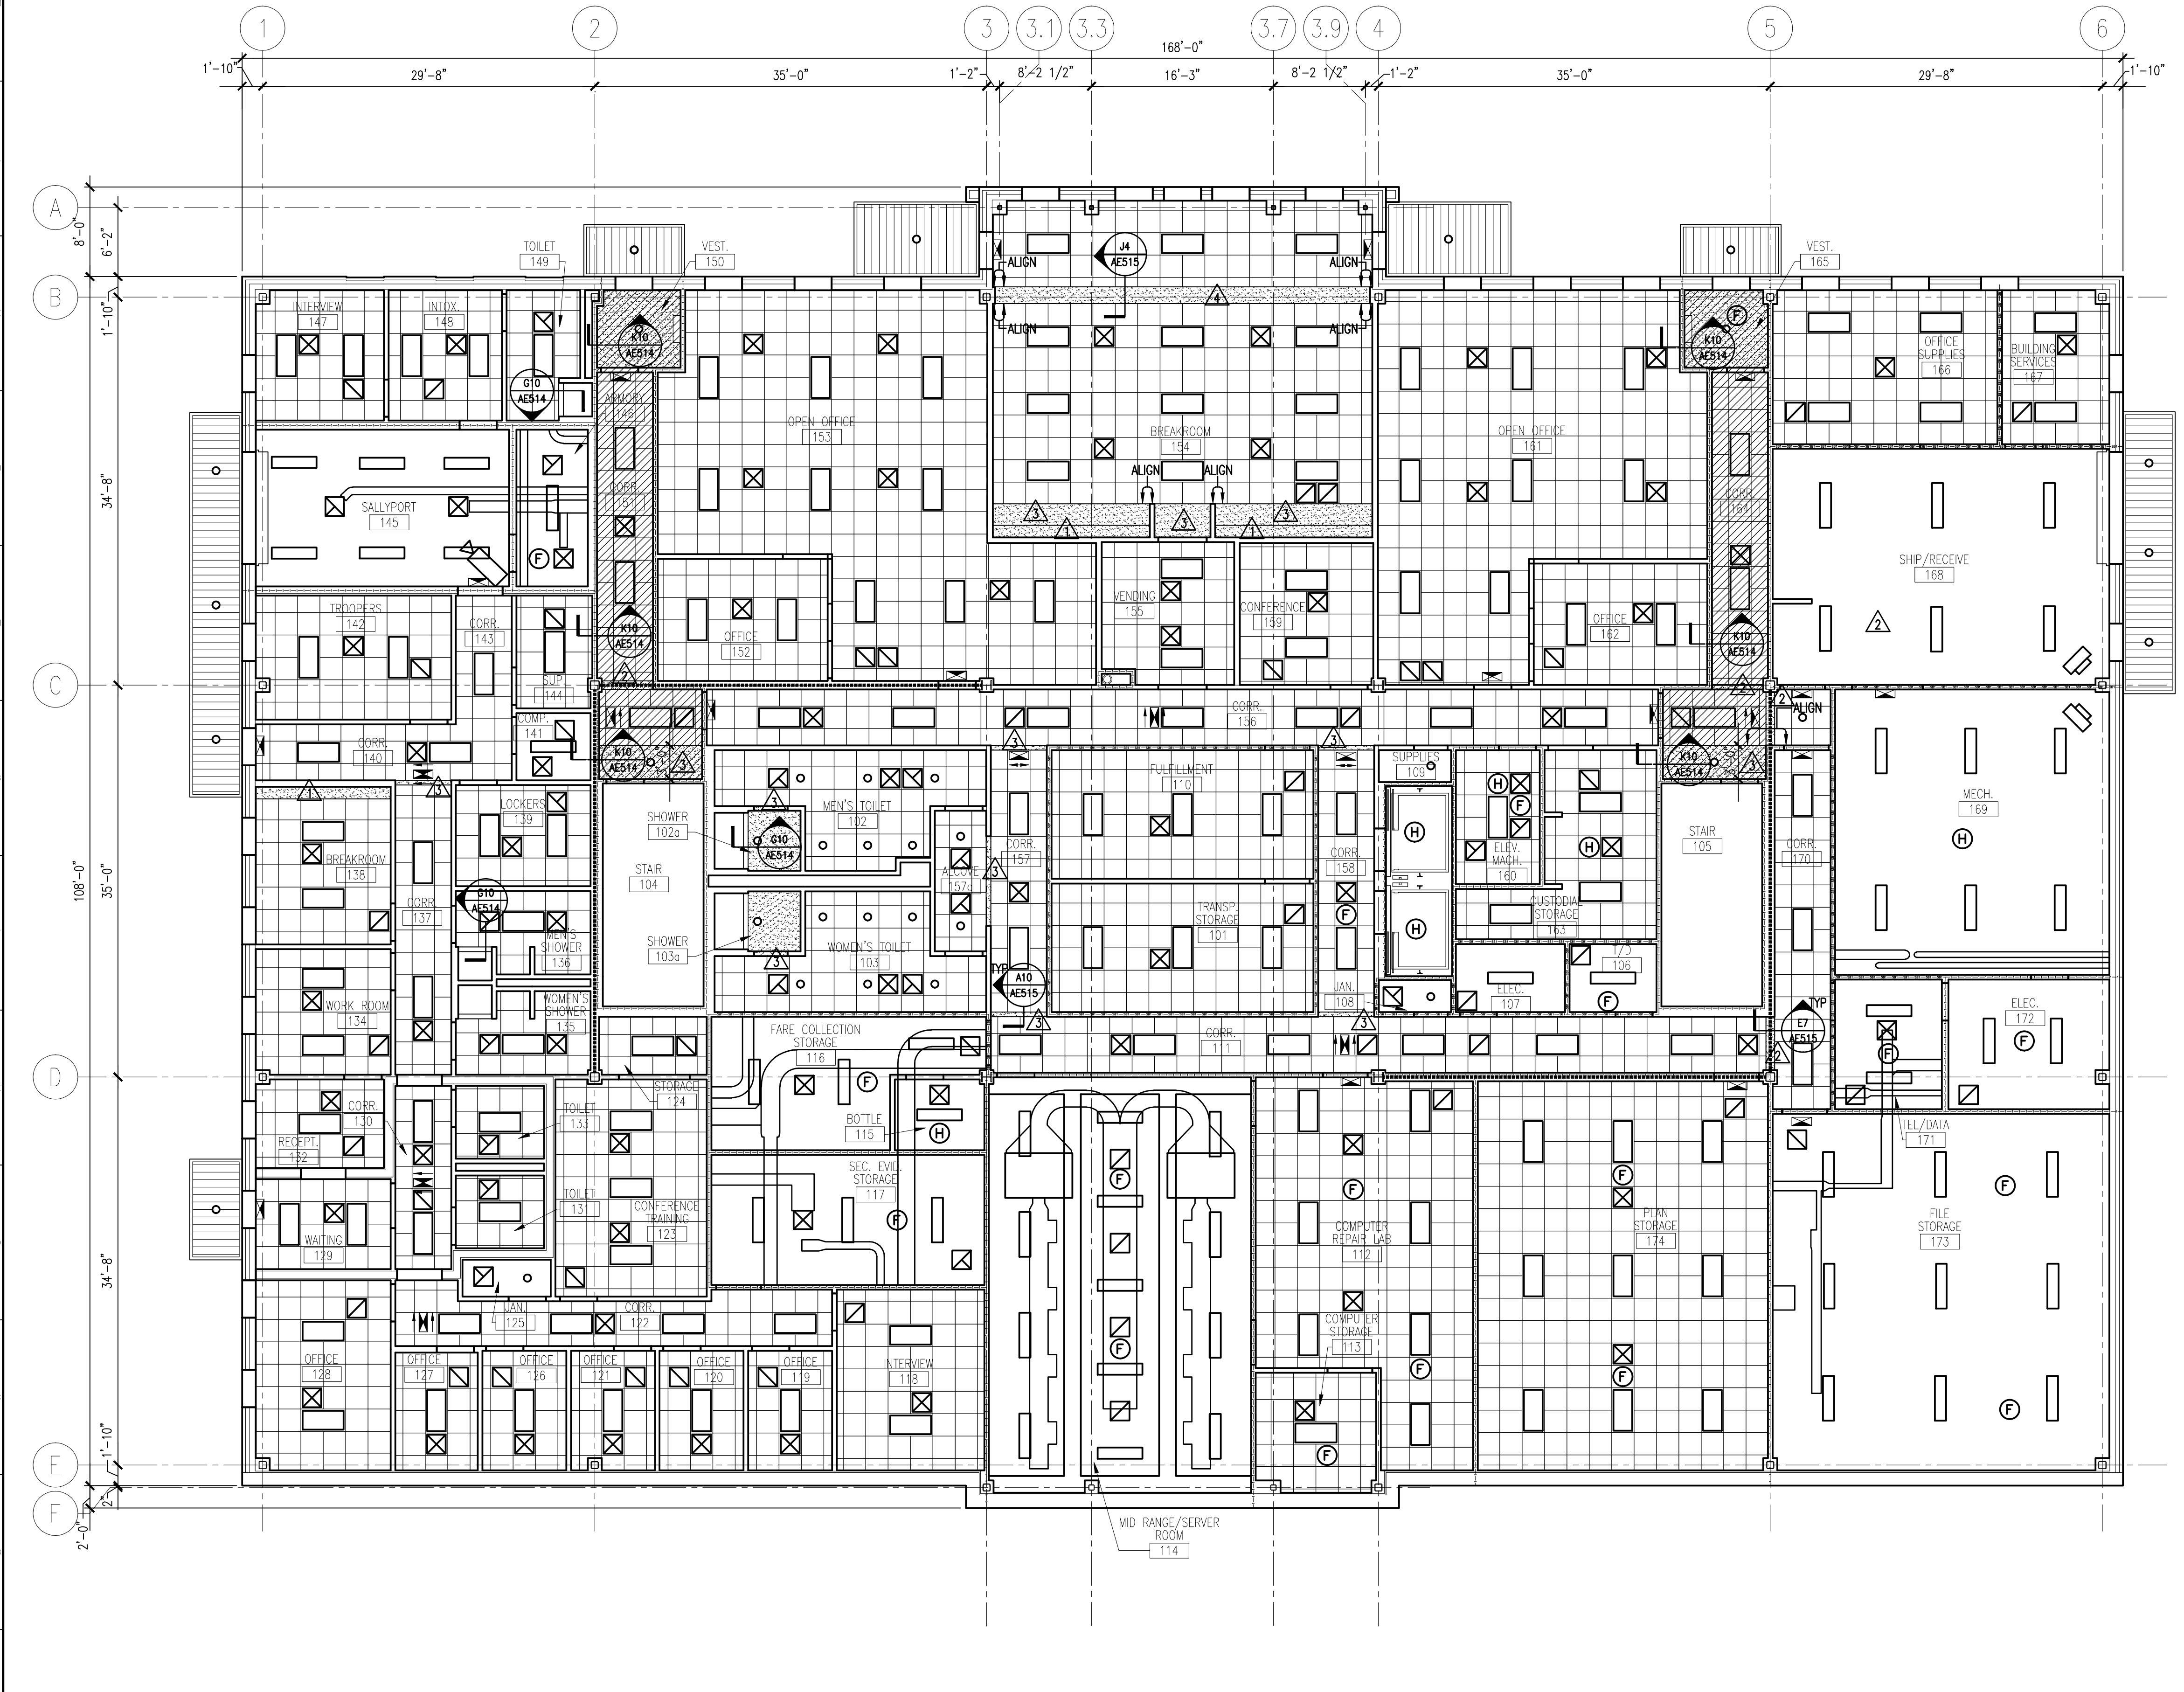

A1 FIRST FLOOR REFLECTED CEILING PLAN
1/8" = 1'-0"